


P:\Districts\SPRING LAKE IMPROVEMENT DISTRICT\14-1766-510-GRANT-WALPRON-51A-04-Engineering\Plans\07-1766-C-03-SITE.dwg, 2/19/2015 1:54:25 PM, mmarenco.1.2

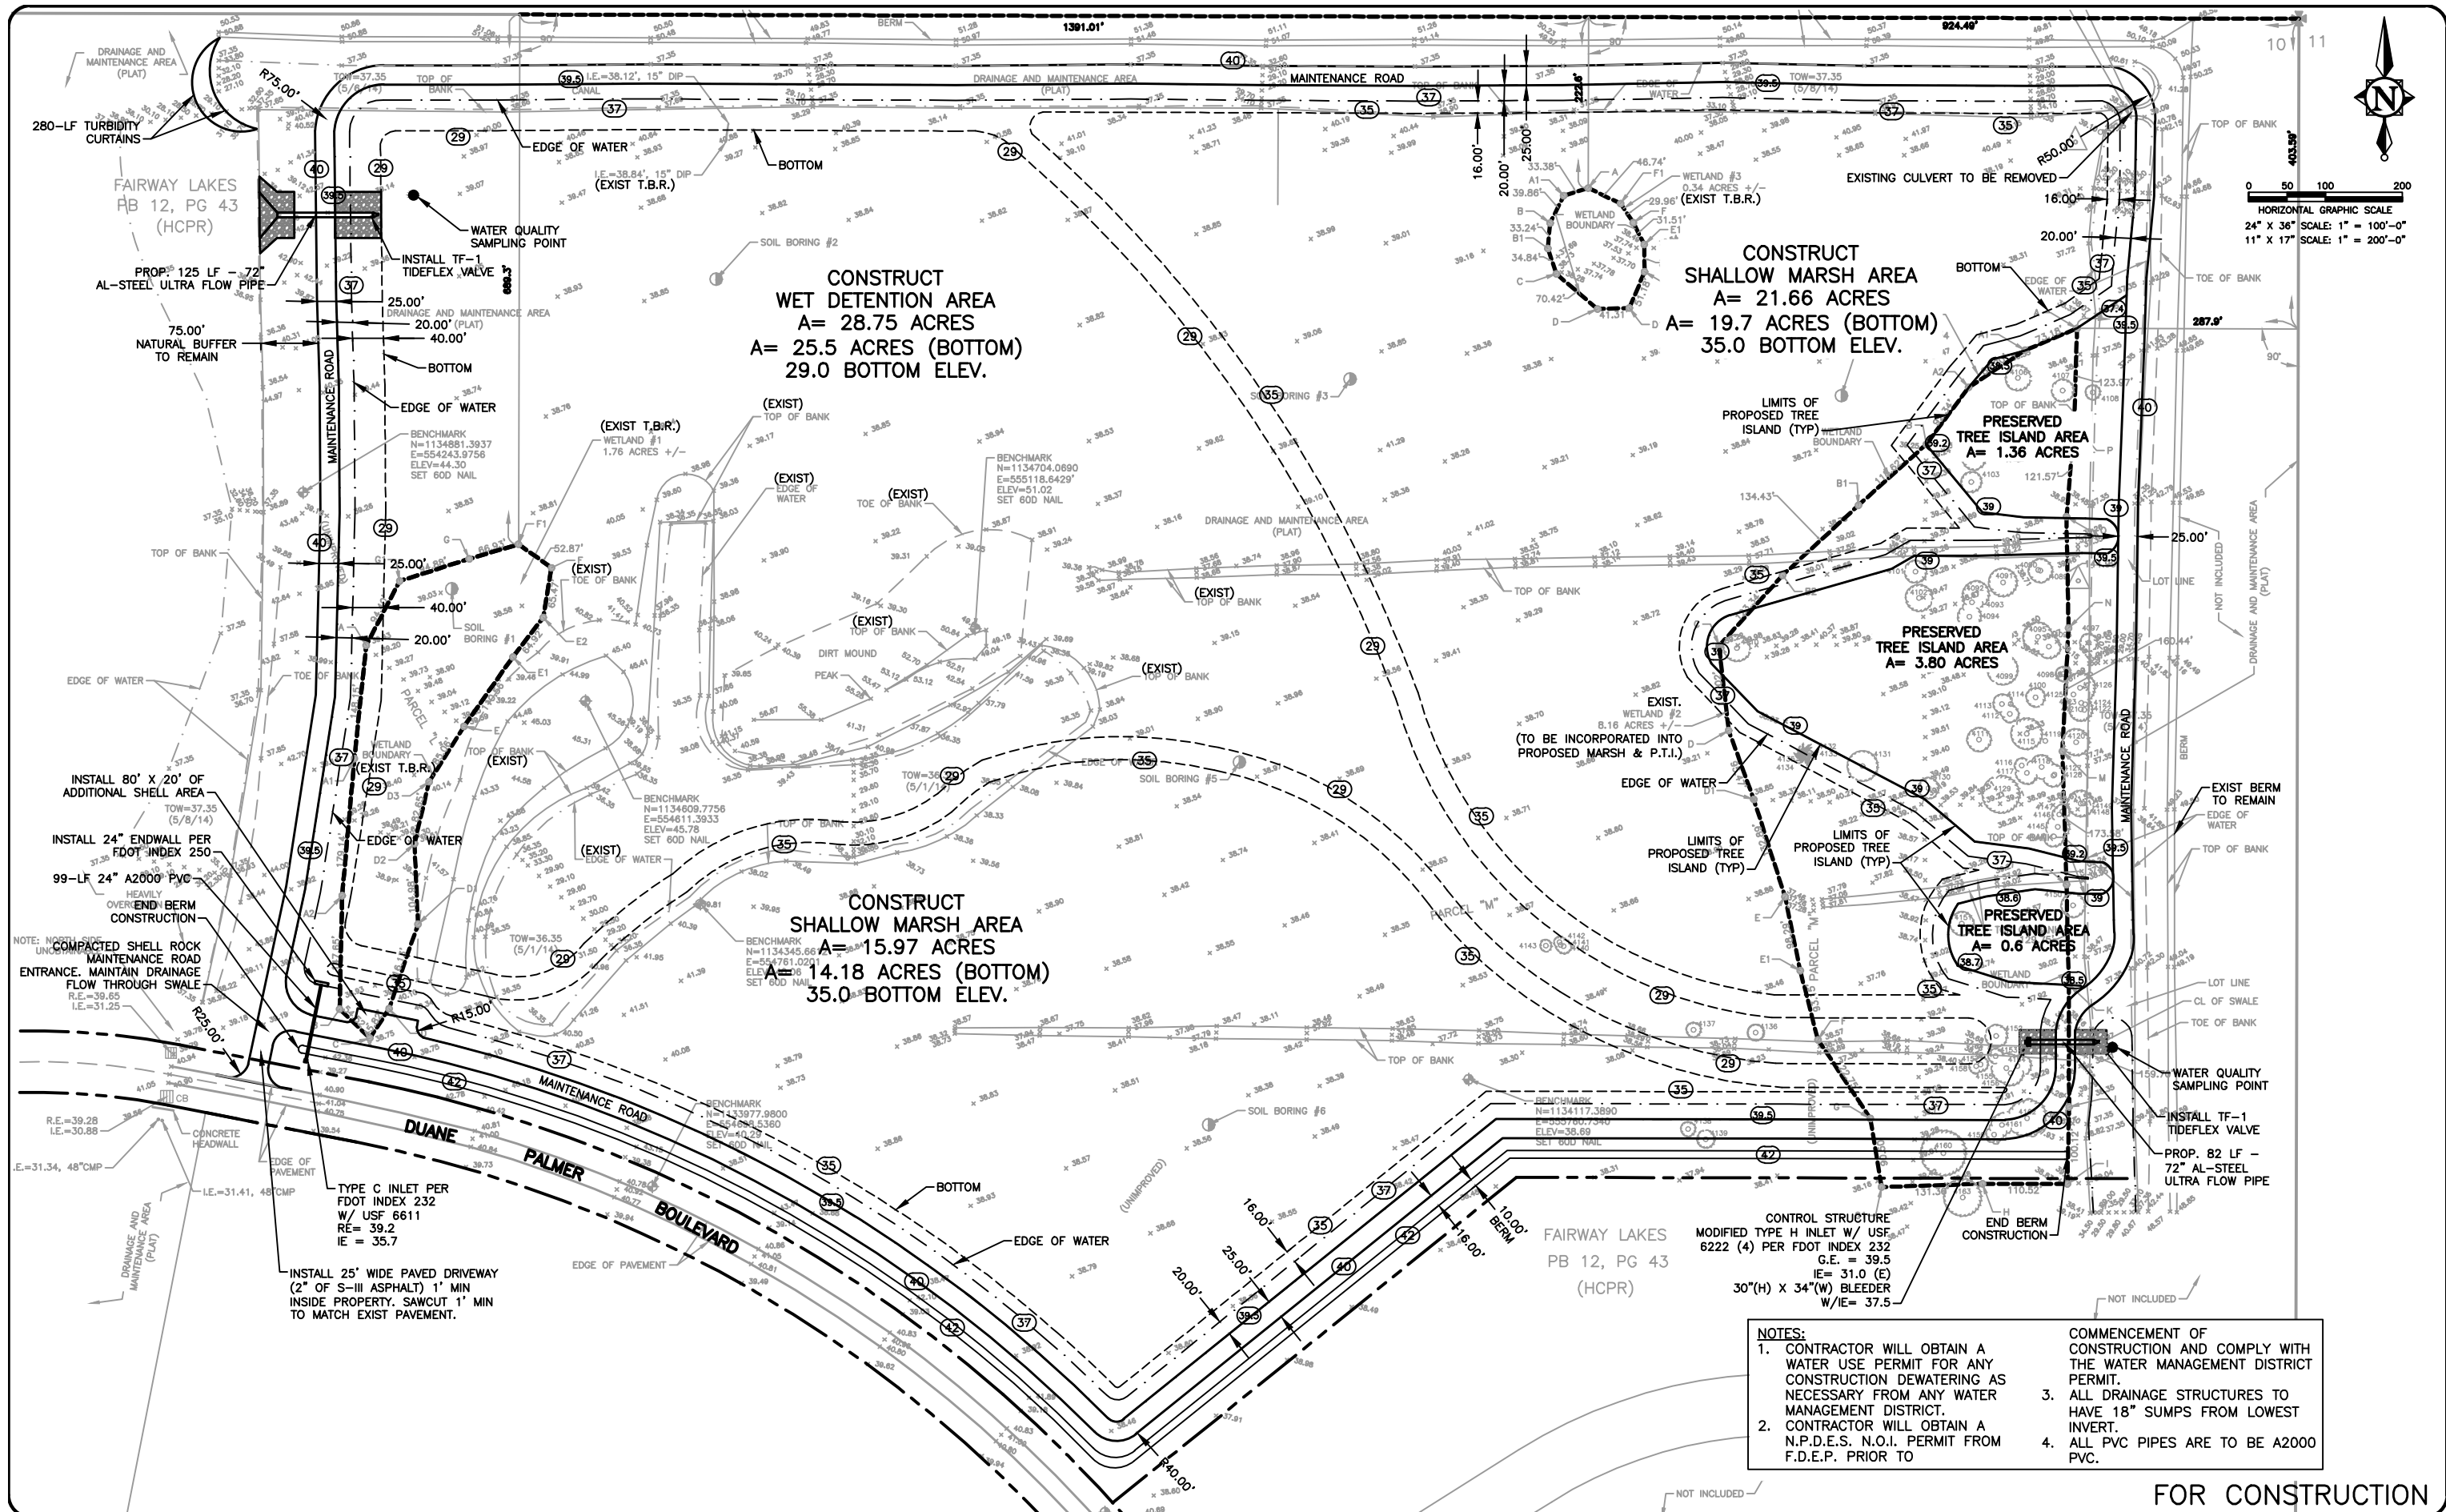

NO.			
DATE			
REVISION			
BY			
N.R.T.S.			

Date:	00/00/00
Designed:	SZ
Drawn:	MM
Checked:	OAR

APPROVED BY:	ORLANDO A. RUBIO, P.E.
DATE	
FLORIDA PROFESSIONAL ENGINEER NO.	48265

CRAIG A. SMITH & ASSOCIATES	
CONSULTING ENGINEERS-PLANNERS-SURVEYORS	
7777 GLADES ROAD, SUITE 410	
BOCA RATON, FLORIDA 33434	
(561) 314-4445	
CERTIFICATE NO. LB0003110	

PREPARED FOR:	SPRING LAKE
IMPROVEMENT DISTRICT	
HIGHLANDS COUNTY, FLORIDA	

PROPOSED	SITE PLAN
STORM WATER TREATMENT AREA	

FILE NAME:	07-1766-C-03-SITE.dwg
LAST SAVED:	11/28/14 - 8:53am
CAS PROJECT NUMBER	14-1766

SHEET	C-03
-------	------