


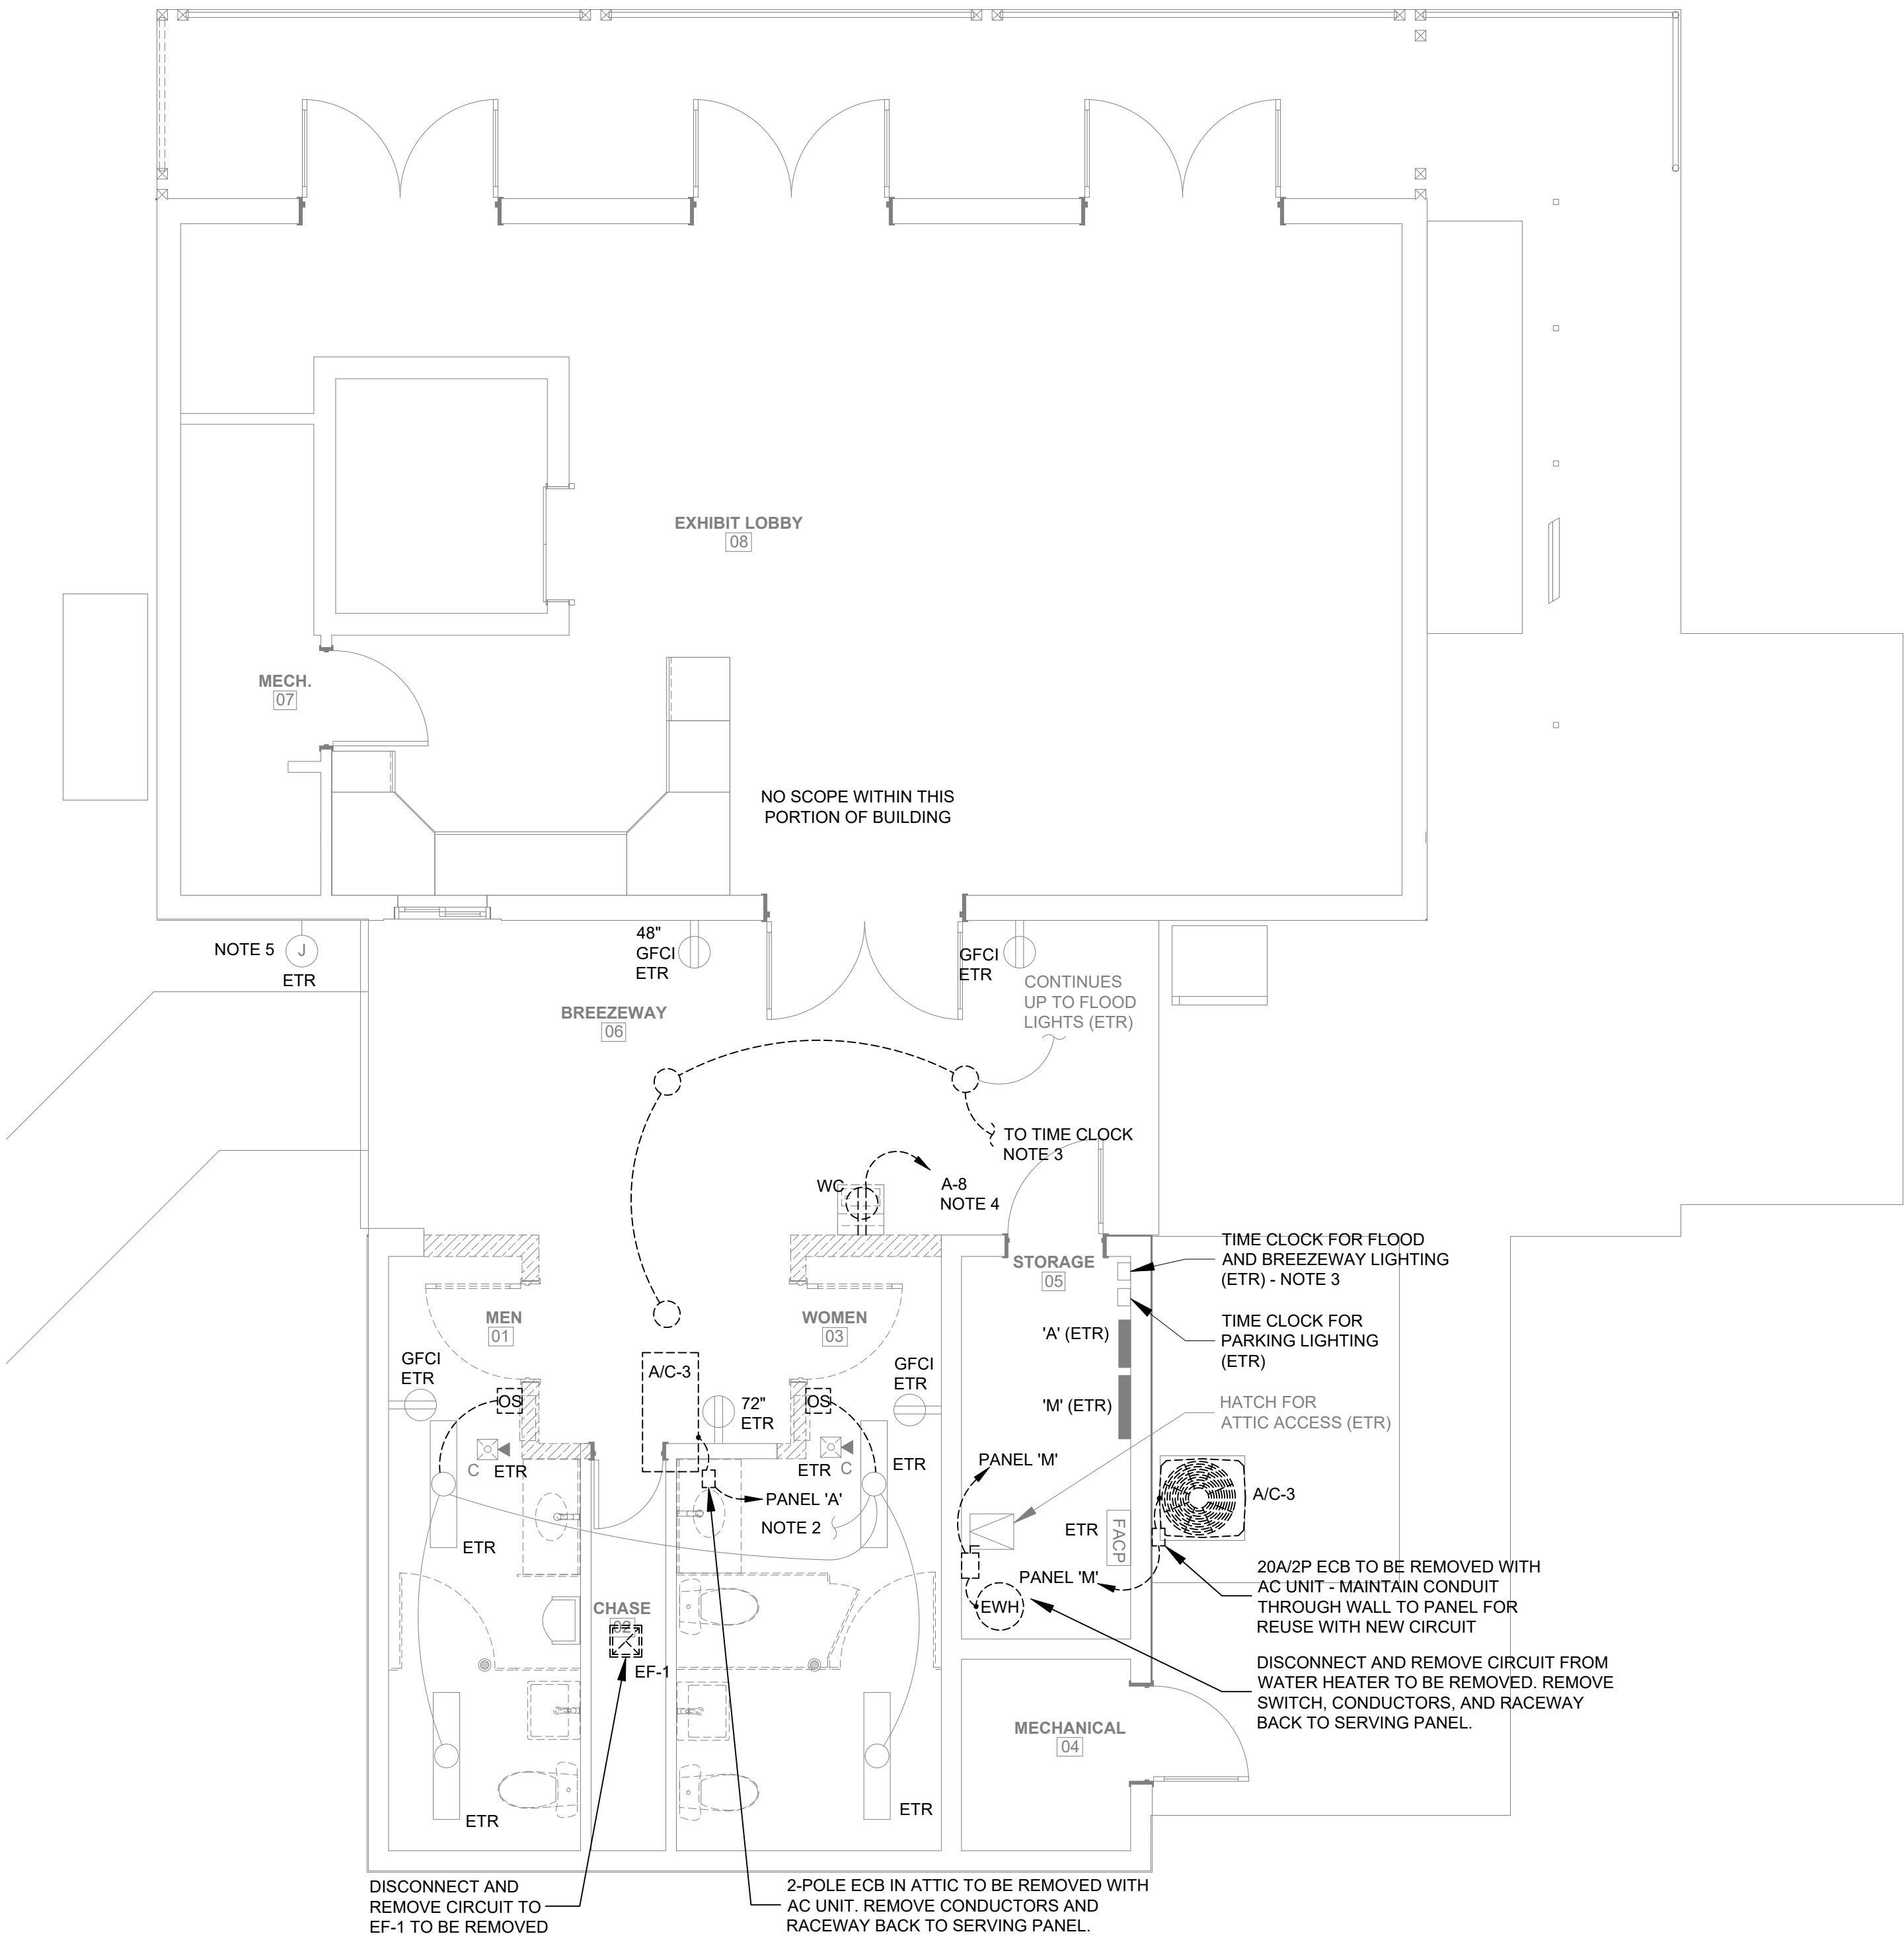


1 ELECTRICAL DEMOLITION PLAN
SCALE: 1/4" = 1'-0"


SHEET NOTES:

1. CIRCUITS SHOWN WERE TAKEN FROM AS-BUILTS. CONTRACTOR SHALL IDENTIFY ALL CIRCUITS PRIOR TO BEGINNING DEMOLITION AS THEY MAY DIFFER IN THE FIELD.
2. DISCONNECT CONTROLS FROM EXISTING LIGHTS AND MAKE PROVISIONS TO RECONNECT NEW CONTROLS TO EXISTING LIGHTS.
3. DISCONNECT AND REMOVE BREEZEWAY LIGHTS FROM CONTROLLED LIGHTING CIRCUIT. REWORK CONTROLLED CIRCUIT ACCORDINGLY TO MAINTAIN CONTROL OF FLOODLIGHTS TO REMAIN.
4. DISCONNECT AND REMOVE WATER COOLER CIRCUIT BACK TO NEAREST JUNCTION BOX TO REMAIN AND MAKE PROVISIONS TO EXTEND EXISTING CIRCUIT TO SERVE NEW WATER COOLER.
5. EXISTING JUNCTION BOX IS USED FOR DATA CABLE ROUTING TO SERVE CUSTOMER COUNTER. BOX, SURFACE RACEWAY, AND CABLING ARE ALL TO REMAIN.

WINDLEY KEY FOSSIL REEF GEOLOGICAL STATE PARK		SHEET NO.			
SHEET TITLE		E101			
ELECTRICAL DEMOLITION PLAN					
PROJECT TITLE		ADA RESTROOM & BOARDWALK			
DESIGNER: BW		ISSUE DATE: 02/25/2025	SYMBOL	REVISION	DATE
DRAWN BY: TB		COMP. FILE No.:			
REVIEWED BY: BW		STATE PROJECT No. 61531C			
Consultant: M McGINNISS + F FLEMING E ENGINEERING 200 BARBER ISLAND DRIVE, SUITE 100, BIRMINGHAM, AL 35202 205-988-1000 FAX 205-988-1001 MFE-NC.COM 800.881.0424					
Department of Environmental Protection Division of Recreation and Parks Bureau of Design and Construction 3800 Commonwealth Blvd., Tallahassee, FL 32399 (850) 245-2300					

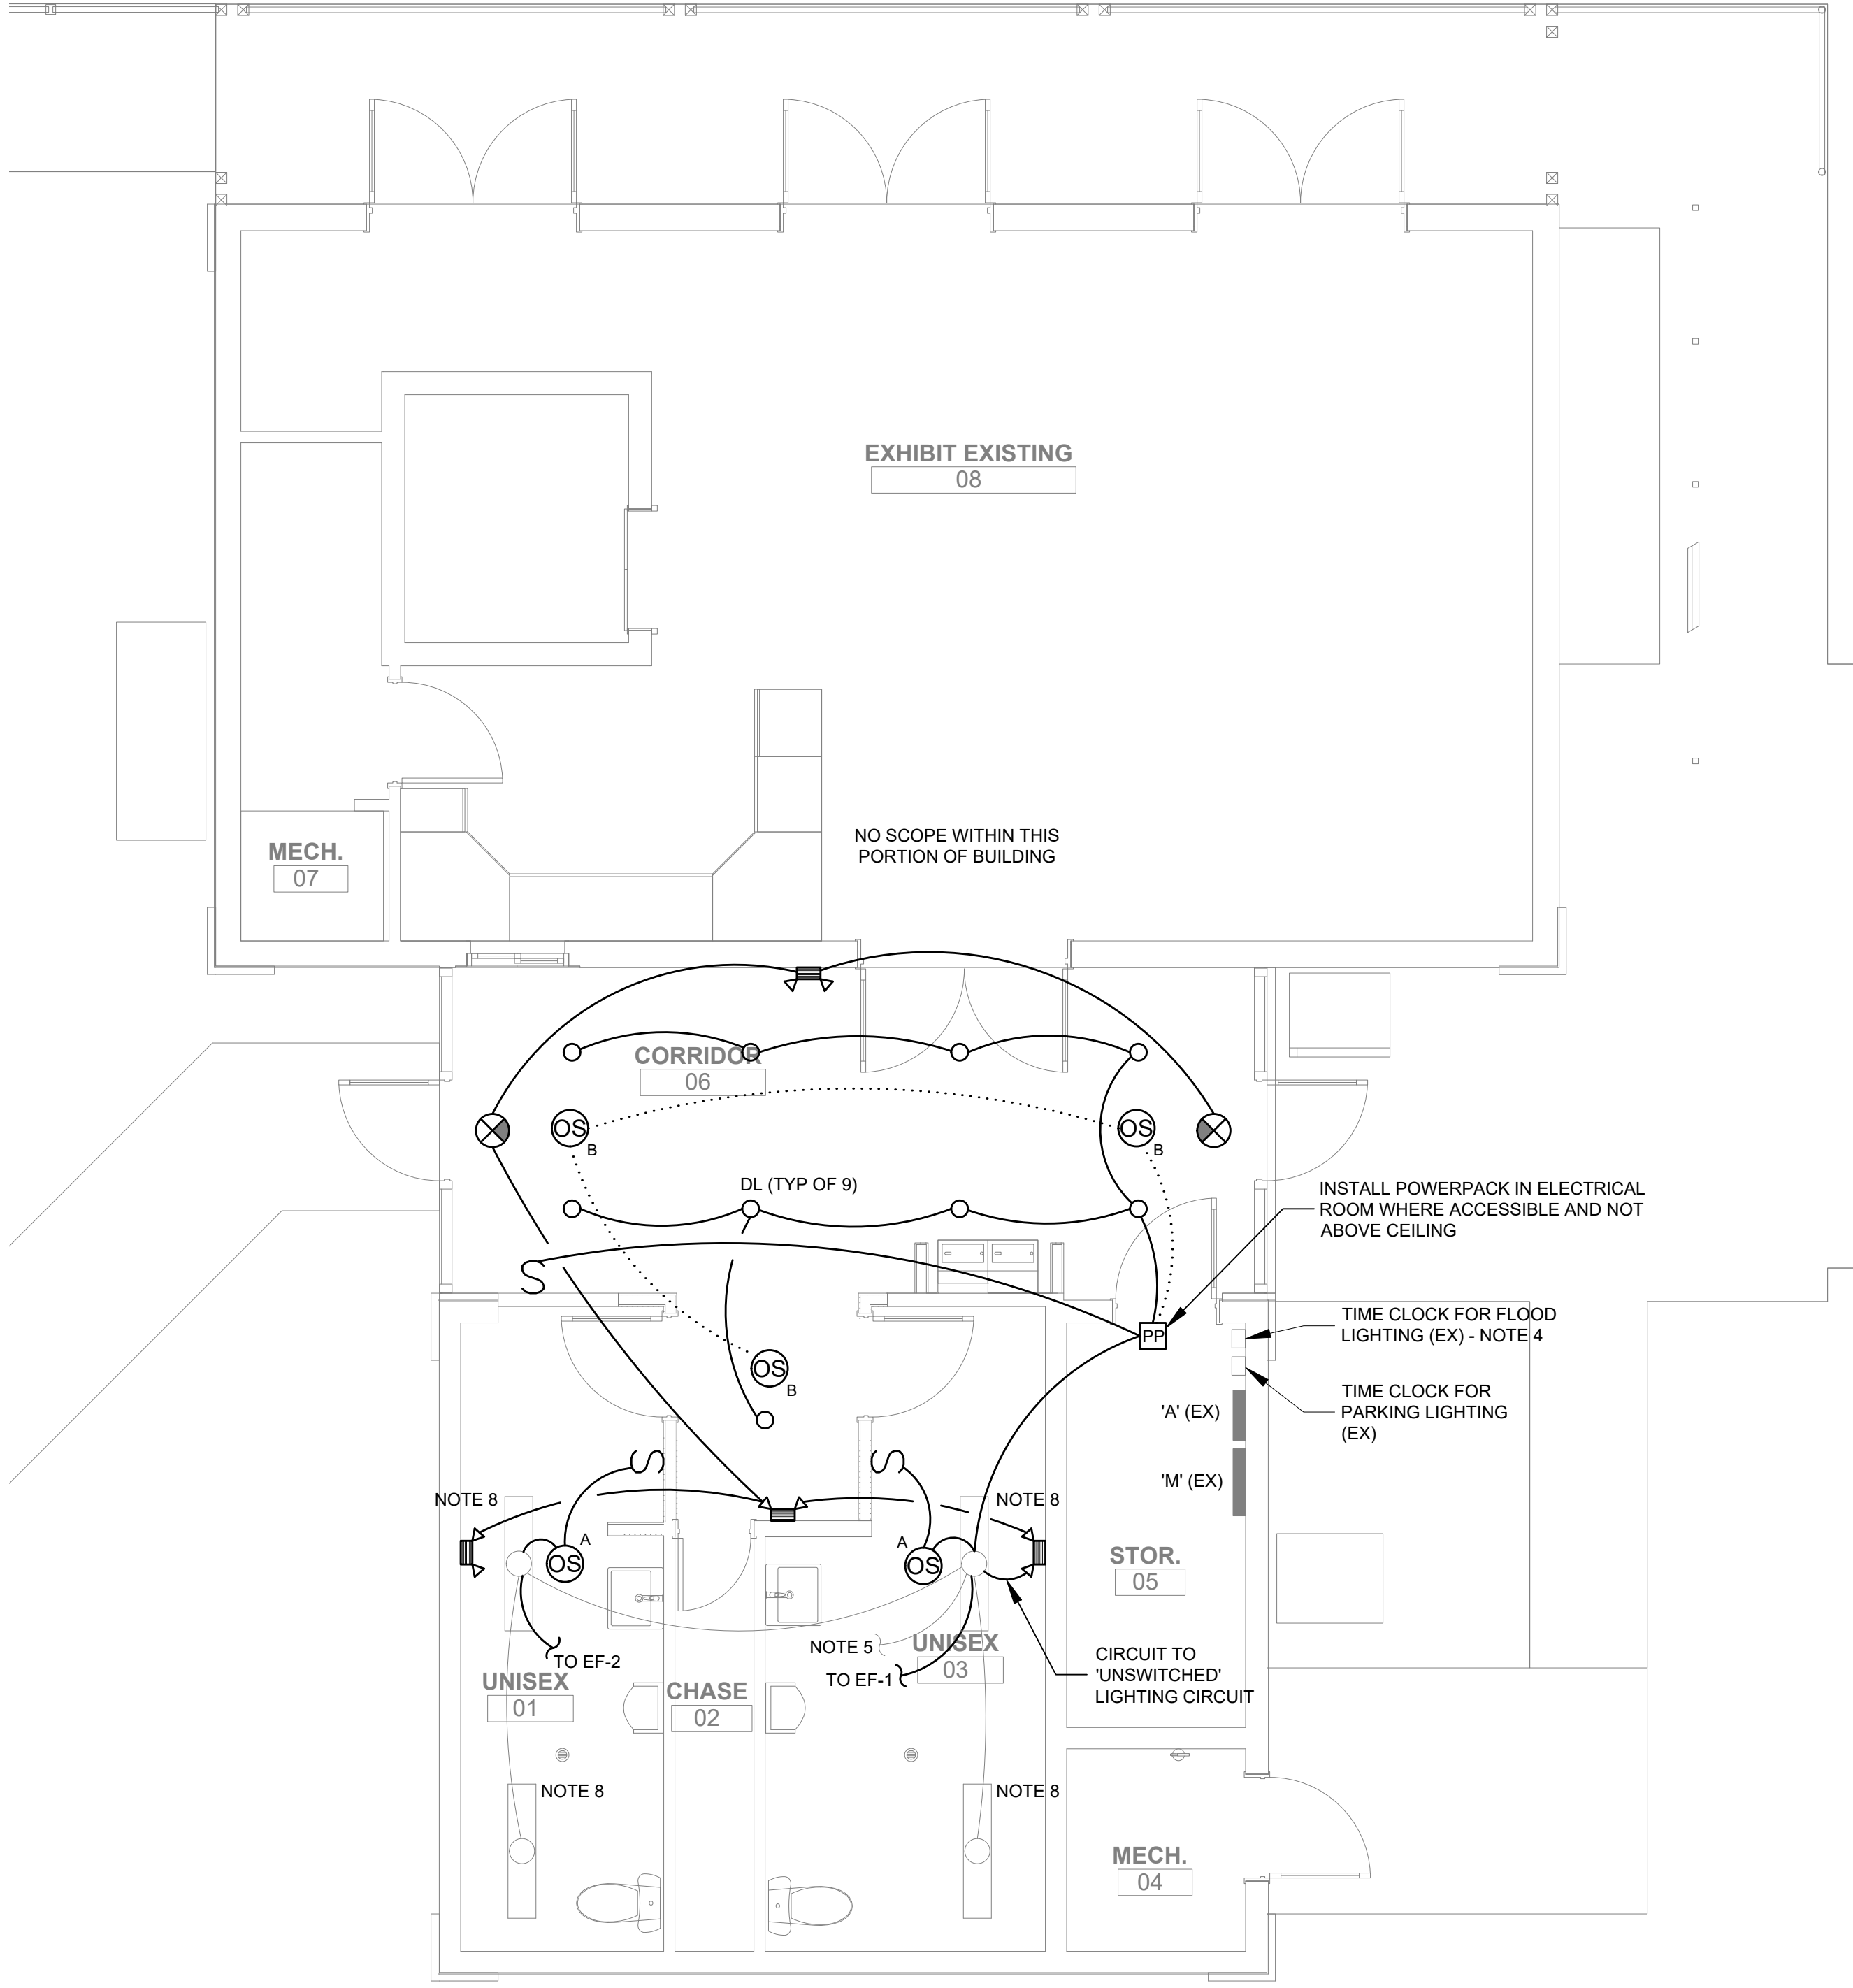


1 NEW WORK LIGHTING PLAN
SCALE: 1/4" = 1'-0"

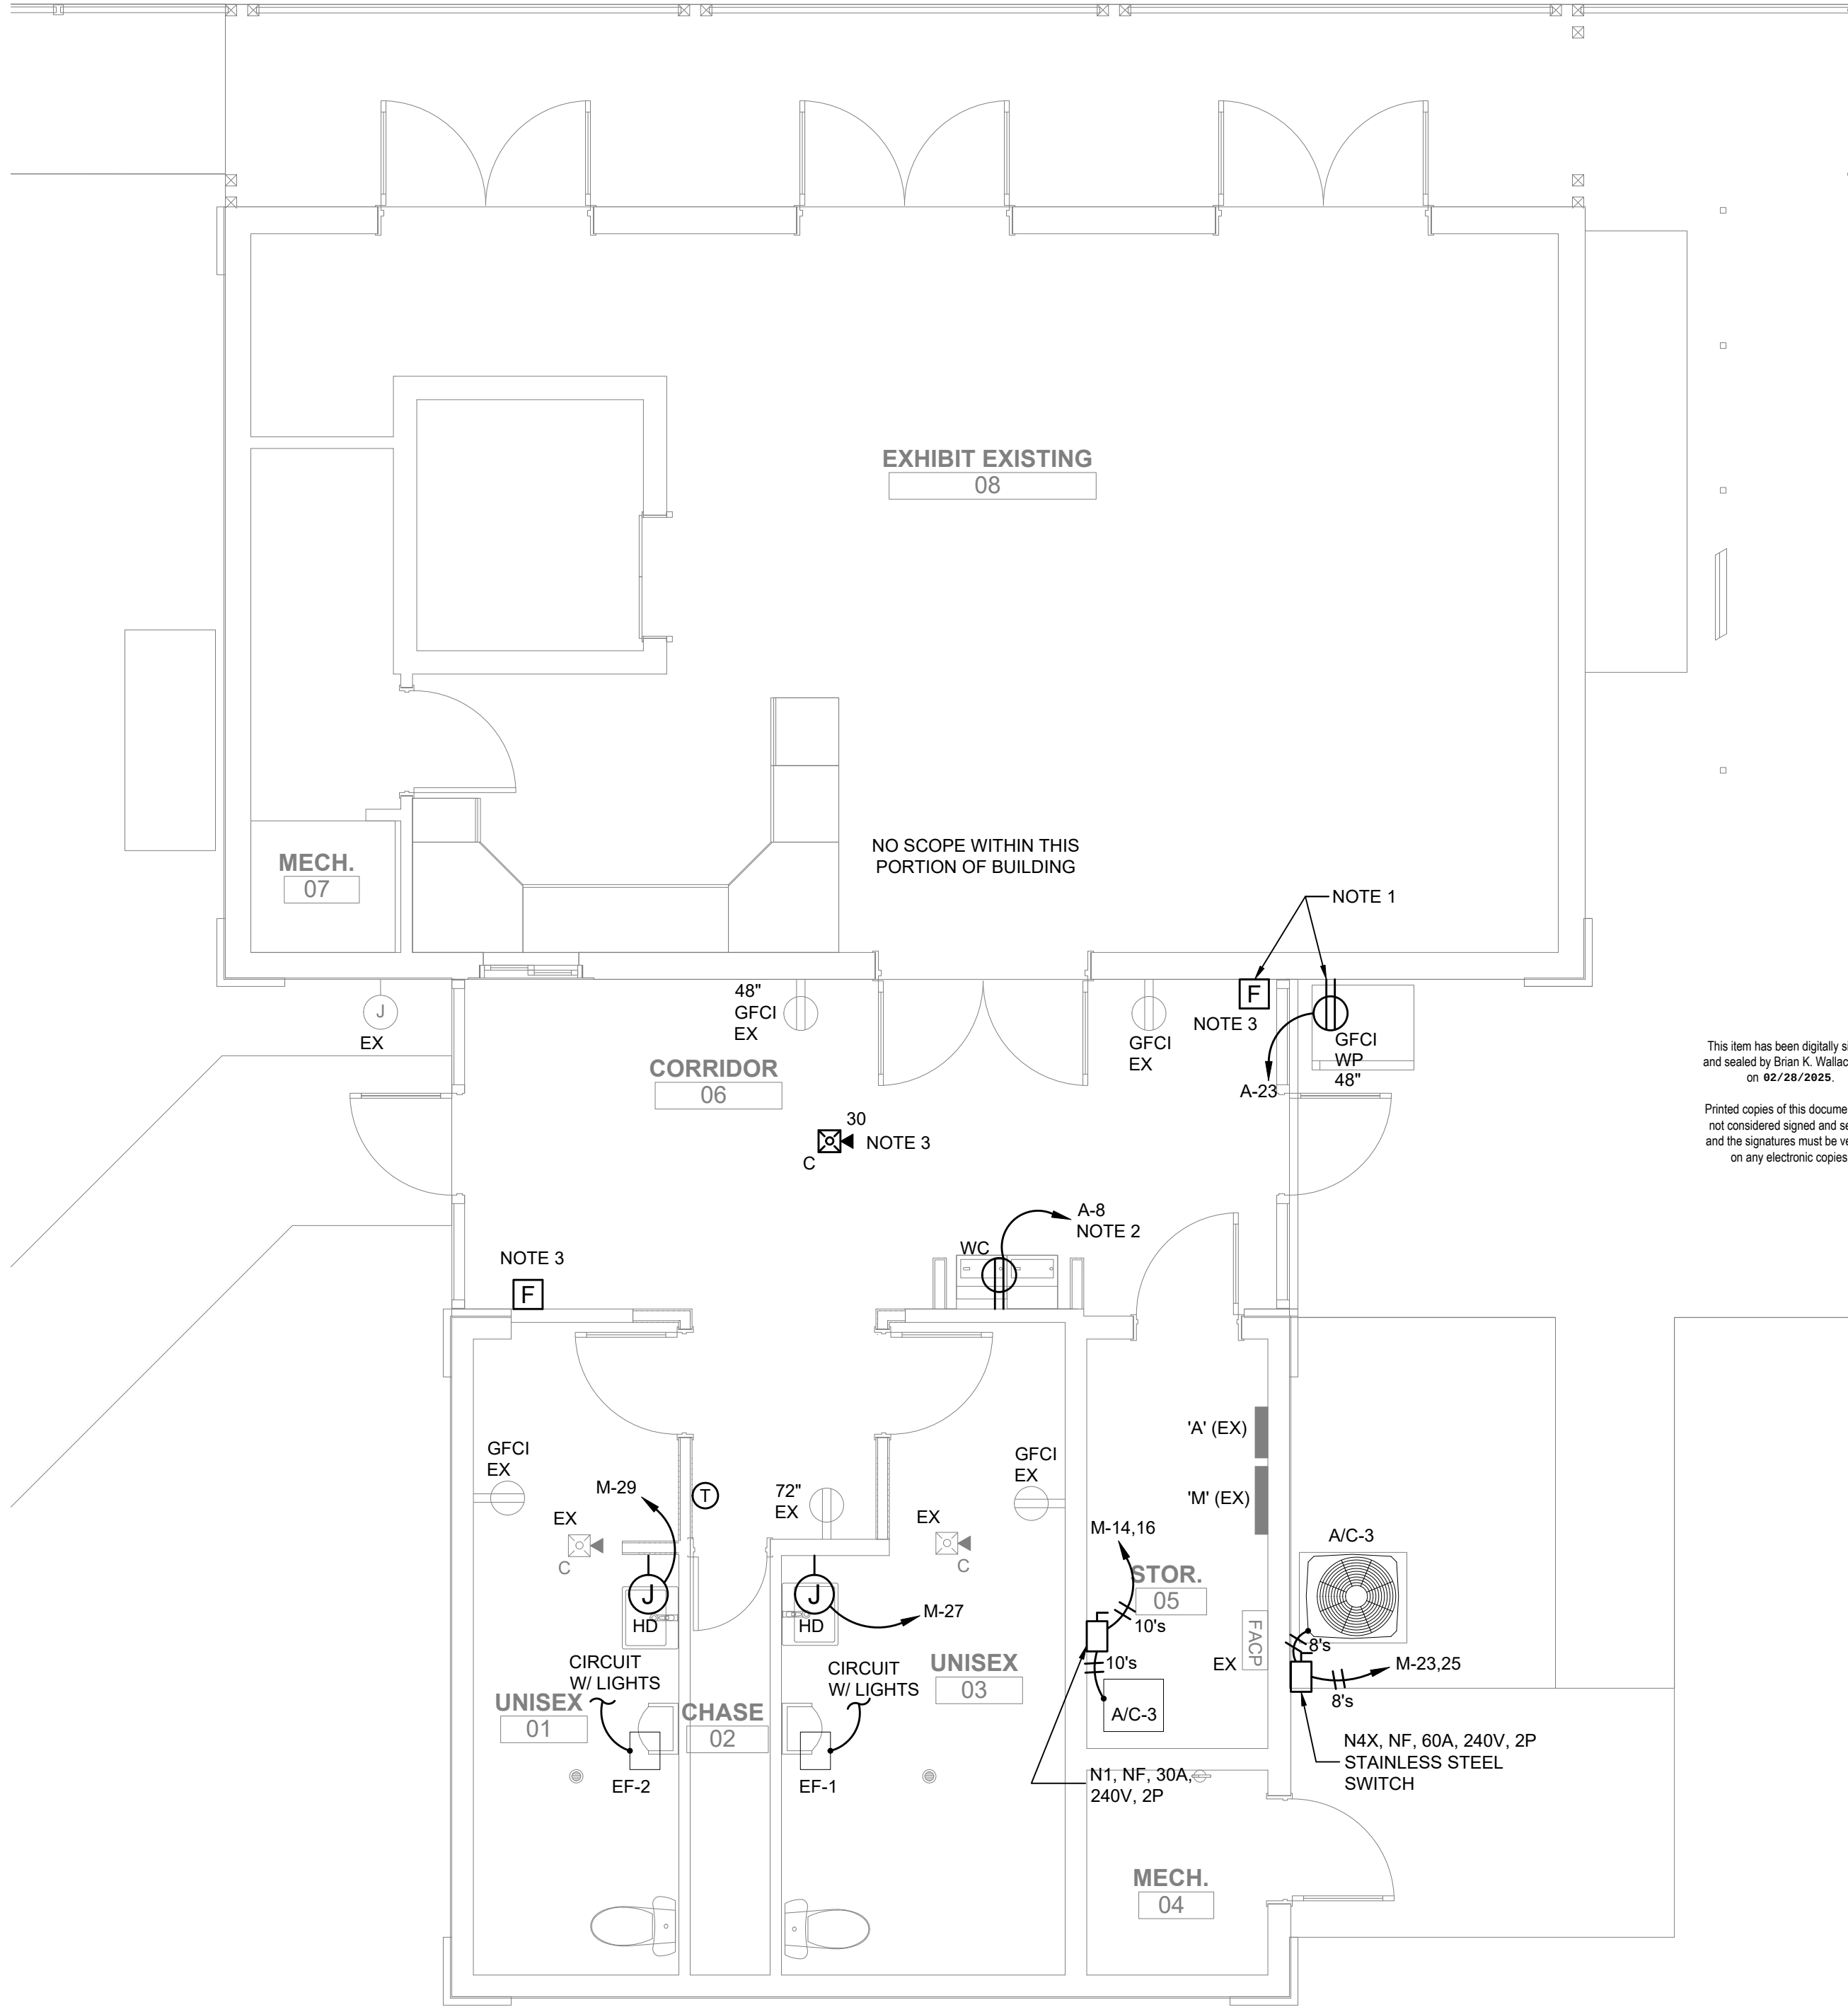

2 NEW WORK POWER/SYSTEMS PLAN
SCALE: 1/4" = 1'-0"

- SHEET NOTES:**
1. PROVIDE SURFACE MOUNTED CONDUIT AND BOX ON CONCRETE WALL FOR DEVICES NOTED.
 2. RECONNECT NEW WATER COOLER RECEPTACLE TO EXISTING CIRCUIT REMAINING FROM DEMOLITION. CONTRACTOR SHALL REPLACE EXISTING 20A, 1P BREAKER WITH GFCI-TYPE, 20A, 1P IN SAME LOCATION.
 3. CONNECT NEW CEILING MOUNTED FIRE ALARM DEVICE TO EXISTING FIRE ALARM SYSTEM NOTIFICATION CIRCUIT AND CONNECT NEW PULL STATIONS TO EXISTING FIRE ALARM SYSTEM INITIATING CIRCUIT. SEE FIRE ALARM ONE LINE AND NOTES.
 4. MAINTAIN CONTROLLED CIRCUIT TO EXISTING FLOOD LIGHTS FROM EXISTING TIME CLOCK.
 5. CONNECT NEW LIGHTING CONTROLS TO EXISTING CIRCUIT AND LIGHTS REMAINING FROM DEMOLITION. FINAL LOAD ON EXISTING 20A, 120V LIGHTING CIRCUIT INCLUDING EXISTING LIGHTS, NEW LIGHTS, AND EXHAUST FANS IS EQUAL TO 3A.
 6. EXHAUST FANS IN EACH RESTROOM SHALL BE CONTROLLED ALONG WITH RESTROOM LIGHTING BY OCCUPANCY SENSORS.
 7. IN SPACES WITH HARD CEILINGS, ALL JUNCTION BOXES AND ELECTRICAL CONNECTIONS SHALL BE LOCATED WHERE ACCESSIBLE. PROVIDE ACCESS PANELS AS REQUIRED. COORDINATE WITH ARCHITECTURAL. JUNCTION BOXES AND ELECTRICAL CONNECTIONS SHALL NOT BE LOCATED WHERE INACCESSIBLE.
 8. EXISTING 4-FOOT, 2-LAMP FLUORESCENT FIXTURES IN RESTROOMS TO HAVE LAMPS AND BALLASTS REMOVED AND NEW LED TUBES PROVIDED. CONTRACTOR TO REWIRE FIXTURE FOR REMOVAL OF BALLAST AND LINE VOLTAGE CONNECTION FOR NEW LED TUBE OPERATION. HOUSING AND LENS TO REMAIN AS EXISTING. NEW LED TUBES SHALL BE 4FT. BALLAST BYPASS DIRECT WIRE (TYPE B), 18W, NON-DIMMING, 120V.

This item has been digitally signed and sealed by Brian K. Wallace, P.E. on 02/28/2025.
Printed copies of this document are not considered signed and sealed and the signatures must be verified on any electronic copies.

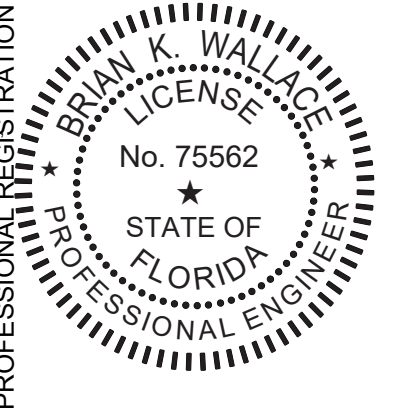

WINDLEY KEY FOSSIL REEF GEOLOGICAL STATE PARK
ELECTRICAL NEW WORK PLAN
ADA RESTROOM & BOARDWALK

SHEET NO. E102

Department of Environmental Protection
Division of Recreation and Parks
Bureau of Design and Construction
3800 Commonwealth Blvd., Tallahassee, FL 32399 (850) 245-2300

DESIGNER: BW
DRAWN BY: TB
REVIEWED BY: BW
CONSULTANT: MCGINNIS + FLEMING ENGINEERING
ISSUE DATE: 02/25/2025
COMP. FILE NO.:
STATE PROJECT NO.: 61531C


100% CONSTRUCTION DOCUMENTS

LIGHTING FIXTURE SCHEDULE					
FIXTURE MARK	MOUNTING	LAMPS			
		NO.	WATTS	TYPE	LUMENS
DL	RECESSED	1	15	MEDIUM BASE 4000K LED	1000
RECESSED DOWNLIGHT FRAME-IN KIT WITH REFLECTOR TRIM. WHITE REFLECTOR. IMPACT EXTRUDED ALUMINUM SOCKET HOUSING WITH MEDIUM BASE SOCKET. THROUGH THE APERTURE SERVICE. GALVANIZED STEEL FRAME. 120V. (GUIDE: LIGHTOLIER LYTECASTER 1102P1 SERIES)					
PROVIDE 75W-EQUIVALENT (15W MAXIMUM) LED MEDIUM BASE BULB FOR NEW LIGHTS.					
ELU (A)	SURFACE	-	2	LED	-
THERMOPLASTIC LED EMERGENCY LIGHTING UNIT. 2-LAMP. NI-CAD BATTERY. 120V. CIRCUIT WITH 'UNSWITCHED' LIGHTING CIRCUIT. (GUIDE: CHLORIDE VLTU SERIES)					
EXIT (X)	SURFACE	-	2	LED	-
THERMOPLASTIC LED EXIT FIXTURE. UNIVERSAL MOUNTING. RED LETTERING. INTEGRAL NI-CAD BATTERY. 120V. CIRCUIT WITH 'UNSWITCHED' LIGHTING CIRCUIT. (GUIDE: CHLORIDE VERWEM SERIES)					

FIXTURE SCHEDULE NOTES	
1.	ALL LIGHTING FIXTURES SHALL CONFORM TO UL 1598. ALL LED FIXTURES SHALL CONFORM TO UL 8750.
2.	EXACT LOCATION OF FIXTURES SHALL BE AS SHOWN ON REFLECTED CEILING PLANS.
3.	ALL RECESSED FIXTURES SHALL BE COMPLETE WITH APPROPRIATE FRAME FOR THE CEILING TYPE IN WHICH IT SHALL BE INSTALLED. A PARTICULAR FIXTURE MARK MAY BE SHOWN IN MORE THAN ONE TYPE CEILING. IT SHALL BE THE CONTRACTOR'S RESPONSIBILITY TO COORDINATE WITH CEILING TYPES.
4.	CLEAN ALL LIGHTING FIXTURES AT THE END OF THE PROJECT. USE SOFT FABRIC AND CLEAR WATER. DO NOT USE CLEANSERS.
5.	CONDUCT FUNCTIONAL TESTING OF LIGHTING CONTROLS. CONFIRM THAT OCCUPANCY SENSOR PLACEMENT, SENSITIVITY AND TIME-OUT ADJUSTMENTS YIELD EXPECTED PERFORMANCE. CONFIRM SENSORS ACTUALLY TURN LIGHTS OFF.
6.	CONDUCT FUNCTIONAL TESTING OF EMERGENCY LIGHTS BY REMOVING NORMAL POWER AND VERIFYING LIGHTS TURN ON AUTOMATICALLY.


WIRING SCHEDULE FOR VOLTAGE DROP	
DISTANCE	CONDUCTOR SIZE
120V - 20A BRANCH CIRCUIT	
UP TO 100'	#12
100' - 150'	#10
150' - 250'	#8
250' - OVER	#6
277V - 20A BRANCH CIRCUIT	
UP TO 200'	#12
200' - 375'	#10
375' - OVER	#8
NOTE: FOR CIRCUITS WITH #8 CONDUCTORS, REDUCE TO #8 CONDUCTORS AT PANEL FOR FINAL CONNECTIONS TO CIRCUIT BREAKER.	

FIRE ALARM NOTES AND PARTIAL ONE LINE	
1.	MODIFY THE EXISTING PROTECTIVE SIGNALING SYSTEM SUITABLE FOR TYPE OCCUPANCY AS DEFINED BY LOCAL BUILDING CODE AND AS APPROVED BY STATE FIRE MARSHALL. THE SYSTEM SHALL CONSIST OF, BUT NOT BE LIMITED TO, ALARM SOUNDING DEVICES, FLASHING STROBE LIGHTS, INITIATING DEVICES, AND APPURTENANCES.
2.	EXISTING FIRE ALARM SYSTEM IN REMAINING PORTIONS OF BUILDING SHALL REMAIN OPERATIONAL DURING CONSTRUCTION.
3.	PROVIDE THE REQUIRED WIRING IN ACCORDANCE WITH MANUFACTURER'S REQUIREMENTS. PROVIDE INSTALLATION DRAWINGS PREPARED BY THE EQUIPMENT MANUFACTURER FOR REVIEW. INSTALLATION SHALL BE SUPERVISED BY A DULY LICENSED CERTIFIED CONTRACTOR AND INSTALLED BY PERSONNEL SKILLED IN THE TRADE.
4.	WIRING SHALL CONFORM TO NFPA 72 AND NFPA 90A AS APPLICABLE AND ARTICLE 760 OF THE NEC. WIRING SHALL BE IN ACCORDANCE WITH THE MANUFACTURER'S REQUIREMENTS AS NECESSARY TO PERFORM THE REQUIRED FUNCTION.
5.	ALL WIRING SHALL BE IN CONDUIT. SEE GENERAL NOTES FOR ADDITIONAL CONDUIT ROUTING REQUIREMENTS. MINIMUM CONDUIT SIZE SHALL BE 3/4".
6.	IN JUNCTION BOXES, TERMINAL CABINETS, CONTROL PANEL, OUTLET BOXES, DEVICES, ETC., WIRING SHALL TERMINATE ON IDENTIFIED TERMINAL STRIPS. WIRE NUTS OR OTHER SIMILAR SPICING DEVICES SHALL NOT BE ACCEPTABLE IN ANY PART OF THE SYSTEM.
7.	EACH NEW JUNCTION BOX WILL BE PAINTED RED WITH "FIRE" STENCILED IN WHITE LETTERS ON THE COVER.
8.	THE COMPLETED SYSTEM SHALL BE INSPECTED AND TESTED IN THE PRESENCE OF THE LOCAL AHJ.
9.	THE COMPLETED SYSTEM SHALL BE FULLY TESTED AND CERTIFIED PRIOR TO THE COMPLETION OF THE PROJECT. PROVIDE TEST RESULTS AND CERTIFY COMPLETE SYSTEM AT THE COMPLETION OF THE PROJECT.
10.	THE FIRE ALARM SYSTEM CONTRACTOR SHALL SUBMIT A SEPARATE PERMIT APPLICATION AND PLANS FOR REVIEW IN ACCORDANCE WITH NFPA 1 AND FBC. SHOP DRAWING SHALL BE SUBMITTED TO STATE FIRE MARSHAL FOR REVIEW. A FLORIDA LICENSED FIRE ALARM CONTRACTOR SHALL PROVIDE TWO COPIES OF FIRE ALARM SYSTEM SHOP DRAWINGS CONTAINING: 1) CONTRACTOR'S NAME AND LICENSE NUMBER, 2) MANUFACTURER'S TECHNICAL CUT SHEETS WITH SYSTEM COMPONENTS AND DEVICES IDENTIFIED, 3) STANDARD POWER AND BATTERY CALCULATIONS FOR ALL PANELS SHOWING STANDBY POWER VALUES AND TIME TO MEET EITHER 24 OR 60 HOURS STANDBY TIME, 4) SCALED PLANS SHOWING LOCATION OF ALL PANELS, DEVICES (WITH DEVICE SPECIFIC INFORMATION), WIRE RUNS, NUMBER OF CONDUCTORS, END-OF-LINE RESISTORS, SURGE PROTECTION DEVICES, AND TYPICAL WIRING METHODS USED ON THE DEVICES, 5) FIRE ALARM RISER DIAGRAM SHOWING ALL COMPONENTS, 6) WIRING NOTES OR SCHEDULE, AND 7) SEQUENCE OF OPERATION TO INCLUDE METHOD OF SUPERVISORY COMMUNICATION. SHOP DRAWINGS SHALL BE APPROVED BEFORE INSTALLATION OF SYSTEM.
11.	IF SYSTEM SHUTDOWN IS REQUIRED, IT SHALL BE LESS THAN 4 HOURS IN ANY GIVEN 24 HOUR PERIOD. IF THIS IS IMPOSSIBLE, THE LOCAL FIRE DEPARTMENT SHALL BE NOTIFIED AND AN APPROVED FIRE WATCH INITIATED IN ACCORDANCE WITH NFPA 101. PROVISIONS FOR FIRE WATCH SHALL BE PROVIDED AND CARRIED OUT BY CONTRACTOR.
12.	INITIATING CIRCUITS SHALL BE WIRED FOR 2-WIRE CLASS B SERVICE.
13.	THE EXISTING FIRE ALARM CONTROL PANEL IS FIRE-LITE MS-4 AND IS TESTED AND MAINTAINED BY PYE+BARKER FIRE AND SAFETY. SECURE THE SERVICES OF A LICENSED FIRE ALARM CONTRACTOR TO COMPLETE FIRE ALARM SCOPE OF WORK.

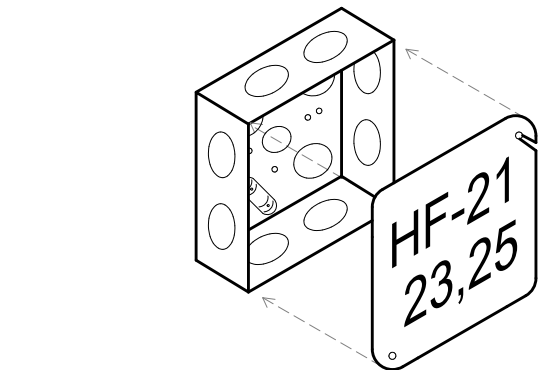


EACH JUNCTION BOX COVER SHALL BE LABELED WITH A PERMANENT "MAGIC" MARKER OR OTHER PERMANENT MEANS TO IDENTIFY THE CIRCUITS OR SYSTEMS CABLES WITHIN. INCLUDE THE PANEL AND CIRCUIT BREAKER NUMBER FOR ALL POWER CIRCUITS WITHIN. FOR EXAMPLE, A JUNCTION BOX CONTAINING LIGHTING CIRCUITS 21, 23, 25 FROM PANEL "HF" WOULD BE LABELED "HF-21,23,25" AS SHOWN.


JUNCTION BOX IDENTIFICATION
NO SCALE

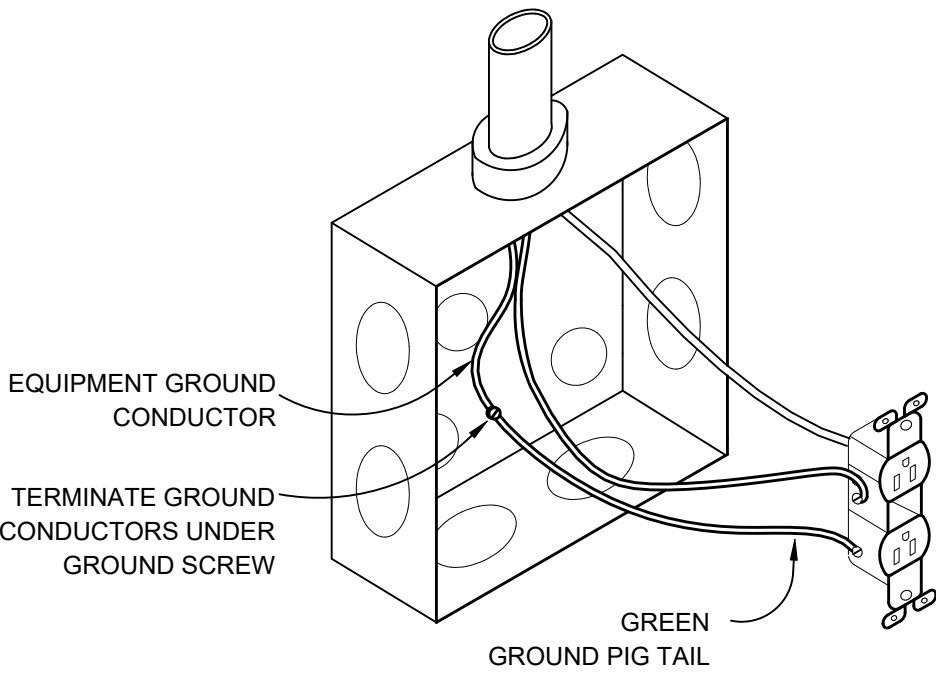



RECEPTACLE WIRING DETAIL
NO SCALE

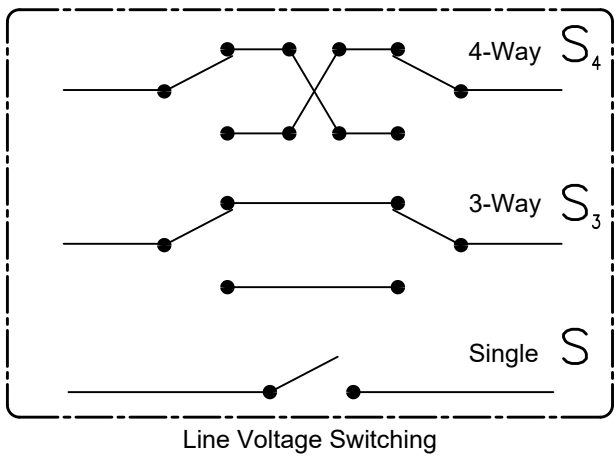

BASIS OF DESIGN IS PRODUCTS BY WATTSTOPPER. EQUIVALENT CONTROL COMPONENTS AND METHODS ARE ACCEPTABLE WHEN APPROVED IN ACCORDANCE WITH GENERAL REQUIREMENTS.

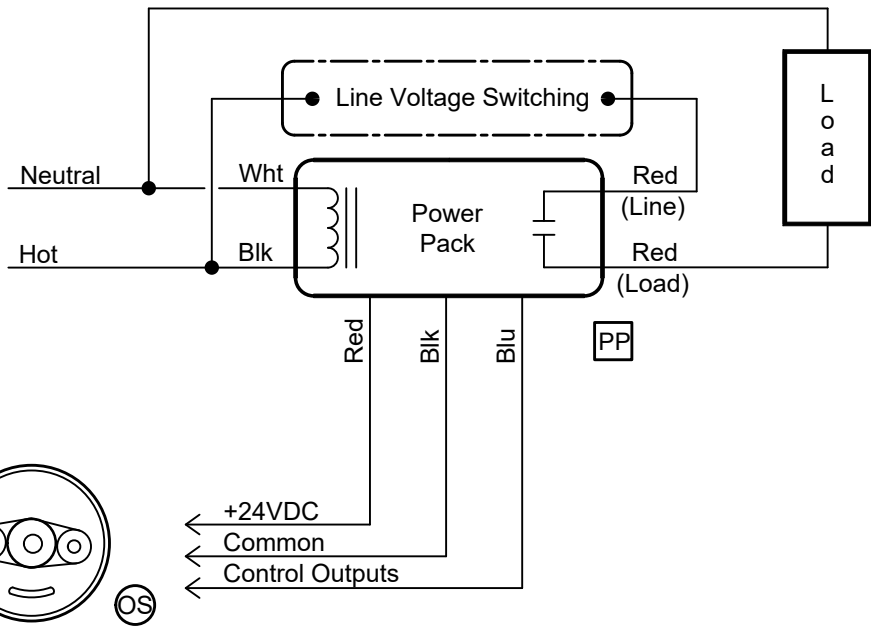


LV OCCUPANCY SENSOR LIGHTING CONTROL
NO SCALE

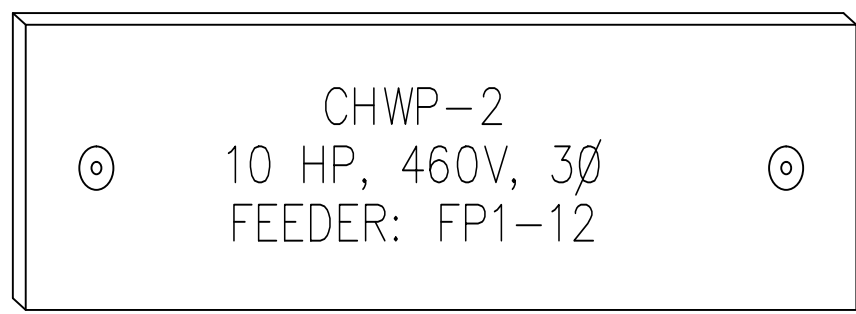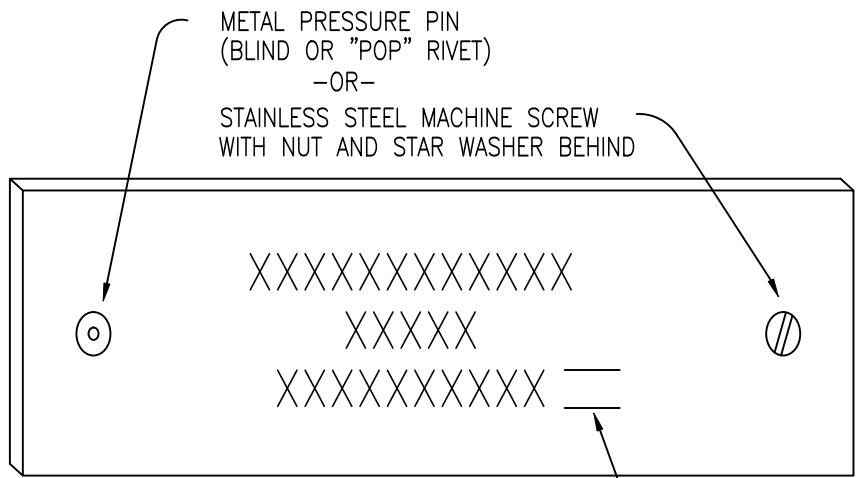


MDP-4
HWP-6
5 HP, 208V, 3Ø

NAMEPLATE DETAILS
NO SCALE

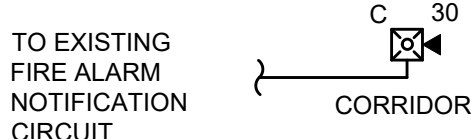

NOTE: EXISTING NOTIFICATION APPLIANCES THAT ARE REUSED IN NEW WORK PLAN ARE NOT SHOWN IN ONE LINE.

This item has been digitally signed and sealed by Brian K. Wallace, PE on 02/28/2025.
Printed copies of this document are not considered signed and sealed and the signatures must be verified on any electronic copies.

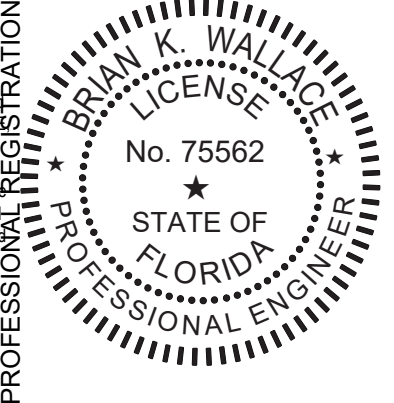

WINDLEY KEY FOSSIL REEF GEOLOGICAL STATE PARK	
SHEET TITLE	ELECTRICAL DETAILS
PROJECT TITLE	ADA RESTROOM & BOARDWALK

SHEET NO.
E501

DATE	REVISION	SYMBOL	DATE	REVISION	SYMBOL

Department of Environmental Protection
Division of Recreation and Parks
Bureau of Design and Construction
3800 Commonwealth Blvd., Tallahassee, FL 32399 (850) 245-2300

DESIGNER: BW	ISSUE DATE: 02/25/2025	COMP. FILE NO:	STATE PROJECT No.: 61531C
DRAWN BY: TB			
REVIEWED BY: BW			



PANEL SCHEDULES - EXISTING CONDITIONS

LOAD / REMARKS	CIR. NO.	BREAKERS		H.P. OR K.W.	AMPS PER PHASE									H.P. OR K.W.	BREAKERS		CIR. NO.	LOAD / REMARKS	PANELBOARD SCHEDULE			
		AMPS	POLES		LIGHTING			GEN. RECEPTS			SPECIAL				AMPS	POLES						
					ØA	ØB	ØC	ØA	ØB	ØC	ØA	ØB	ØC									
SURGE PROTECTOR (SPD)	1	30	3	-	-	-	-	-	-	-	-	-	-	40	2	2	AC INDOOR - 1st FLOOR	Windley Key State Park Windley Key, Florida	Panel 'M'			
	3				-	-	-	-	-	-	-	-	-			4	PANEL 'A'					
	5				-	-	-	-	-	-	-	-	-	100	2	6						
AC INDOOR - 2nd FLOOR	7	40	2	-	-	-	-	-	-	-	-	-	-			8	WATER HEATER	Fed From SERVICE DISC.				
	9				-	-	-	-	-	-	-	-	-			10						
WATER HEATER - 1st FLOOR	11	20	2	-	-	-	-	-	-	-	-	-	-	25	2	10	AC OUTDOOR - RR	Service 3 Phase 4 Wire ■ 240Y/120V, HIGH LEG □ 480Y/277V				
	13				-	-	-	-	-	-	-	-	-	20	2	14						
AC OUTDOOR - 1st FLOOR	15	20	2	-	-	-	-	-	-	-	-	-	-			16	DOSING PUMPS					
	17				-	-	-	-	-	-	-	-	-	20	2	18						
AC OUTDOOR - 2nd FLOOR	19	30	2	-	-	-	-	-	-	-	-	-	-			20	ELEV.					
	21				-	-	-	-	-	-	-	-	-			22						
SPACE	23				-	-	-	-	-	-	-	-	-	100	3	22	SPACE					
SPACE	25				-	-	-	-	-	-	-	-	-			24						
SPACE	27				-	-	-	-	-	-	-	-	-			26	SPACE					
SPACE	29				-	-	-	-	-	-	-	-	-			28						
SPACE	31				-	-	-	-	-	-	-	-	-			30	SPACE					
SPACE	33				-	-	-	-	-	-	-	-	-			32						
SPACE	35				-	-	-	-	-	-	-	-	-			34	SPACE					
SPACE	37				-	-	-	-	-	-	-	-	-			36						
SPACE	39				-	-	-	-	-	-	-	-	-			38	SPACE					
SPACE	41				-	-	-	-	-	-	-	-	-			40						
					-	-	-	-	-	-	-	-	-			42	SPACE					
TOTAL CONNECTED LOAD (AMPS)					-	-	-	-	-	-	-	-	-	TOTAL CONNECTED LOAD (AMPS)								

PANELBOARD SCHEDULE

Windley Key State Park
Windley Key, Florida

Panel **'M'**

Location **ELECTRICAL ROOM**

Fed From **SERVICE DISC.**

Service **3** Phase **4** Wire
■ 240Y/120V, HIGH LEG
□ 480Y/277V

Main Bkr. **300 A** **3 P**
Lugs Only **- A**

10,000 AIC
60 Hz
■ Surface mounted panel

Remarks
PANEL IS EXISTING TO REMAIN.

LOADS SHOWN WERE TAKEN FROM AS-BUILTS AND NOTES IN THE FIELD. CONTRACTOR SHALL VERIFY ALL CIRCUITS PRIOR TO MAKING CHANGES.

LOAD / REMARKS	CIR. NO.	BREAKERS		H.P. OR K.W.	AMPS PER PHASE												H.P. OR K.W.	BREAKERS		CIR. NO.	LOAD / REMARKS
		AMPS	POLES		LIGHTING			GEN. RECEPTS			SPECIAL			AMPS	POLES						
					ØA	ØB	ØC	ØA	ØB	ØC	ØA	ØB	ØC								
1st FLOOR LIGHTING	1	20	1	-	-	-	-	-	-	-	-	-	-	-	20	1	2	REC - NORTH WALL, 1st FL			
STAIRWAY LIGHTING	3	20	1	-	-	-	-	-	-	-	-	-	-	-	20	1	4	REC - SOUTH WALL, 1st FL			
2nd FLOOR LIGHTING	5	20	1	-	-	-	-	-	-	-	-	-	-	-	20	1	6	REC - RR, STORAGE			
RRS, ELEC. MECH. LIGHTING	7	20	1	-	-	-	-	-	-	-	-	-	-	-	20	1	8	WATER COOLER			
BREEZE WAY LIGHTING	9	20	1	-	-	-	-	-	-	-	-	-	-	-	20	1	10	REC - NORTH WALL, 2nd FL			
PARKING LOT LIGHTS	11	20	1	-	-	-	-	-	-	-	-	-	-	-	20	1	12	REC - SOUTH WALL, 2nd FL			
PARKING LOT LIGHTS	13	20	1	-	-	-	-	-	-	-	-	-	-	-	20	1	14	REC - ELEVATOR WELL			
REC - ELEVATOR RM	15	20	1	-	-	-	-	-	-	-	-	-	-	-	50	2	16	KITCHEN STOVE / OVEN			
ELEVATOR EQUIP. CONTROLS	17	20	1	-	-	-	-	-	-	-	-	-	-	-	20	1	18	REC - REFRIGERATOR			
SHED IN PARKING LOT	19	20	1	-	-	-	-	-	-	-	-	-	-	-	20	1	20	REC - KITCHEN GFCI			
FIRE PANEL	21	20	1	-	-	-	-	-	-	-	-	-	-	-	20	1	22	EXISTING LOAD			
AC INDOOR - RR	23	40	2	-	-	-	-	-	-	-	-	-	-	-	20	2	24				
	25				-	-	-	-	-	-	-	-	-	-	20	2	26				
OUTSIDE WHEELCHAIR	27	20	1	-	-	-	-	-	-	-	-	-	-	-	60	2	28	SEWER PUMP			
REC - COMM.	29	20	1	-	-	-	-	-	-	-	-	-	-	-			30				
TOTAL CONNECTED LOAD (AMPS)					-	-	-	-	-	-	-	-	-	TOTAL CONNECTED LOAD (AMPS)							

PANELBOARD SCHEDULE

Windley Key State Park
Windley Key, Florida

Panel

'A'

Location

ELECTRICAL ROOM

Fed From

PANEL 'M'

Service

1 Phase 3 Wire

■ 240Y/120V

□ 480Y/277V

Main Bkr.

100 A 3 P

Lugs Only

- A

10,000 AIC

60 Hz.

■ Surface mounted panel

Remarks

PANEL IS EXISTING TO REMAIN.

LOADS SHOWN WERE TAKEN FROM AS-BUILTS AND NOTES IN THE FIELD. CONTRACTOR SHALL VERIFY ALL CIRCUITS PRIOR TO MAKING CHANGES.

PANELBOARD SCHEDULE

Windley Key State Park
Windley Key, Florida

Panel **'A'**

Location **ELECTRICAL ROOM**

Fed From **PANEL 'M'**

Service **1** Phase **3** Wire
■ 240Y/120V
□ 480Y/277V

Main Bkr. **100 A** **3 P**
Lugs Only **- A**

10,000 AIC
60 Hz
■ Surface mounted panel

Remarks
PANEL IS EXISTING TO REMAIN.

LOADS SHOWN WERE TAKEN FROM AS-BUILTS AND NOTES IN THE FIELD. CONTRACTOR SHALL VERIFY ALL CIRCUITS PRIOR TO MAKING CHANGES.

BOLD INDICATES CIRCUITS TO BE REMOVED AND SHADED INDICATES CIRCUITS ARE EXISTING TO REMAIN.

PANEL SCHEDULES - NEW CONDITIONS

LOAD / REMARKS	CIR. NO.	BREAKERS		H.P. OR K.W.	AMPS PER PHASE									H.P. OR K.W.	BREAKERS		CIR. NO.	LOAD / REMARKS				
		AMPS	POLES		LIGHTING			GEN. RECEPTS			SPECIAL				AMPS	POLES						
					ØA	ØB	ØC	ØA	ØB	ØC	ØA	ØB	ØC									
SURGE PROTECTOR (SPD)	1	30	3	-											-	40	2	2	AC INDOOR - 1st FLOOR			
	3																	4				
	5																	6	PANEL 'A'			
AC INDOOR - 2nd FLOOR	7	40	2	-														8				
	9																	10	WATER HEATER			
WATER HEATER - 1st FLOOR	11	20	2	-												-	25	2	12			
	13																	14	A/C-3 (INDOOR)			
AC OUTDOOR - 1st FLOOR	15	20	2	-										14				16				
	17																-	20	2	18	DOSING PUMPS	
AC OUTDOOR - 2nd FLOOR	19	30	2	-															20	2	20	
	21																				22	ELEV.
A/C-3 (OUTDOOR)	23	40	2	-											28			-	100	3	24	
	25													28							26	
HAND DRYER (SEE NOTE BELOW)	27	20	1	-										9							28	SPACE
HAND DRYER (SEE NOTE BELOW)	29	20	1	-													9				30	SPACE
SPACE	31																				32	SPACE
SPACE	33																				34	SPACE
SPACE	35																				36	SPACE
SPACE	37																				38	SPACE
SPACE	39																				40	SPACE
SPACE	41																				42	SPACE
TOTAL CONNECTED LOAD (AMPS)					-	-	-	-	-	-	-	-	-	-	TOTAL CONNECTED LOAD (AMPS)							

PANELBOARD SCHEDULE

Windley Key State Park
Windley Key, Florida

Panel

'M'

Location

ELECTRICAL ROOM

Fed From

SERVICE DISC.

Service

3

Phase

4

Wire

■ 240V/120V, HIGH LEG

□ 480Y/277V

Main Bkr.

300 A

3 P

Lugs Only

-

A

10,000 AIC

60 Hz.

■ Surface mounted panel

Remarks

PANEL IS EXISTING TO REMAIN.

LOADS SHOWN WERE TAKEN FROM AS-BUILTS AND NOTES IN THE FIELD. CONTRACTOR SHALL VERIFY ALL CIRCUITS PRIOR TO MAKING CHANGES.

PANEL 'M' IS A 3Ø HIGH-LEG TYPE PANEL. CONTRACTOR SHALL VERIFY SINGLE PHASE CIRCUITS ARE ADDED TO 120V PHASE.

PANELBOARD SCHEDULE

Windley Key State Park
Windley Key, Florida

Panel **'M'**

Location **ELECTRICAL ROOM**

Fed From **SERVICE DISC.**

Service **3** Phase **4** Wire
■ 240Y/120V, HIGH LEG
□ 480Y/277V

Main Bkr. **300 A** **3 P**
Lugs Only **- A**

10,000 AIC
60 Hz
■ Surface mounted panel

Remarks
PANEL IS EXISTING TO REMAIN.

LOADS SHOWN WERE TAKEN FROM AS-BUILTS AND NOTES IN THE FIELD. CONTRACTOR SHALL VERIFY ALL CIRCUITS PRIOR TO MAKING CHANGES.

LOAD / REMARKS	CIR. NO.	BREAKERS		H.P. OR K.W.	AMPS PER PHASE												H.P. OR K.W.	BREAKERS		CIR. NO.	LOAD / REMARKS
		AMPS	POLES		LIGHTING			GEN. RECEPTS			SPECIAL			AMPS	POLES						
					ØA	ØB	ØC	ØA	ØB	ØC	ØA	ØB	ØC								
1st FLOOR LIGHTING	1	20	1	-	-	-	-	-	-	-	-	-	-	-	20	1	2	REC – NORTH WALL, 1st FL			
STAIRWAY LIGHTING	3	20	1	-	-	-	-	-	-	-	-	-	-	-	20	1	4	REC – SOUTH WALL, 1st FL			
2nd FLOOR LIGHTING	5	20	1	-	-	-	-	-	-	-	-	-	-	-	20	1	6	REC – RR, STORAGE			
RRS, ELEC. MECH. LIGHTING	7	20	1	-	-	-	-	-	-	-	6	-	-	-	20*	1	8	WATER COOLER			
BREEZE WAY LIGHTING	9	20	1	-	-	-	-	-	-	-	-	-	-	-	20	1	10	REC – NORTH WALL, 2nd FL			
PARKING LOT LIGHTS	11	20	1	-	-	-	-	-	-	-	-	-	-	-	20	1	12	REC – SOUTH WALL, 2nd FL			
PARKING LOT LIGHTS	13	20	1	-	-	-	-	-	-	-	-	-	-	-	20	1	14	REC – ELEVATOR WELL			
REC – ELEVATOR RM	15	20	1	-	-	-	-	-	-	-	-	-	-	-	50	2	16	KITCHEN STOVE / OVEN			
ELEVATOR EQUIP. CONTROLS	17	20	1	-	-	-	-	-	-	-	-	-	-	-	20	1	18	REC – REFRIGERATOR			
SHED IN PARKING LOT	19	20	1	-	-	-	-	-	-	-	-	-	-	-	20	1	20	REC – KITCHEN GFCI			
FIRE PANEL	21	20	1	-	-	-	-	-	-	-	-	-	-	-	20	1	22	EXISTING LOAD			
REC - VENDING	23	20	1	-	-	-	-	-	-	-	-	10	-	-	20	2	24				
SPARE	25	20	1	-	-	-	-	-	-	-	-	-	-	-	20	2	26				
OUTSIDE WHEELCHAIR	27	20	1	-	-	-	-	-	-	-	-	-	-	-	60	2	28	SEWER PUMP			
REC – COMM.	29	20	1	-	-	-	-	-	-	-	-	-	-	-			30				
TOTAL CONNECTED LOAD (AMPS)					-	-	-	-	-	-	-	-	-	-	TOTAL CONNECTED LOAD (AMPS)						

PANELBOARD SCHEDULE		
Panel	'A'	
Location	ELECTRICAL ROOM	
Fed From	PANEL 'M'	
Service	1 Phase	3 Wire
■ 240Y/120V		
□ 480Y/277V		
Main Bkr.	100 A	3 P
Lugs Only	- A	
	10,000 AIC	
	60 Hz.	
■ Surface mounted panel		
Remarks	PANEL IS EXISTING TO REMAIN.	
LOADS SHOWN WERE TAKEN FROM AS-BUILTS AND NOTES IN THE FIELD. CONTRACTOR SHALL VERIFY ALL CIRCUITS PRIOR TO MAKING CHANGES.		
* INDICATES GFCI BREAKER.		

PANELBOARD SCHEDULE

Windley Key State Park
Windley Key, Florida

Panel **'A'**

Location **ELECTRICAL ROOM**

Fed From **PANEL 'M'**

Service **1** Phase **3** Wire
■ 240Y/120V
□ 480Y/277V

Main Bkr. **100 A** **3 P**
Lugs Only **- A**

10,000 AIC
60 Hz
■ Surface mounted panel

Remarks
PANEL IS EXISTING TO REMAIN.

LOADS SHOWN WERE TAKEN FROM AS-BUILTS AND NOTES IN THE FIELD. CONTRACTOR SHALL VERIFY ALL CIRCUITS PRIOR TO MAKING CHANGES.

* INDICATES GFCI BREAKER.

BOLD INDICATES CIRCUITS TO BE ADDED AND SHADED INDICATES CIRCUITS THAT ARE EXISTING.

DEMAND LOAD NOTES

HISTORICAL DEMAND LOAD DATA FOR LAST 12 MONTHS PROVIDED BY UTILITY INDICATES PEAK DEMAND LOAD OF 13.447KW, 16.81KVA @ 0.8pf, 40A, 240V,