



STATE OF FLORIDA
DEPARTMENT OF HEALTH
ONSITE SEWAGE TREATMENT AND DISPOSAL
SYSTEM

PERMIT #: **12-SC-3067029**
APPLICATION #: **AP2189933**
DATE PAID: _____
FEE PAID: _____
RECEIPT #: _____
DOCUMENT #: **PR2266224**

CONSTRUCTION PERMIT FOR: OSTDS New
APPLICANT: SUWANNEE***25-0015 RIVER WATER MANAGEMENT
PROPERTY ADDRESS: 1245 MORRELL DRIVE White Springs, FL 32096
LOT: _____ BLOCK: _____ SUBDIVISION: _____
PROPERTY ID #: 01590-000 [SECTION, TOWNSHIP, RANGE, PARCEL NUMBER]
[OR TAX ID NUMBER]

SYSTEM MUST BE CONSTRUCTED IN ACCORDANCE WITH SPECIFICATIONS AND STANDARDS OF SECTION 381.0065, F.S., AND CHAPTER 64E-6, F.A.C. DEPARTMENT APPROVAL OF SYSTEM DOES NOT GUARANTEE SATISFACTORY PERFORMANCE FOR ANY SPECIFIC PERIOD OF TIME. ANY CHANGE IN MATERIAL FACTS, WHICH SERVED AS A BASIS FOR ISSUANCE OF THIS PERMIT, REQUIRE THE APPLICANT TO MODIFY THE PERMIT APPLICATION. SUCH MODIFICATIONS MAY RESULT IN THIS PERMIT BEING MADE NULL AND VOID. ISSUANCE OF THIS PERMIT DOES NOT EXEMPT THE APPLICANT FROM COMPLIANCE WITH OTHER FEDERAL, STATE, OR LOCAL PERMITTING REQUIRED FOR DEVELOPMENT OF THIS PROPERTY.

SYSTEM DESIGN AND SPECIFICATIONS

T [1,050] GALLONS / GPD New Multi-Chambered Septic CAPACITY
A [] GALLONS / GPD N/A CAPACITY
N [] GALLONS GREASE INTERCEPTOR CAPACITY [MAXIMUM CAPACITY SINGLE TANK:1250 GALLONS]
K [] GALLONS DOSING TANK CAPACITY [] GALLONS @ [] DOSES PER 24 HRS #Pumps []

D [500] SQUARE FEET Quick 4 EQ 36 Drainfield SYSTEM
R [] SQUARE FEET N/A SYSTEM
A TYPE SYSTEM: [X] STANDARD [] FILLED [] MOUND []
I CONFIGURATION: [X] TRENCH [] BED []

N
F LOCATION OF BENCHMARK: Nail in tree near carport

I ELEVATION OF PROPOSED SYSTEM SITE [11.00] [INCHES] FT [] [ABOVE / BELOW] BENCHMARK/REFERENCE POINT
E BOTTOM OF DRAINFIELD TO BE [37.00] [INCHES] FT [] [ABOVE / BELOW] BENCHMARK/REFERENCE POINT

L
D FILL REQUIRED: [0.00] INCHES EXCAVATION REQUIRED: [] INCHES

O
T
H
E
R
The system is sized for 3 bedrooms with a maximum occupancy of 6 persons (2 per bedroom), for a total estimated flow of 400 gpd.
System to be installed per engineer design. Abandon old tank on property at time of install.

SPECIFICATIONS BY: Sean P Havens TITLE: Environmental Specialist I

APPROVED BY: [Signature] TITLE: Environmental Specialist I Columbia CHD

DATE ISSUED: 05/22/2025 EXPIRATION DATE: 11/22/2026

DEP 4015, 06-21-2022 (Obsoletes previous editions which may not be used)

Incorporated 62-6.004, FAC

141


NOTICE OF RIGHTS

A party whose substantial interest is affected by this order may petition for an administrative hearing pursuant to sections 120.569 and 120.57, Florida Statutes. Such proceedings are governed by Rule 28-106, Florida Administrative Code. A petition for administrative hearing must be in writing and must be received by the Agency Clerk for the Department, within twenty-one (21) days from the receipt of this order. The address of the agency clerk is 3900 Commonwealth Boulevard, Mail Station 35, Tallahassee, Florida 32399-3000. The Agency Clerk's email is agency_clerk@FloridaDEP.gov.


Mediation is not available as an alternative remedy.

Your failure to submit a petition for hearing within 21 days from receipt of this order will constitute a waiver of your right to an administrative hearing, and this order shall become a 'final order'.

Should this order become a final order, a party who is adversely affected by it is entitled to judicial review pursuant to Section 120.68, Florida Statutes. Review proceedings are governed by the Florida Rules of Appellate Procedure. Such proceedings may be commenced by filing one copy of a Notice of Appeal with the Agency Clerk of the Department of Environmental Protection and a second copy, accompanied by the filing fees required by law, with the Court of Appeal in the appropriate District Court. The notice must be filed within 30 days of rendition of the final order.

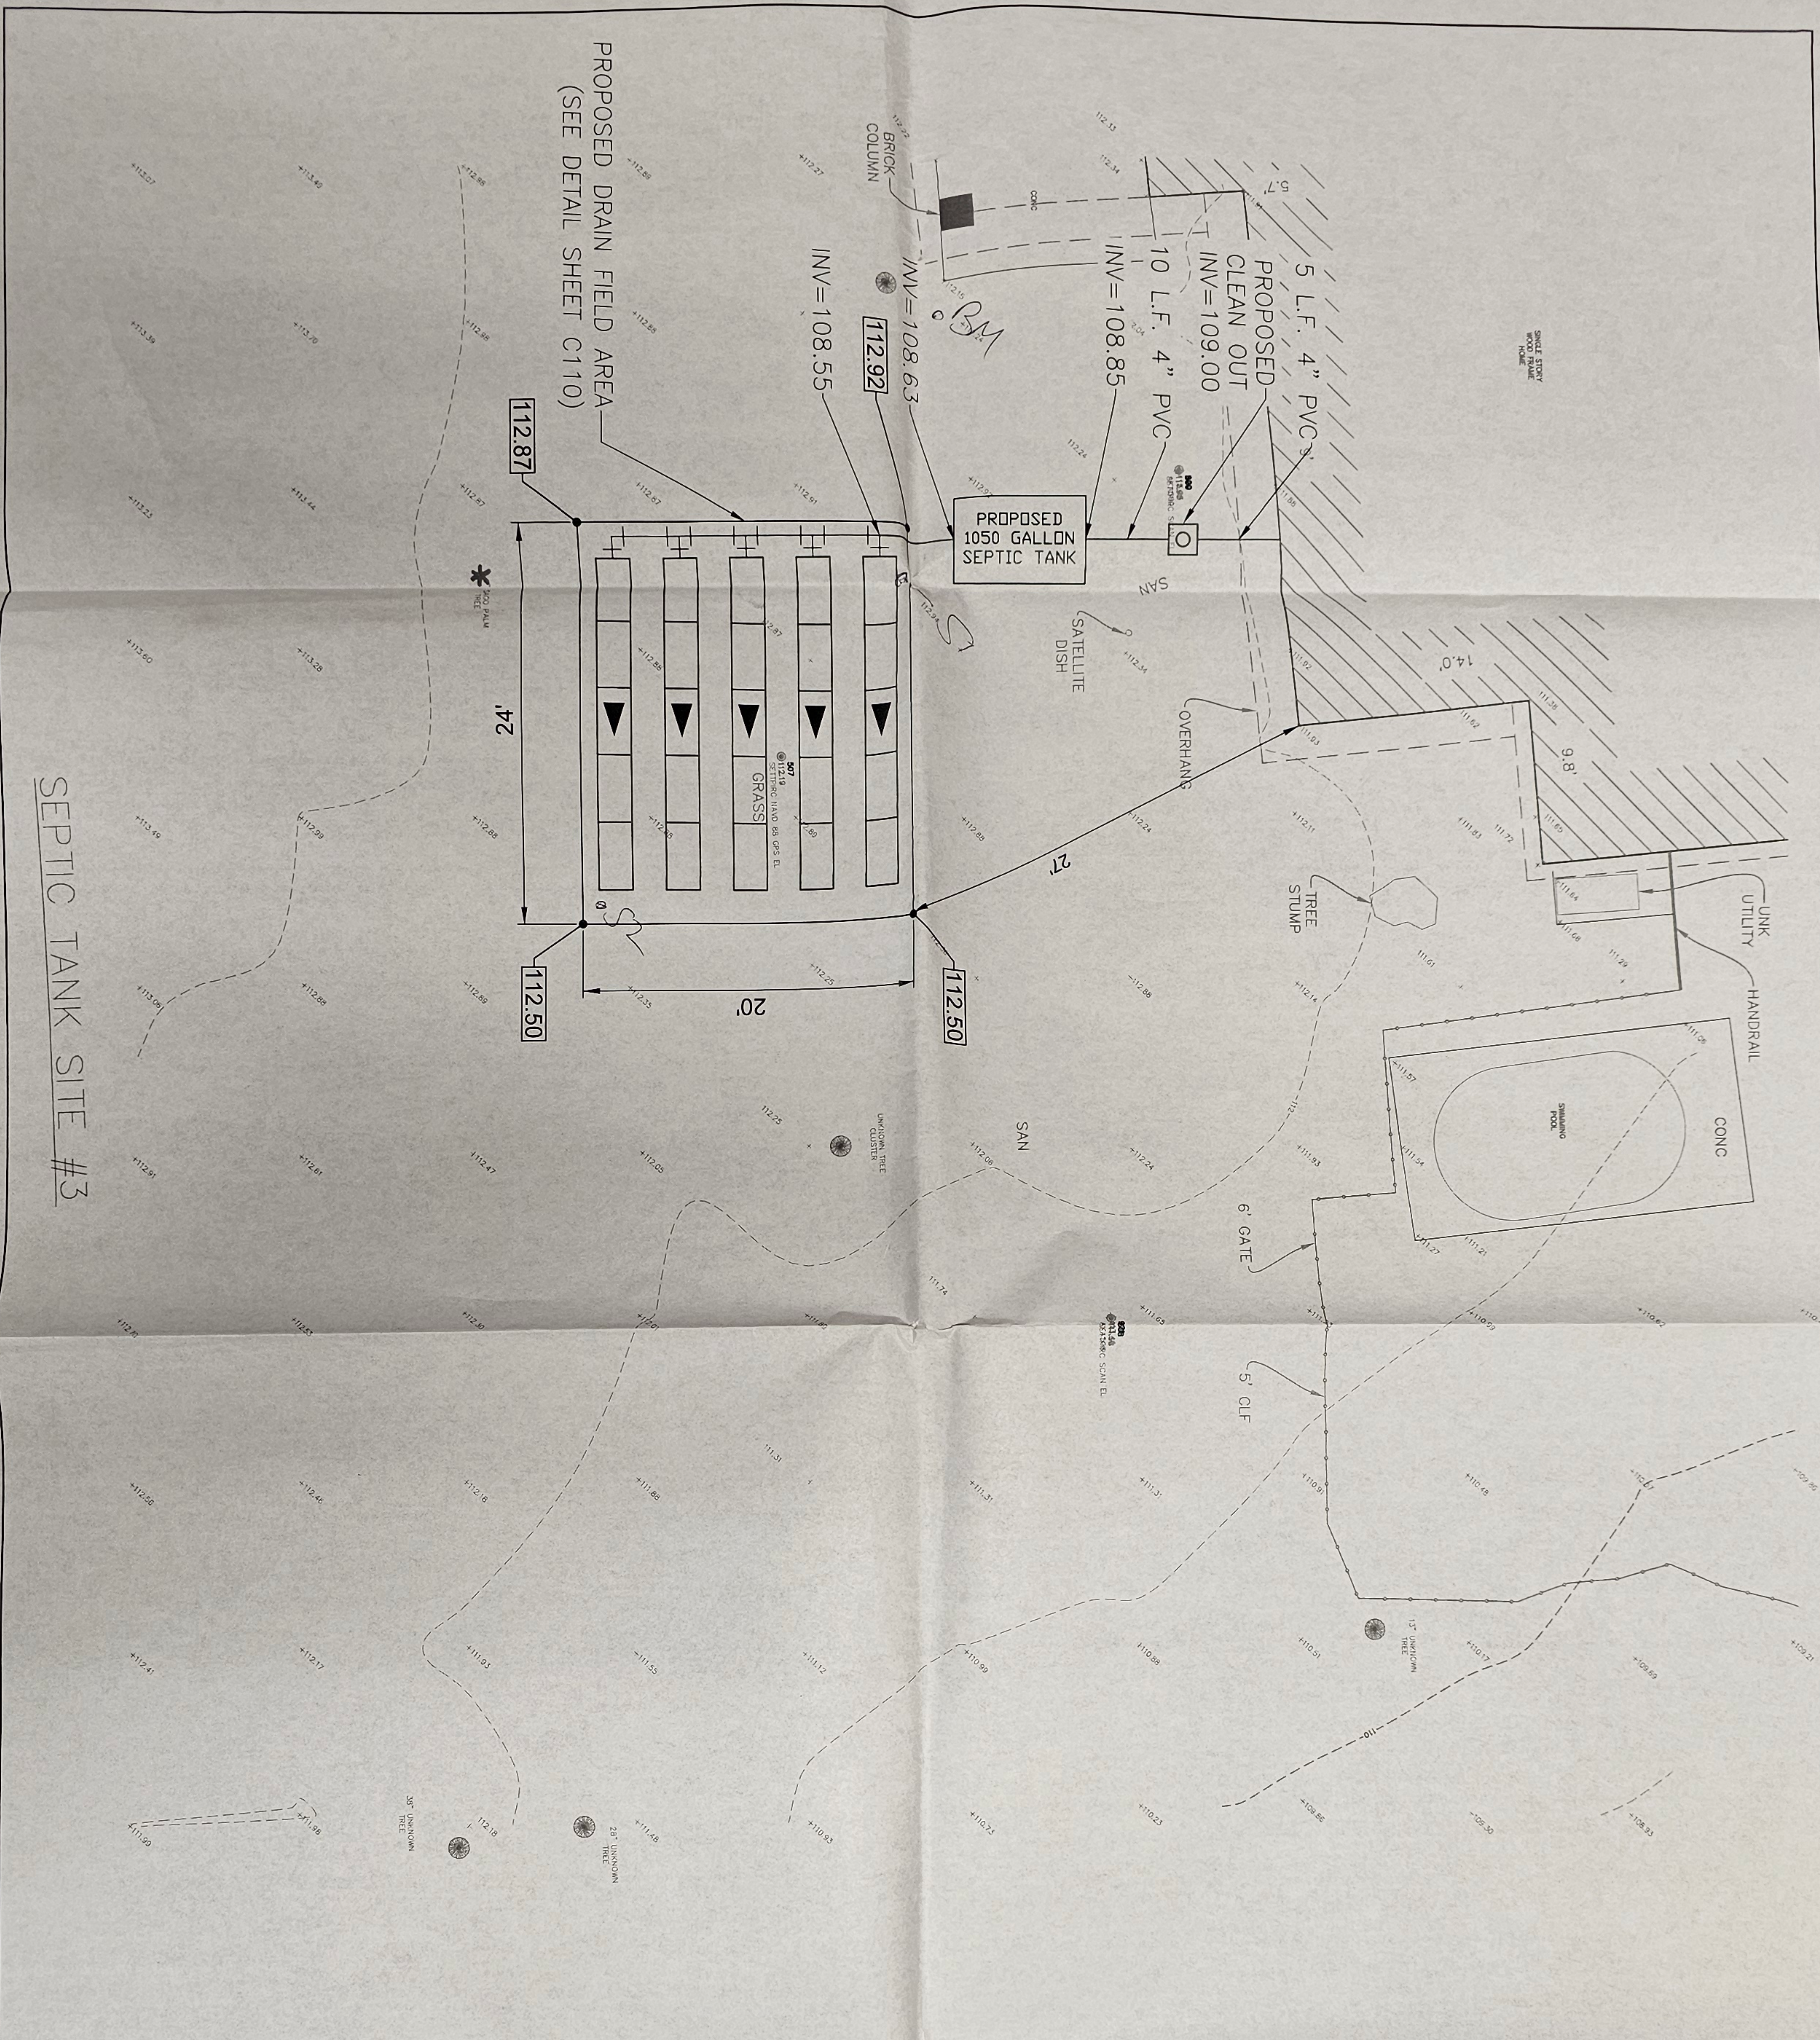

SEPTIC TANK SITE #3

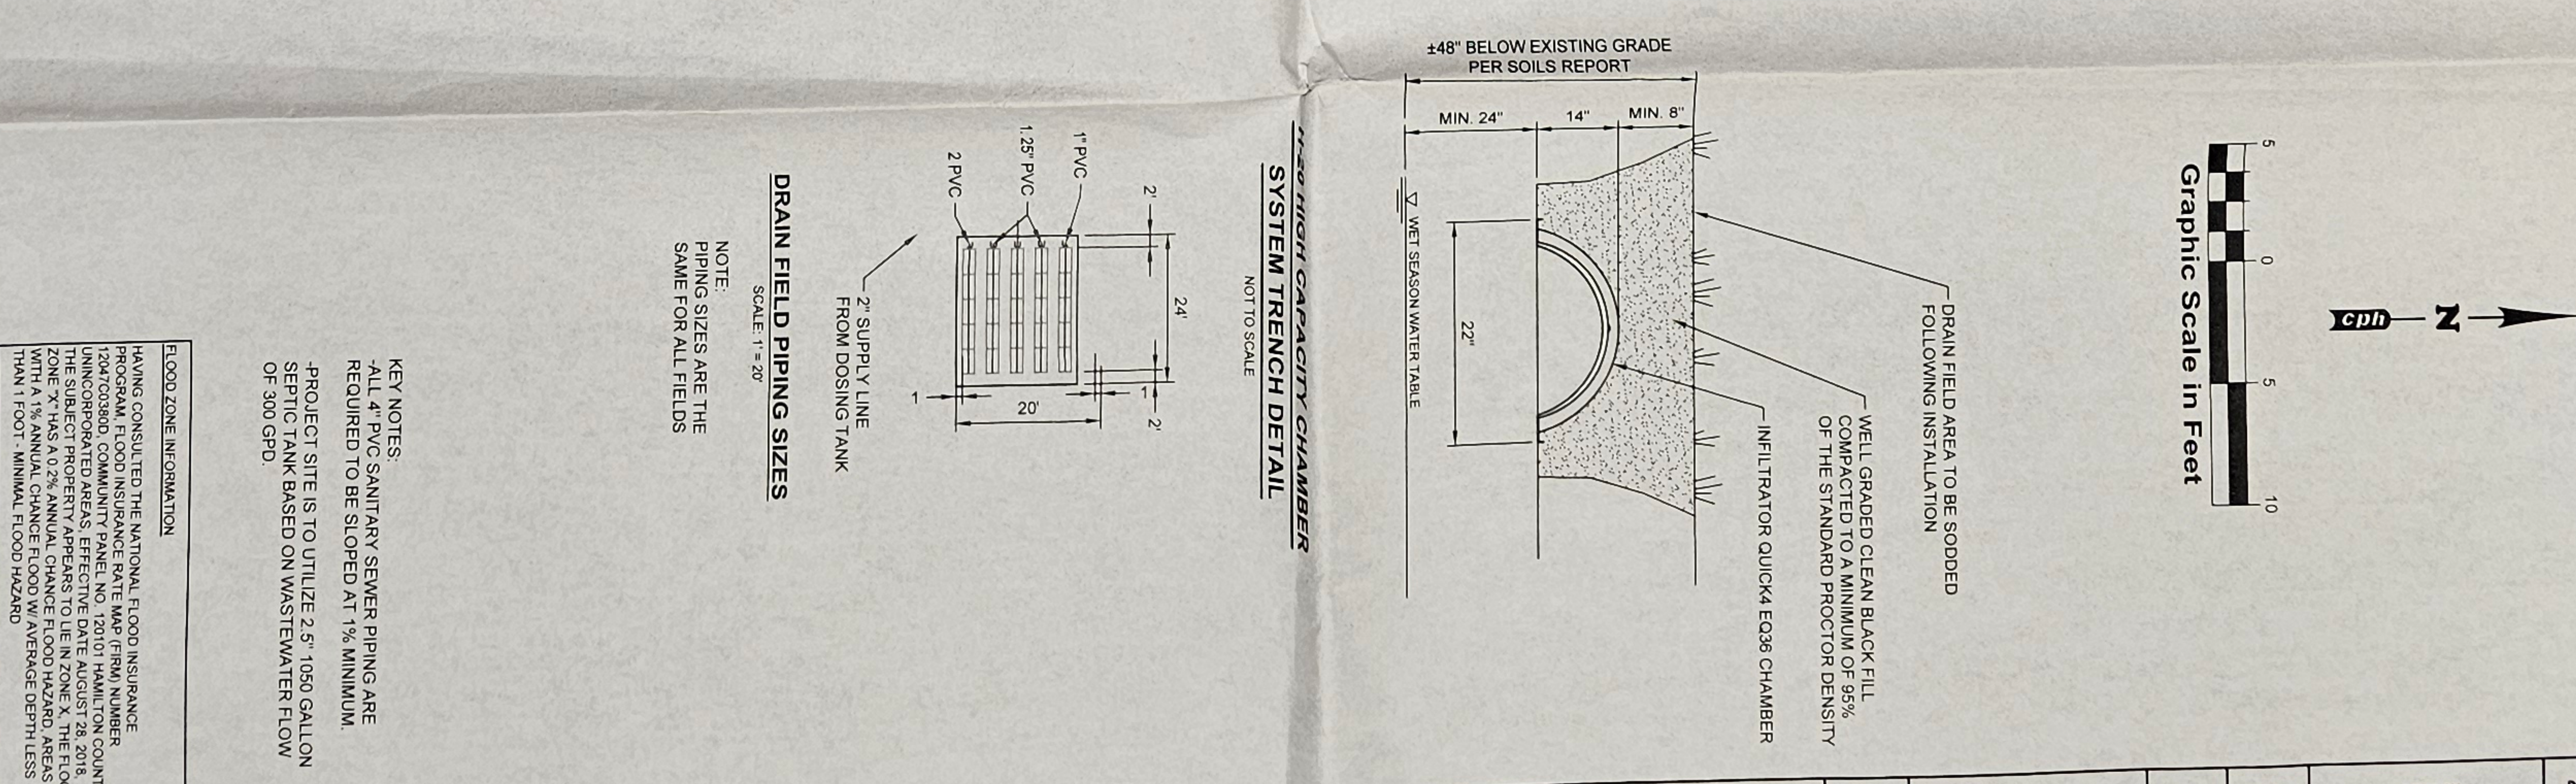

SHEET NO. C107	BIG SHOALS STATE PARK AREA 3 SEPTIC TANK SITE PLAN		PROFESSIONAL REGISTRATION KAYLA D. SHEFFIELD P.E. LICENSE NUMBER - 92781	DESIGNER : K. Sheffield DRAWN BY : P. Sheffield REVIEWED BY : K. Sheffield Consultant :	ISSUE DATE: 11-7-23 COMP. FILE No.: F13636 STATE PROJECT No.: TA49	SYMBOL (A) (B)	REVISION	DATE	SYMBOL (C) (D)	REVISION	DATE
	PROJECT TITLE UNDERGROUND SEPTIC SYSTEM		Department of Environmental Protection Division of Recreation and Parks Bureau of Design and Construction 3800 Commonwealth Blvd., Tallahassee, FL 32399 (850) 245-2157								
	FLOOD ZONE INFORMATION HAVING CONSULTED THE NATIONAL FLOOD INSURANCE PROGRAM, FLOOD INSURANCE RATE MAP (FIRM) NUMBER 124030000, COMMUNITY PANEL NO. 120101 HAMILTON COUNTY, THE SUBJECT PROPERTY APPEARS TO BE IN A FLOOD HAZARD ZONE. THE PROPERTY APPEARS TO BE IN A FLOOD HAZARD ZONE WITH A 1% ANNUAL CHANCE FLOOD W/ AVERAGE DEPTH LESS THAN 1.0 FT. ANNUAL FLOOD HAZARD.		KEY NOTES: -ALL 4" PVC SANITARY SEWER PIPING ARE REQUIRED TO BE SLOPED AT 1% MINIMUM. -PROJECT SITE IS TO UTILIZE 2.5" 1050 GALLON SEPTIC TANK BASED ON WASTEWATER FLOW OF 300 GPD.								