

ABBREVIATIONS

A.F.F. ABOVE FINISHED FLOOR
A.H.U. AIR HANDLING UNIT
ALUM. ALUMINUM
ALT. ALTERNATE
APPROX. APPROXIMATE

BD. BOARD
BLDG. BUILDING
BLK. BLOCK
BLCKNG. BLOCKING
BLT. BUILT
BRK. BRICK
BRKR. BREAKER
BSMT. BASEMENT

C.J. CONTROL JOINT
CLG. CEILING
CLR. CLEAR
CML. CONCRETE MASONRY UNIT
C.O. CLEAN OUT
CONC. CONCRETE
COP. COPPER
CU. FT. CUBIC FOOT
CU. IN. CUBIC INCH
CU. YD. CUBIC YARD

DIA. / Ø. DIAMETER
DBL. DOUBLE
DPT. DRY-BULB TEMPERATURE
DEG. DEGREE
DEPTHT. DEPTH
DF. DRINKING FOUNTAIN
DISC. DISCONNECT
D.L. DEAD LOAD
DN. DOWN
D.S. DOWN SLOUT
DWG. DRAWING

E.F. EXHAUST FAN
EXH. EXHAUST
EXP. JT. EXPANSION JOINT
EXT. EXTERIOR

FIN. FINISH
FL. FLOOR
FLUOR. FLUORESCENT
FR. FIRE
FR. FIRE RATING
FT. FOOT/FEET
FTG. FOOTING

GALV. GALVANIZED
GFI GROUND FAULT
GFI CIRCUIT INTERRUPT
GOVT. GOVERNMENT
GR.FL. GROUND FLOOR
GY. GYPSUM

H.C. HOLLOW CORE
H.D.C. HOT DIPPED GALVANIZED
HDR. HEADER
HWS. HANGING
H.P. HORSEPOWER
Ht. HEIGHT
HTR. HEATER
HV. HIGH VOLTAGE
HVAC. HEATING, VENTILATING
AND AIR CONDITIONING
HWY. HIGHWAY

ID. INSIDE DIAMETER
IN. INCH
INCAND. INCANDESCENT
INCL. INCLUDED
INSUL. INSULATION
INT. INTERIOR
INV. EL. INVERT ELEVATION

JST. JOIST

KD. KILN DRIED
KW. KILOWATT
KWH. KILOWATT HOUR

LAM. LAMINATED
LAV. LAVATORY
LB. POUND
LTC. LIGHTING
LTH. LENGTH
LIN. LINEAR
LL. LIVE LOAD

MANUF. MANUFACTURE
MAX. MAXIMUM
MF. MILL FINISH
MNL. MINIMUM
MLDG. MOLDING
MHW. MEAN HIGH WATER
MHHW. MEAN HIGHER HIGH WATER
MLW. MEAN LOW WATER
MLLW. MEAN LOWER LOW WATER
MSL. MEAN SEA LEVEL
MOD. MODIFICATION

NTS. NOT TO SCALE
NO./#. NUMBER

OA. OVERALL
O.C. ON CENTER
O.D. OUTSIDE DIAMETER
OFF. OFFICE
O/H. OVER HEAD
OPP. OPPOSITE

PARTN. PARTITION
PC. PORTLAND CEMENT
P.C. POUNDS PER CUBIC FOOT
P.E. PROFESSIONAL ENGINEER
PERF. PERFORATE
PERP. PERPENDICULAR
PL. PLATE
PLG. PLING
PLYWD. PLYWOOD
PRELIM. PRELIMINARY
PRETAB. PREFABRICATED
PSF. POUNDS PER SQUARE FOOT
PSI. POUNDS PER SQUARE INCH
P.T. PRESSURE TREATED

QS. QUARTER SAWN

R. RADIUS
RCPT. RECEPTACLE
REBAR. REINFORCING BAR
REFRIG. REFRIGERATION
REINFR. REINFORCING
RFR. ROOFING
RGR. ROUGH
RM. ROOM
R.O. ROUGH OPENING
RS. ROUGH SAWN

S.C. SOLID CORE
SCH. SCHEDULE
SD. Siding
SD. SECTION
SPWD. SPLITWOOD
SG. SLIDING GLASS DOOR
SH. SHINGLES
SPEC. SPECIFICATION
SPR. SPRUCE
SQ. SQUARE
SQ. FT. SQUARE FOOT
SQ. IN. SQUARE INCH
SQ. YD. SQUARE YARD
S.S. STAINLESS STEEL
STL. STEEL
SUB. FL. SUBFLOOR
SUP. SUPPLY
SW. SWITCH
S.Y.P. SYMMETRICAL
S.Y.P. SOUTHERN YELLOW PINE
SYS. SYSTEM
SAS. SURFACED FOUR SIDES


TEL. TELEPHONE
T&G. TONGUE-AND-GROOVE
TYP. TYPICAL
U.E. UNDERGROUND ELECTRIC
U.G. UNDER GROUND
UNDWR. UNDERWRITERS
LABORATORIES, INC.

V. VOLT
VENT. VENTILATOR
VF. VERTICAL
VF. VENT IN FIELD
VOL. VOLUME
VP. VENT PIPE
VTR. VENT THRU ROOF

W. WATER
WBT. WET-BULB TEMPERATURE
WC. WATER CLOSET
W. WOOD
WP. WATERPROOF
WTF. WELDED WIRE FABRIC

YD. YARD

REFERENCE LEGEND

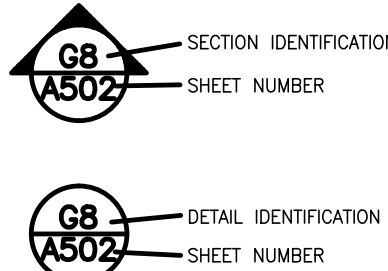

BLUE SPRING
STATE PARK
DISTRICT 3
VOLUSIA

RESTROOM REPLACEMENT
PROJECT # 61565C (100% SUBMITTAL)

APPLICABLE CODES AND DESIGN DATA

FLORIDA BUILDING CODE, BUILDING (FBC-B).....	2023 Edition
FLORIDA BUILDING CODE, FUEL GAS (FBC-FG).....	2023 Edition
FLORIDA BUILDING CODE, MECHANICAL (FBC-M).....	2023 Edition
FLORIDA BUILDING CODE, PLUMBING (FBC-P).....	2023 Edition
FLORIDA BUILDING CODE, EXISTING BUILDING (FBC-EB).....	2023 Edition
FLORIDA BUILDING CODE, RESIDENTIAL (FBC-R).....	2023 Edition
FLORIDA FIRE PREVENTION CODE (FFPC).....	2023 Edition
NATIONAL ELECTRICAL CODE NFPA-70.....	2023 Edition
FDOT STANDARD SPECIFICATIONS FOR ROAD & BRIDGE CONST.	Latest Edition
FDOT DESIGN STANDARDS.....	Latest Edition
FLORIDA ACCESSIBILITY CODE.....	2023 Edition

DESIGN DATA

CONSTRUCTION TYPE:	TOTAL BUILDING AREA PER FLOOR:
OCCUPANCY CLASS:	BUILDING HEIGHT/NUMBER OF STORIES:
OCCUPANT LOAD:	REQUIRED SPRINKLER OR ALARM SYSTEM: Yes / No
TOTAL EXITS:	NUMBER OF BEDROOMS:
SQ FT ALTERED AREA	LEVEL OF ALTERATION:

DESIGN LOADS (FBC-B CHAPTER 16):

WIND LOADS (FBC-B SECTION 1609):

LIFE SAFETY PLAN:

SCOPE OF PROJECT


REPLACE RESTROOM IN ORDER TO INCREASE THE LONGEVITY OF THE FACILITY.



"THIS ITEM HAS BEEN DIGITALLY SIGNED AND SEALED BY JONATHAN LANGSTON ON THE DATE ADJACENT TO THE SEAL. PRINTED COPIES OF THIS DOCUMENT ARE NOT CONSIDERED SIGNED AND SEALED AND THE SIGNATURE MUST BE VERIFIED ON ANY ELECTRONIC COPIES."

JONATHAN LANGSTON
DESIGNER


CN824
CONSULTANT CONTRACT No.
05/06/25
INITIAL ISSUE DATE

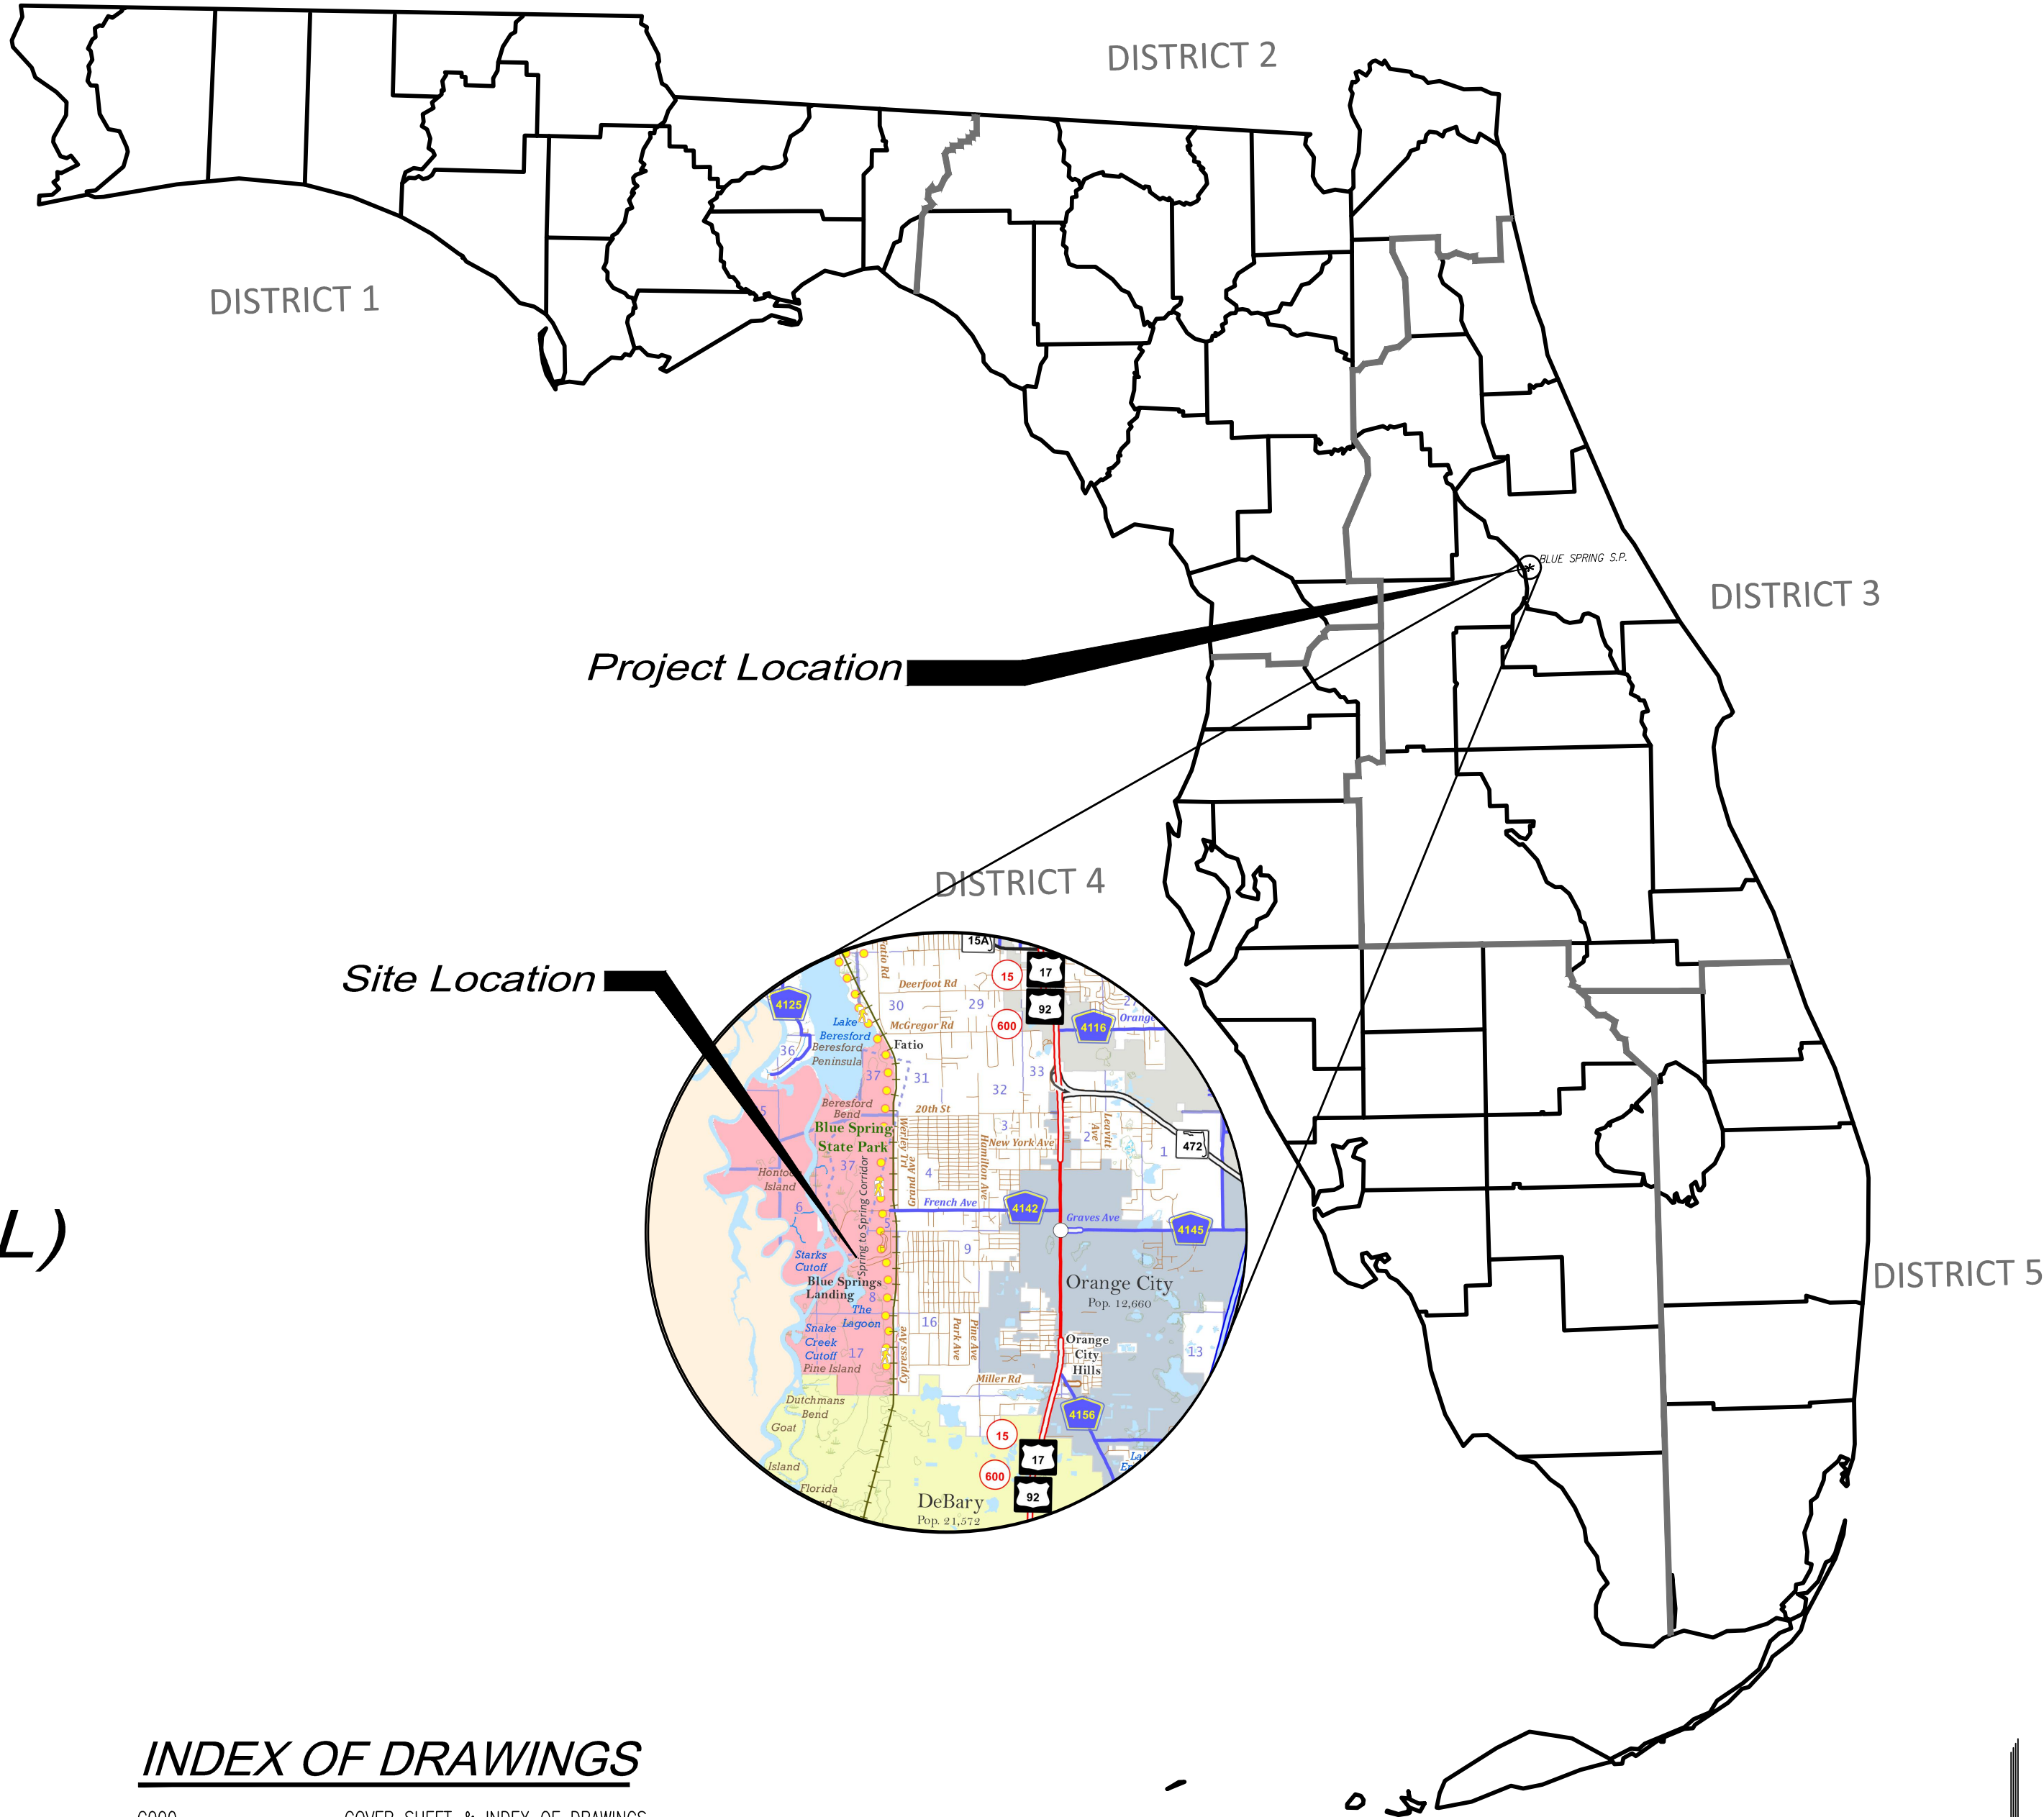

INDEX OF DRAWINGS

C000	COVER SHEET & INDEX OF DRAWINGS
C001	GENERAL NOTES
C100	EXISTING CONDITIONS
C101	DEMO AND EROSION CONTROL PLANS
C102	SITE AND GRADING PLAN
C103	UTILITY PLAN
C500	EROSION CONTROL DETAILS
C501	HANDRAIL DETAILS
A-000*	ARCHITECTURAL COVER SHEET & INDEX OF DRAWINGS
A-100*	ARCHITECTURAL SITE PLAN
A-101*	FLOOR PLAN
A-102*	ROOF PLAN, CEILING PLAN AND FINISH LEGEND
A-201*	BUILDING ELEVATIONS
A-301*	BUILDING SECTION & INTERIOR ELEVATIONS
A-302*	SECTIONS & DETAILS
A-401*	BENCH & GUARDRAIL DETAILS
A-501*	ARCHITECTURAL SPECIFICATIONS
E-001*	ELECTRICAL COVER SHEET & INDEX OF DRAWINGS
E-001-002*	ELECTRICAL - GENERAL
E-201*	ELECTRICAL PLANS
E-801*	ELECTRICAL SCHEDULES & DIAGRAMS
FA-001*	FIRE ALARM PLAN
M-001*	MECHANICAL COVER SHEET & INDEX OF DRAWINGS
M-100*	MECHANICAL SPECIFICATIONS
M-101*	MECHANICAL FLOOR PLAN
M-500*	MECHANICAL DETAILS & SCHEDULES
M-501*	MECHANICAL DETAILS
P-001*	PLUMBING COVER SHEET & INDEX OF DRAWINGS
P-100*	PLUMBING SPECIFICATIONS
P-101*	PLUMBING FLOOR PLAN
P-500*	PLUMBING SCHEDULES
P-501*	PLUMBING DETAILS
P-600*	PLUMBING RISER DIAGRAMS
S-000*	STRUCTURAL COVER SHEET & INDEX OF DRAWINGS
S-001*	GENERAL NOTES
S-002*	COMPONENTS & CLADDING
S-100*	FLOOR AND ROOF FRAMING PLANS
S-200-201*	TYPICAL DETAILS
S-300*	SECTIONS

*THESE SHEETS ARE INCLUDED IN THE INDEX OF DRAWINGS ONLY TO INDICATE THEY ARE PART OF THE PROJECT. THESE SHEETS ARE CONTAINED IN SEPARATE DIGITALLY SIGNED AND SEALED DOCUMENTS.

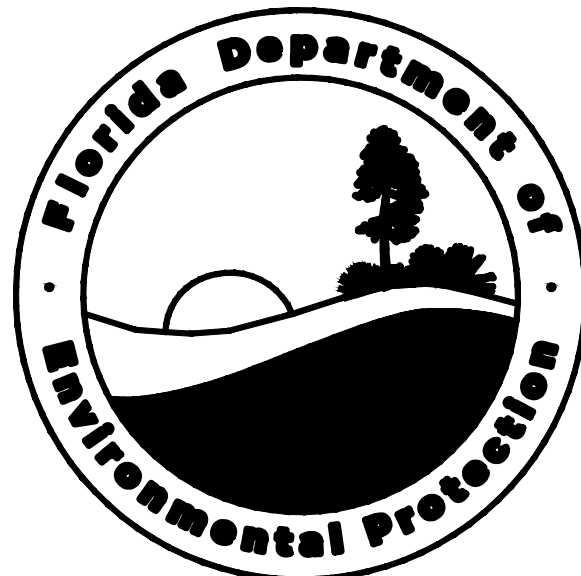



EROSION CONTROL LEGEND

- SF SILT FENCE PER DETAIL SHEET C500.0
X TREE REMOVAL

LEGEND


- ⊙ NAIL AND DISC SET
⊙ CLEANOUT
⊙ FAUCET OR HOSE BIB
* TREE PALM
⊙ TREE OAK
⊙ SERVICE BOX ELECTRIC
⊙ VALVE COVER UNKNOWN
TOB / TOE
CONCRETE

TREE LEGEND

- * TREE CEDAR
⊙ TREE OAK
* TREE PALM
* TREE PINE

ABBREVIATIONS

- CONC. CONCRETE
ELEV. ELEVATION
ID IDENTIFICATION
LB LICENSED BUSINESS
LS LICENSED SURVEYOR
MHW MEAN HIGH WATER
M/M MEET AND MATCH EXISTING ELEVATION
PLS PROFESSIONAL LAND SURVEYOR
PRM PERMANENT REFERENCE MONUMENT
PSM PROFESSIONAL SURVEYOR AND MAPPER
SIR SET IRON ROD
TBM TEMPORARY BENCH MARK
TOB TOP OF BANK
#WB-# WETLAND FLAG (SEE NOTE #21)
+ 00.0 SPOT ELEVATION
10 CONTOUR LINE
WET JURISDICTIONAL WETLAND LINE

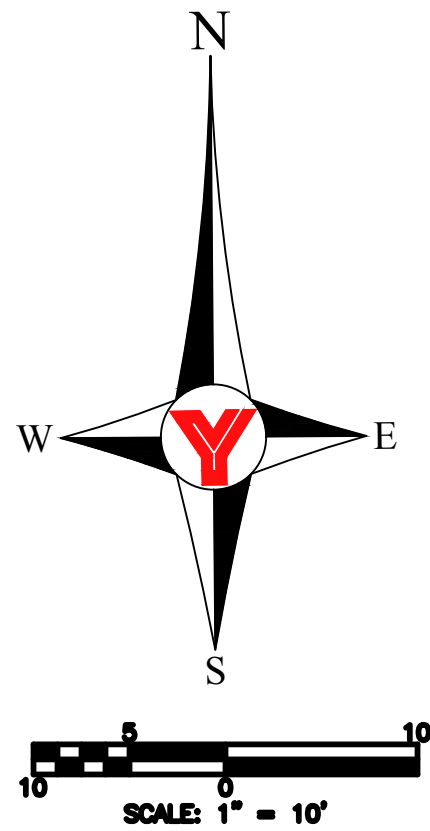



PROFESSIONAL REGISTRATION		DESIGNER :	ISSUE DATE:	SHEET NO.:	SYMBOL	REVISION	DATE	SYMBOL	REVISION	DATE
DRAWN BY:		COMP. FILE NO.:								
REVIEWED BY:		STATE PROJECT NO.:								
Consultant :										
SHEET TITLE		DEMO AND EROSION CONTROL PLAN								
PROJECT TITLE		BLUE SPRING STATE PARK RESTROOM REPLACEMENT								
SHEET NO.		C101								

Department of Environmental Protection
Division of Recreation and Parks
Bureau of Design and Construction
3800 Commonwealth Blvd., Tallahassee, FL 32399 (904) 245-2157

George F. Young, Inc.
290 DR. MARTIN LUTHER KING, JR. STREET, N. ST. PETERSBURG, FLORIDA 33701
REGISTERED PROFESSIONAL ENGINEER
FLORIDA LICENSE NUMBER 11111
CONSULTING ENGINEER
SINCE 1919



SECTION A-A (N.T.S.)

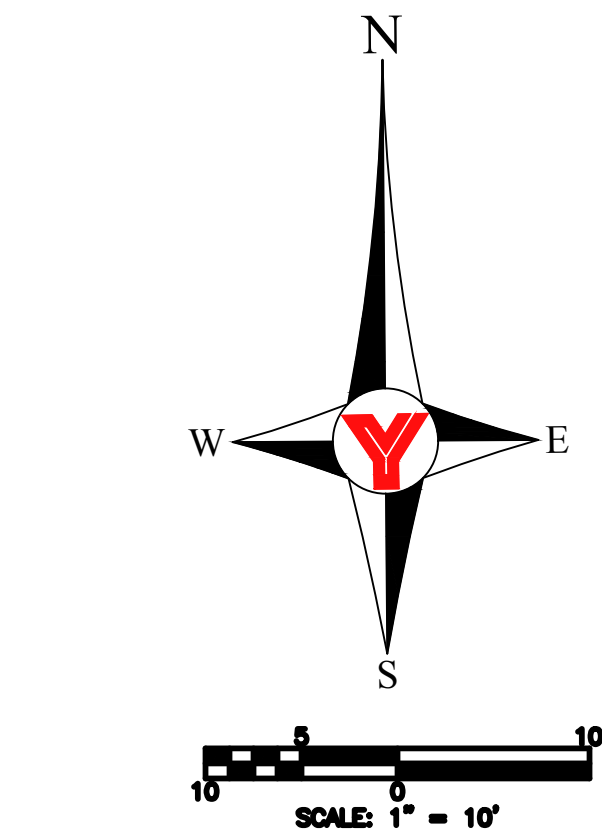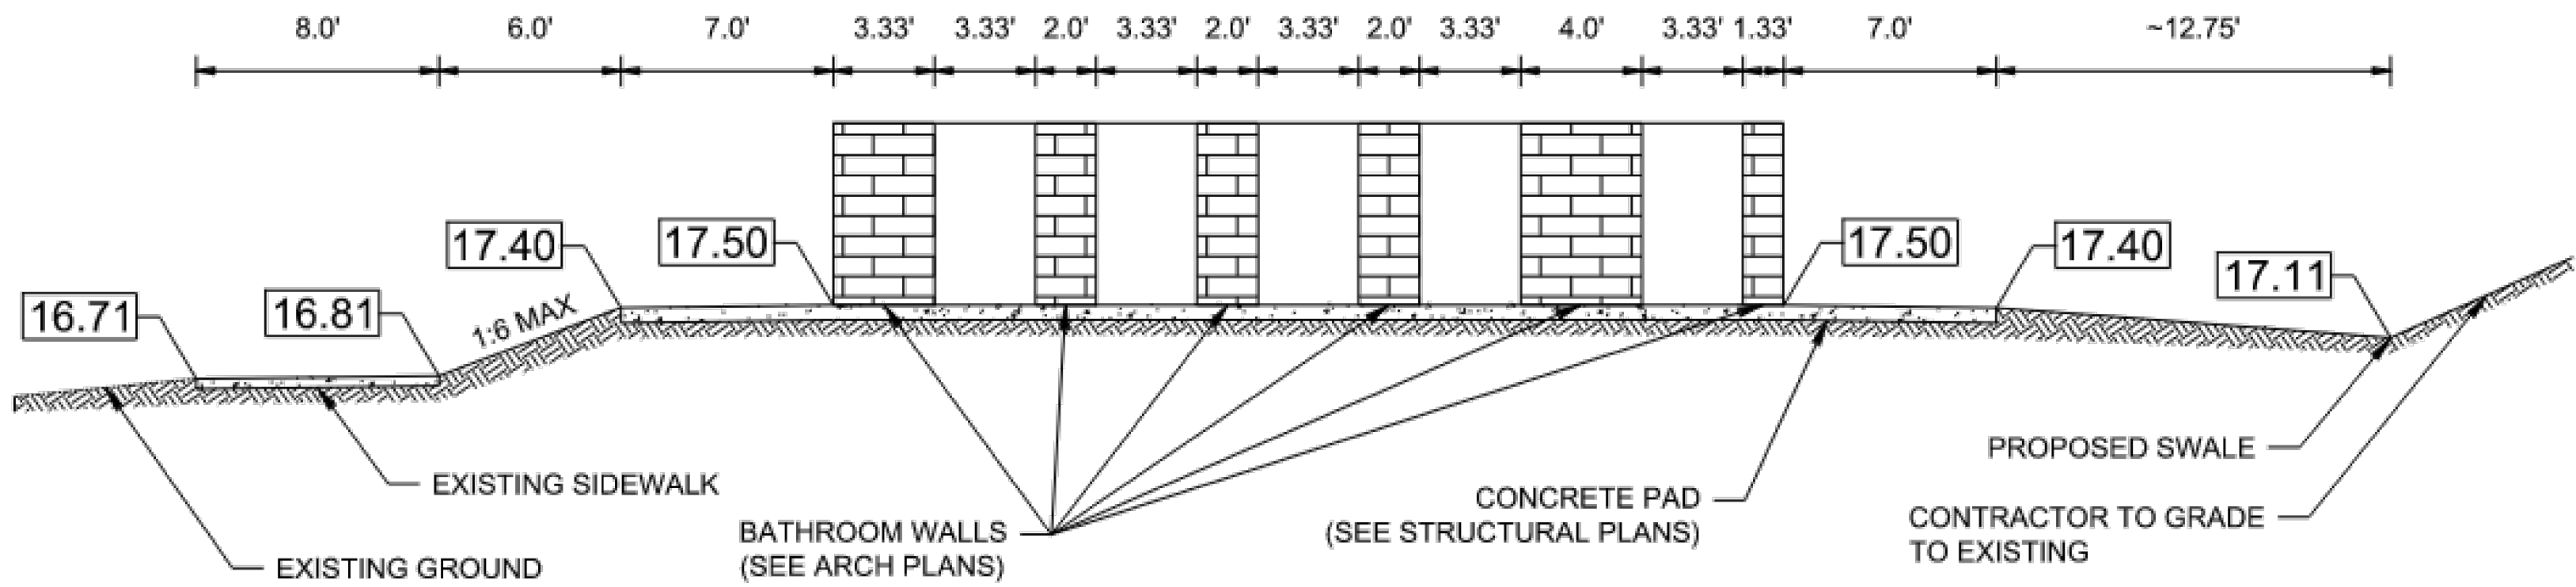

PROPOSED LEGEND

- PROPOSED 6" CONCRETE SIDEWALK
(CONSTRUCT PER FDOT SPECIFICATION 522)

NOTE

IT IS THE INTENT OF THIS DESIGN TO MEET ALL APPLICABLE ADA STANDARDS. SHOULD CONDITIONS OBSERVED IN CONSTRUCTION NOT MEET ADA CRITERIA, CONSULT THE ENGINEER

LEGEND

- NAIL AND DISC SET
- CLEANOUT
- FAUCET OR HOSE BIB
- TREE PALM
- TREE OAK
- SERVICE BOX ELECTRIC
- VALVE COVER UNKNOWN
- TOB / TOE
- CONCRETE

TREE LEGEND	
TREE CEDAR	
TREE OAK	
TREE PALM	
TREE PINE	





ABBREVIATIONS

- CONC. CONCRETE
- ELEV. ELEVATION
- ID IDENTIFICATION
- LB LICENSED BUSINESS
- LS LICENSED SURVEYOR
- MHW MEAN HIGH WATER
- M/M MEET AND MATCH EXISTING ELEVATION
- PLS PROFESSIONAL LAND SURVEYOR
- PRM PERMANENT REFERENCE MONUMENT
- PSM PROFESSIONAL SURVEYOR AND MAPPER
- SIR SET IRON ROD
- TM TEMPORARY BENCH MARK
- TOB TOP OF BANK
- #WB-# WETLAND FLAG (SEE NOTE #21)
- SPOT ELEVATION
- 10 CONTOUR LINE
- WET JURISDICTIONAL WETLAND LINE

SHEET NO.	C102	SHEET TITLE		SITE AND GRADING PLAN										PROFESSIONAL REGISTRATION									
		PROJECT TITLE		BLUE SPRING STATE PARK RESTROOM REPLACEMENT																			
		DESIGNER :		ISSUE DATE:		SYMBOL		REVISION		DATE		SYMBOL		REVISION		DATE							
		DRAWN BY:		COMP. FILE No.:		(A)						(C)											
		REVIEWED BY:		STATE PROJECT No.:		(B)						(D)											
		Consultant :																					
				 George F. Young, Inc. 290 OK MARTIN LUTHER KING JR. STREET N. ST. PETERSBURG, FL 33701 FLORIDA PROFESSIONAL ENGINEERING CERTIFICATE OF AUTHORIZATION NUMBER 31 CIVIL, TRANSPORTATION, LANDSCAPE ARCHITECTURE, MECHANICAL, ELECTRICAL, PLUMBING, CONSTRUCTION MANAGEMENT, ENVIRONMENTAL ENGINEERING COLLEGE OF THE SOUTHERN STATES 1915 W. 1ST STREET, ST. PETERSBURG, FL 33705 PH: 727-325-1100 FAX: 727-325-1101 WWW.GFYOUNG.COM																			
				Department of Environmental Protection Division of Recreation and Parks Bureau of Design and Construction 3800 Commonwealth Blvd., Tallahassee, FL 32399 (850) 245-2157																			


George F. Young, Inc.
290 DR. MARTIN LUTHER KING, JR. STREET, N. ST. PETERSBURG, FLORIDA 33701
REGISTERED PROFESSIONAL ENGINEER
FLORIDA LICENSE NO. 11000
SINCE 1919

Department of Environmental Protection
Division of Recreation and Parks
Bureau of Design and Construction
3800 Commonwealth Blvd., Tallahassee, FL 32399 (904) 245-2157

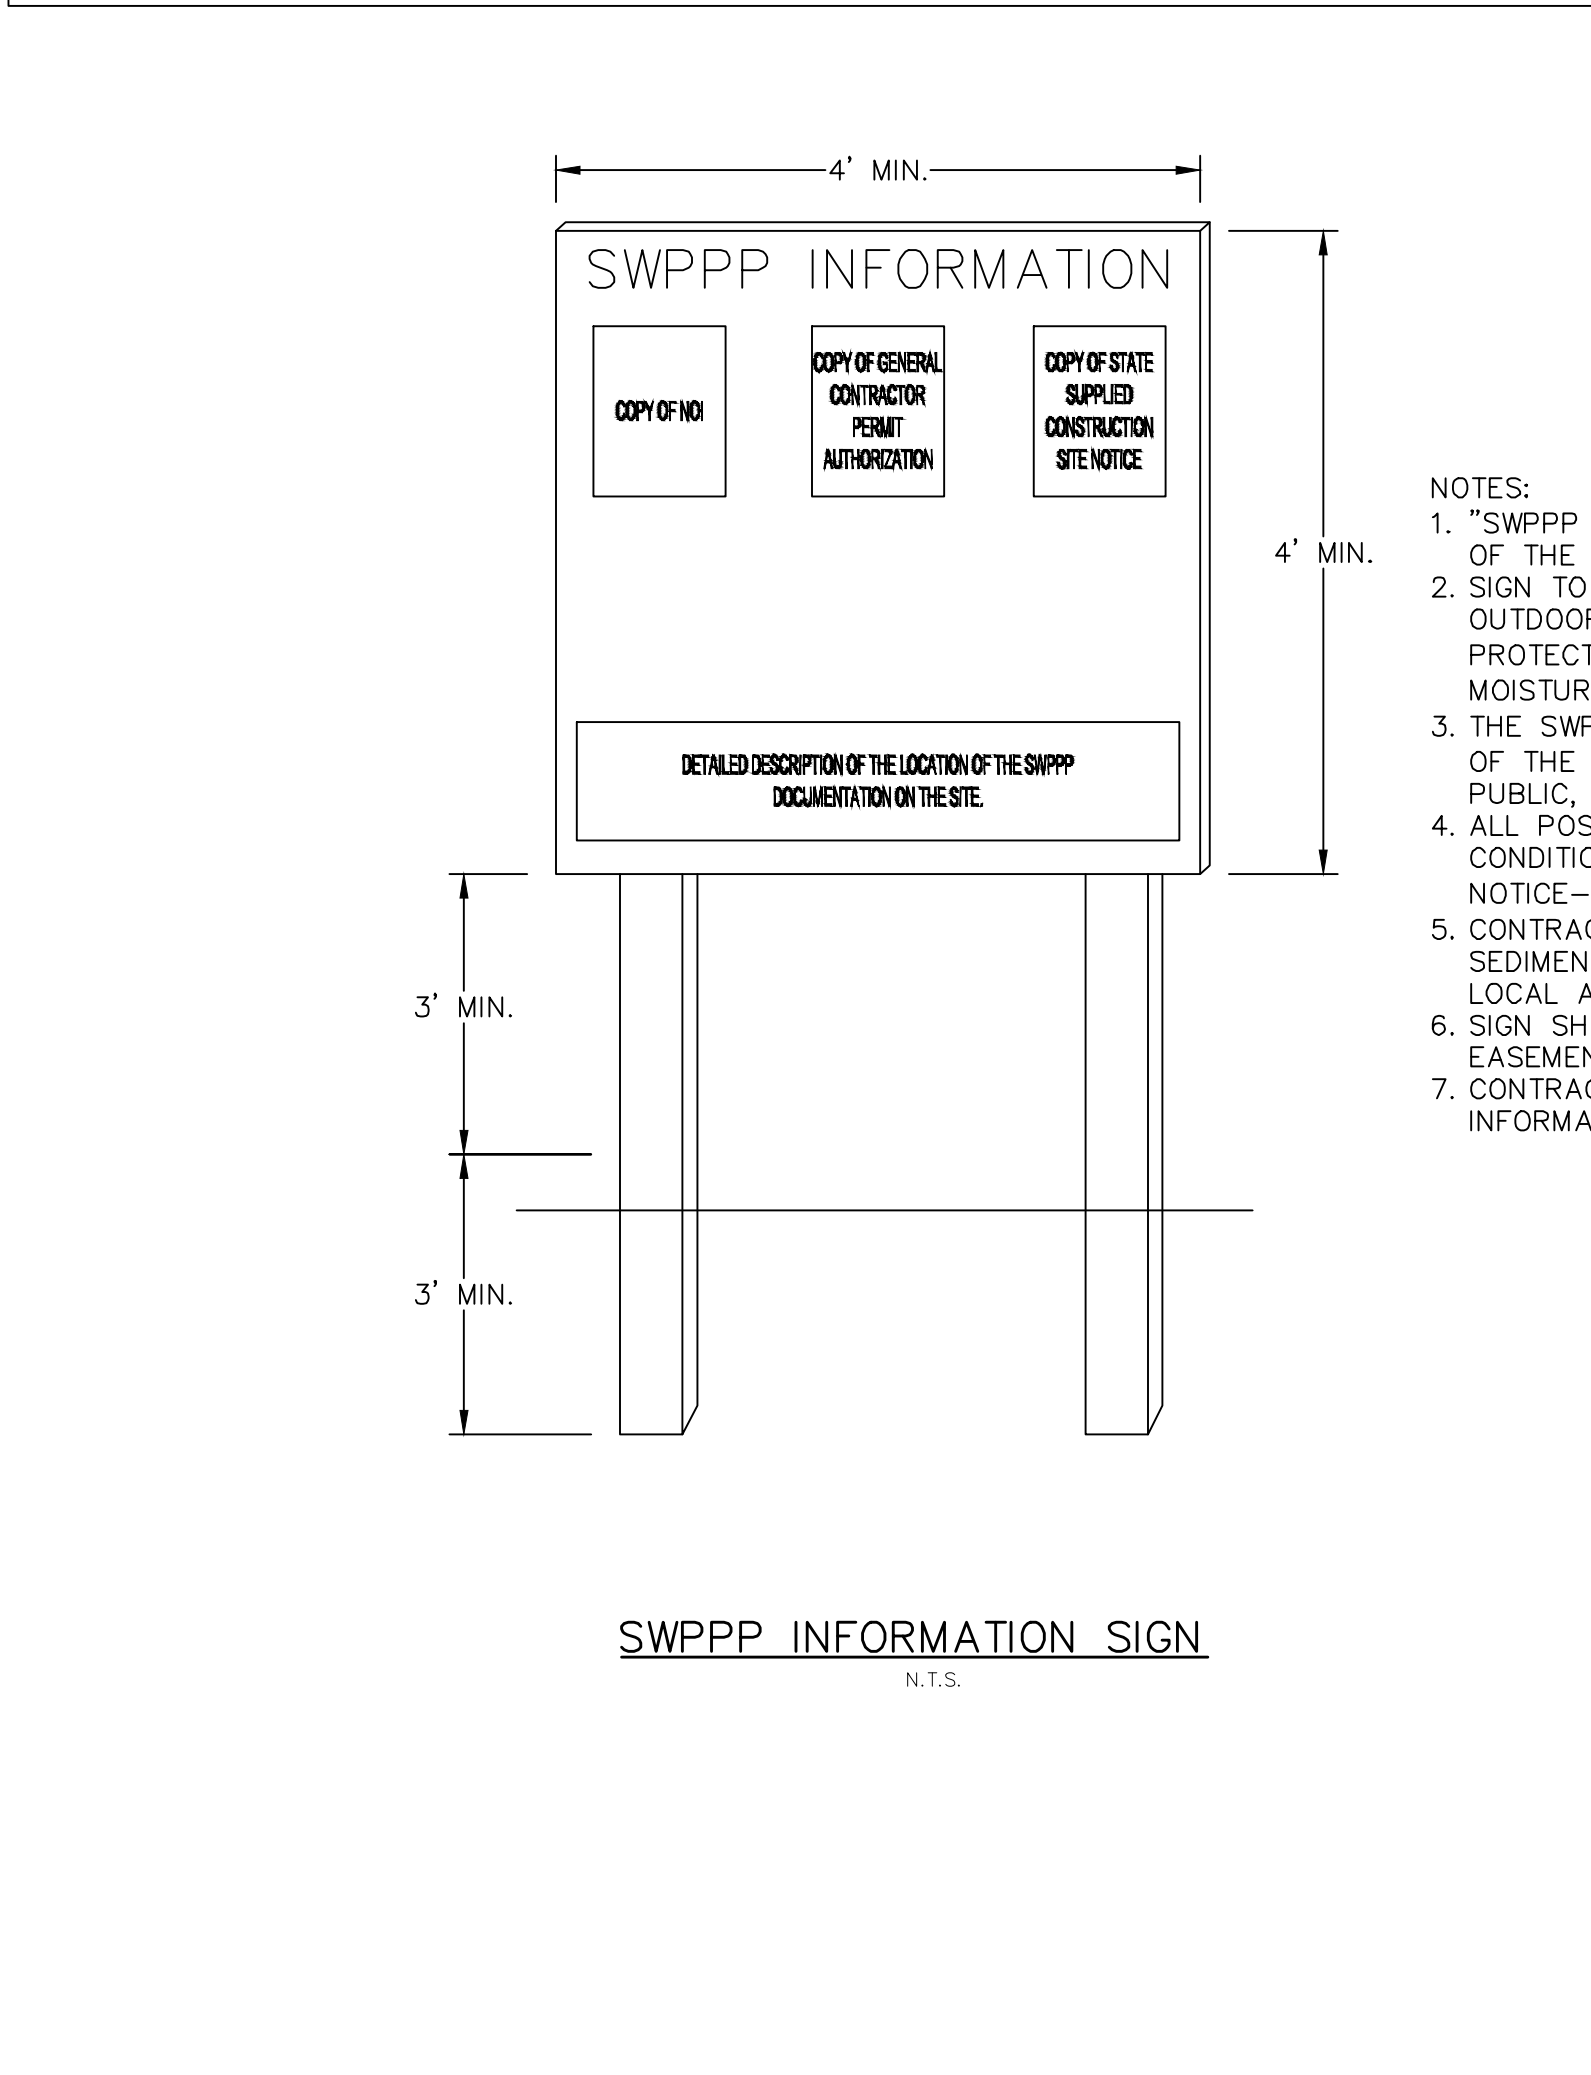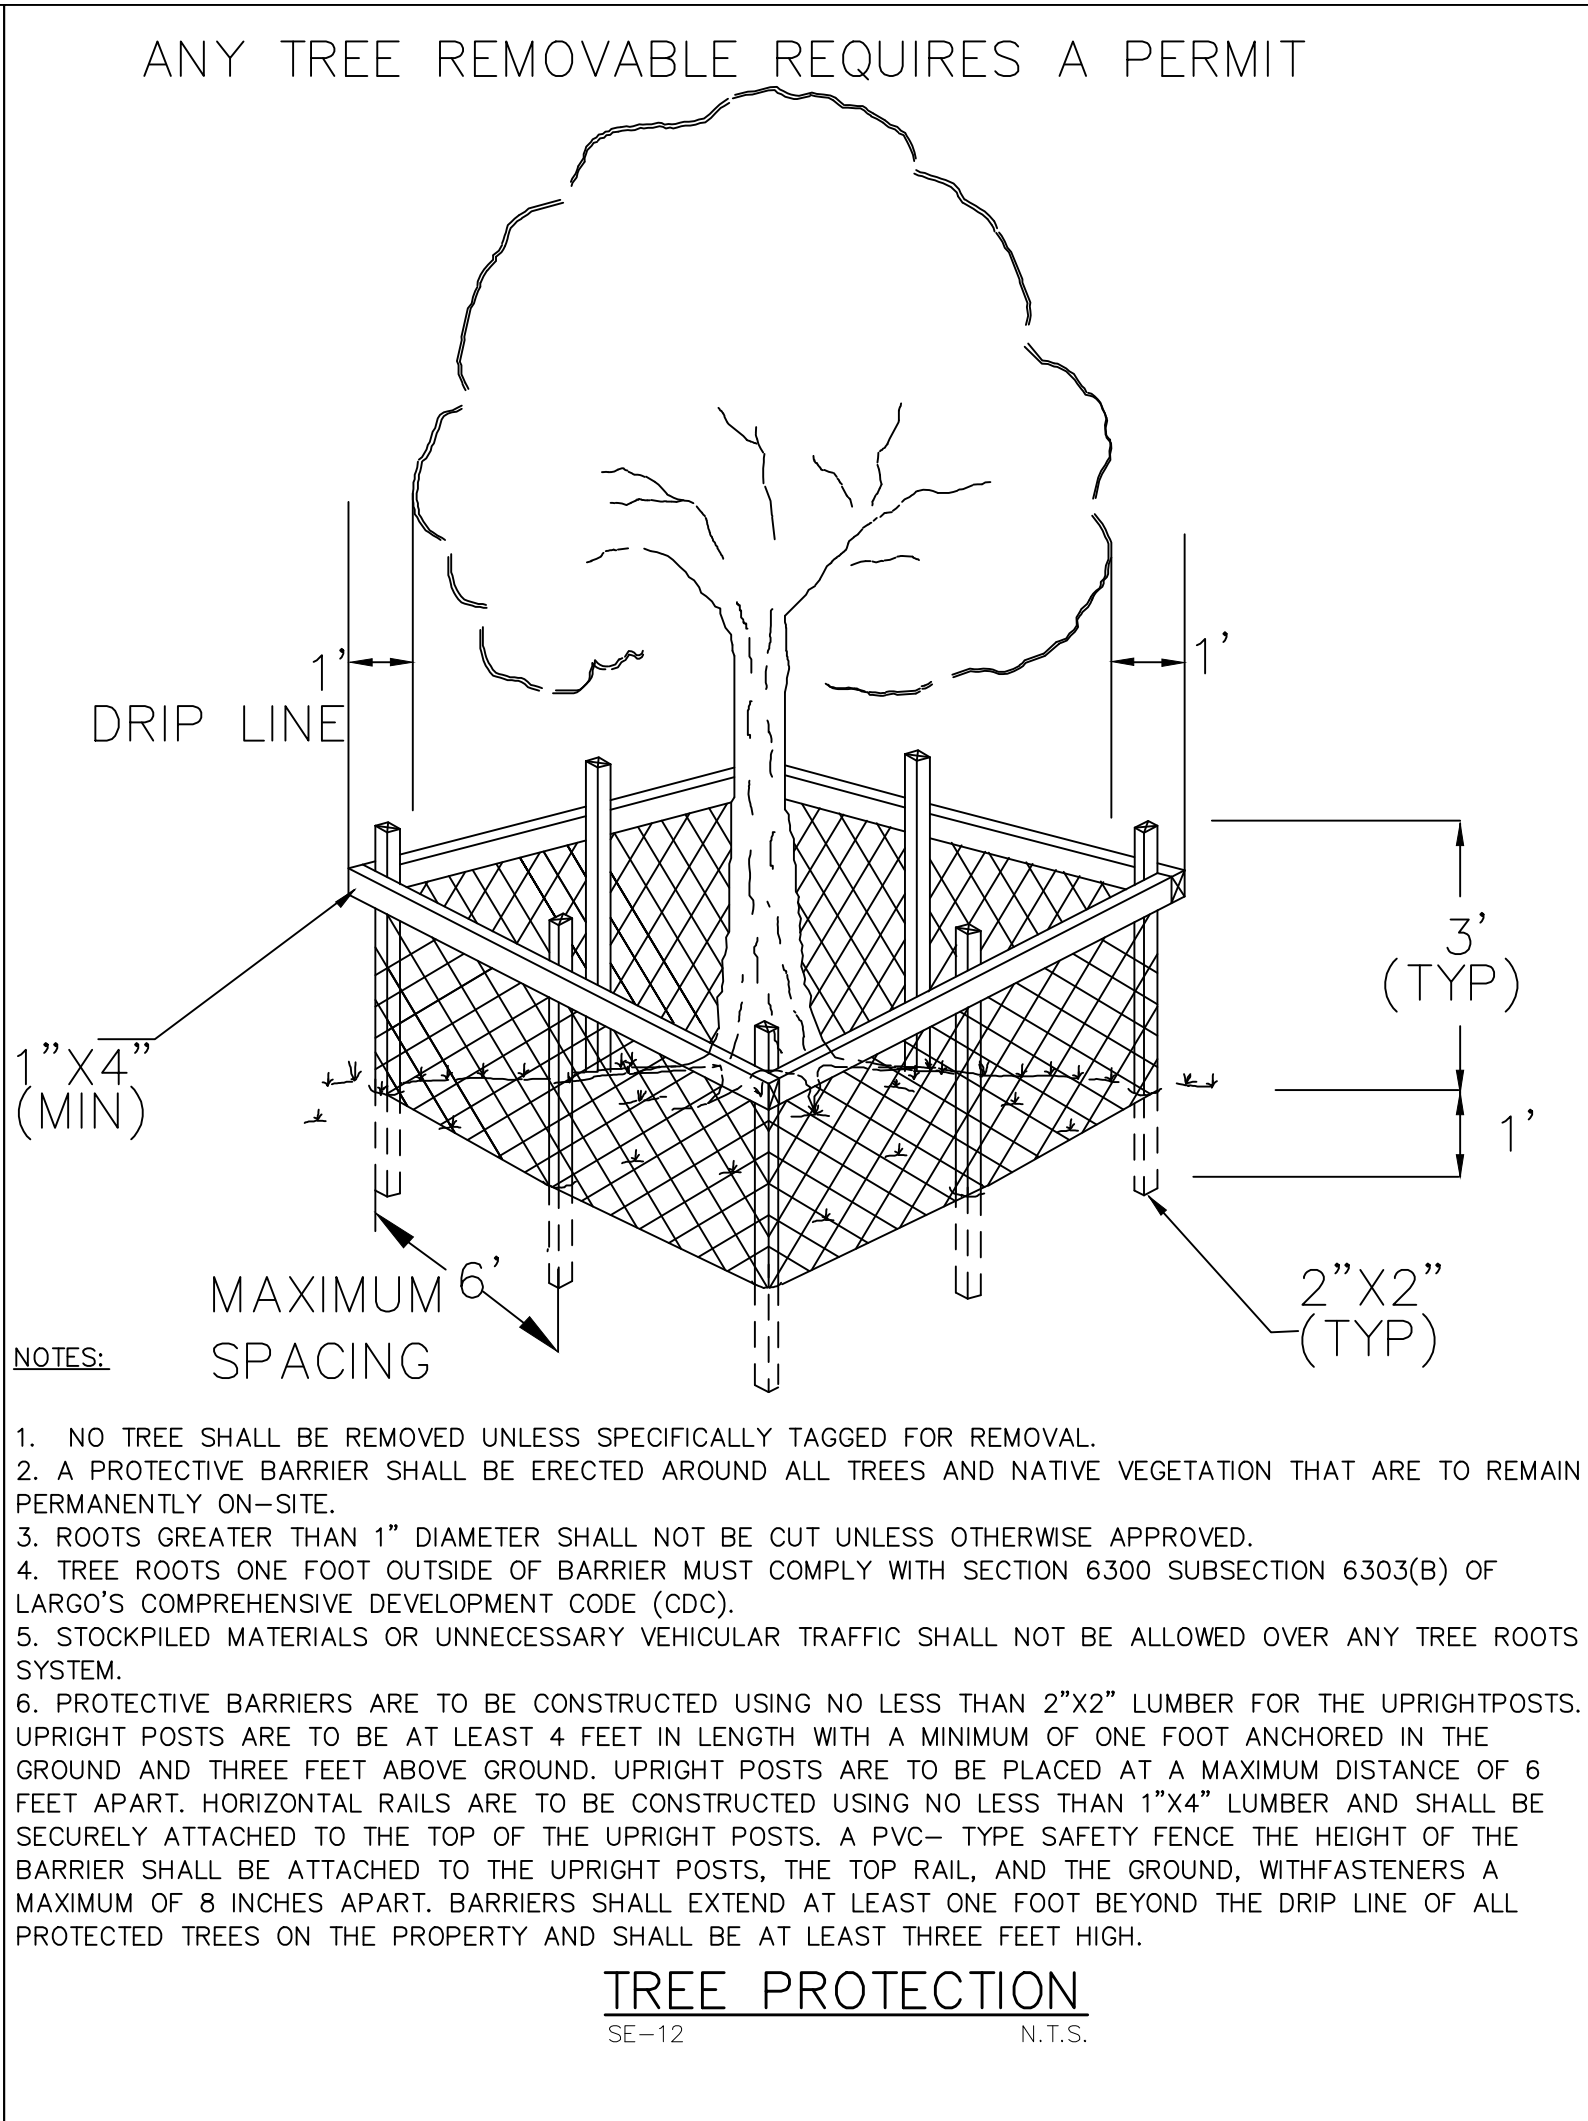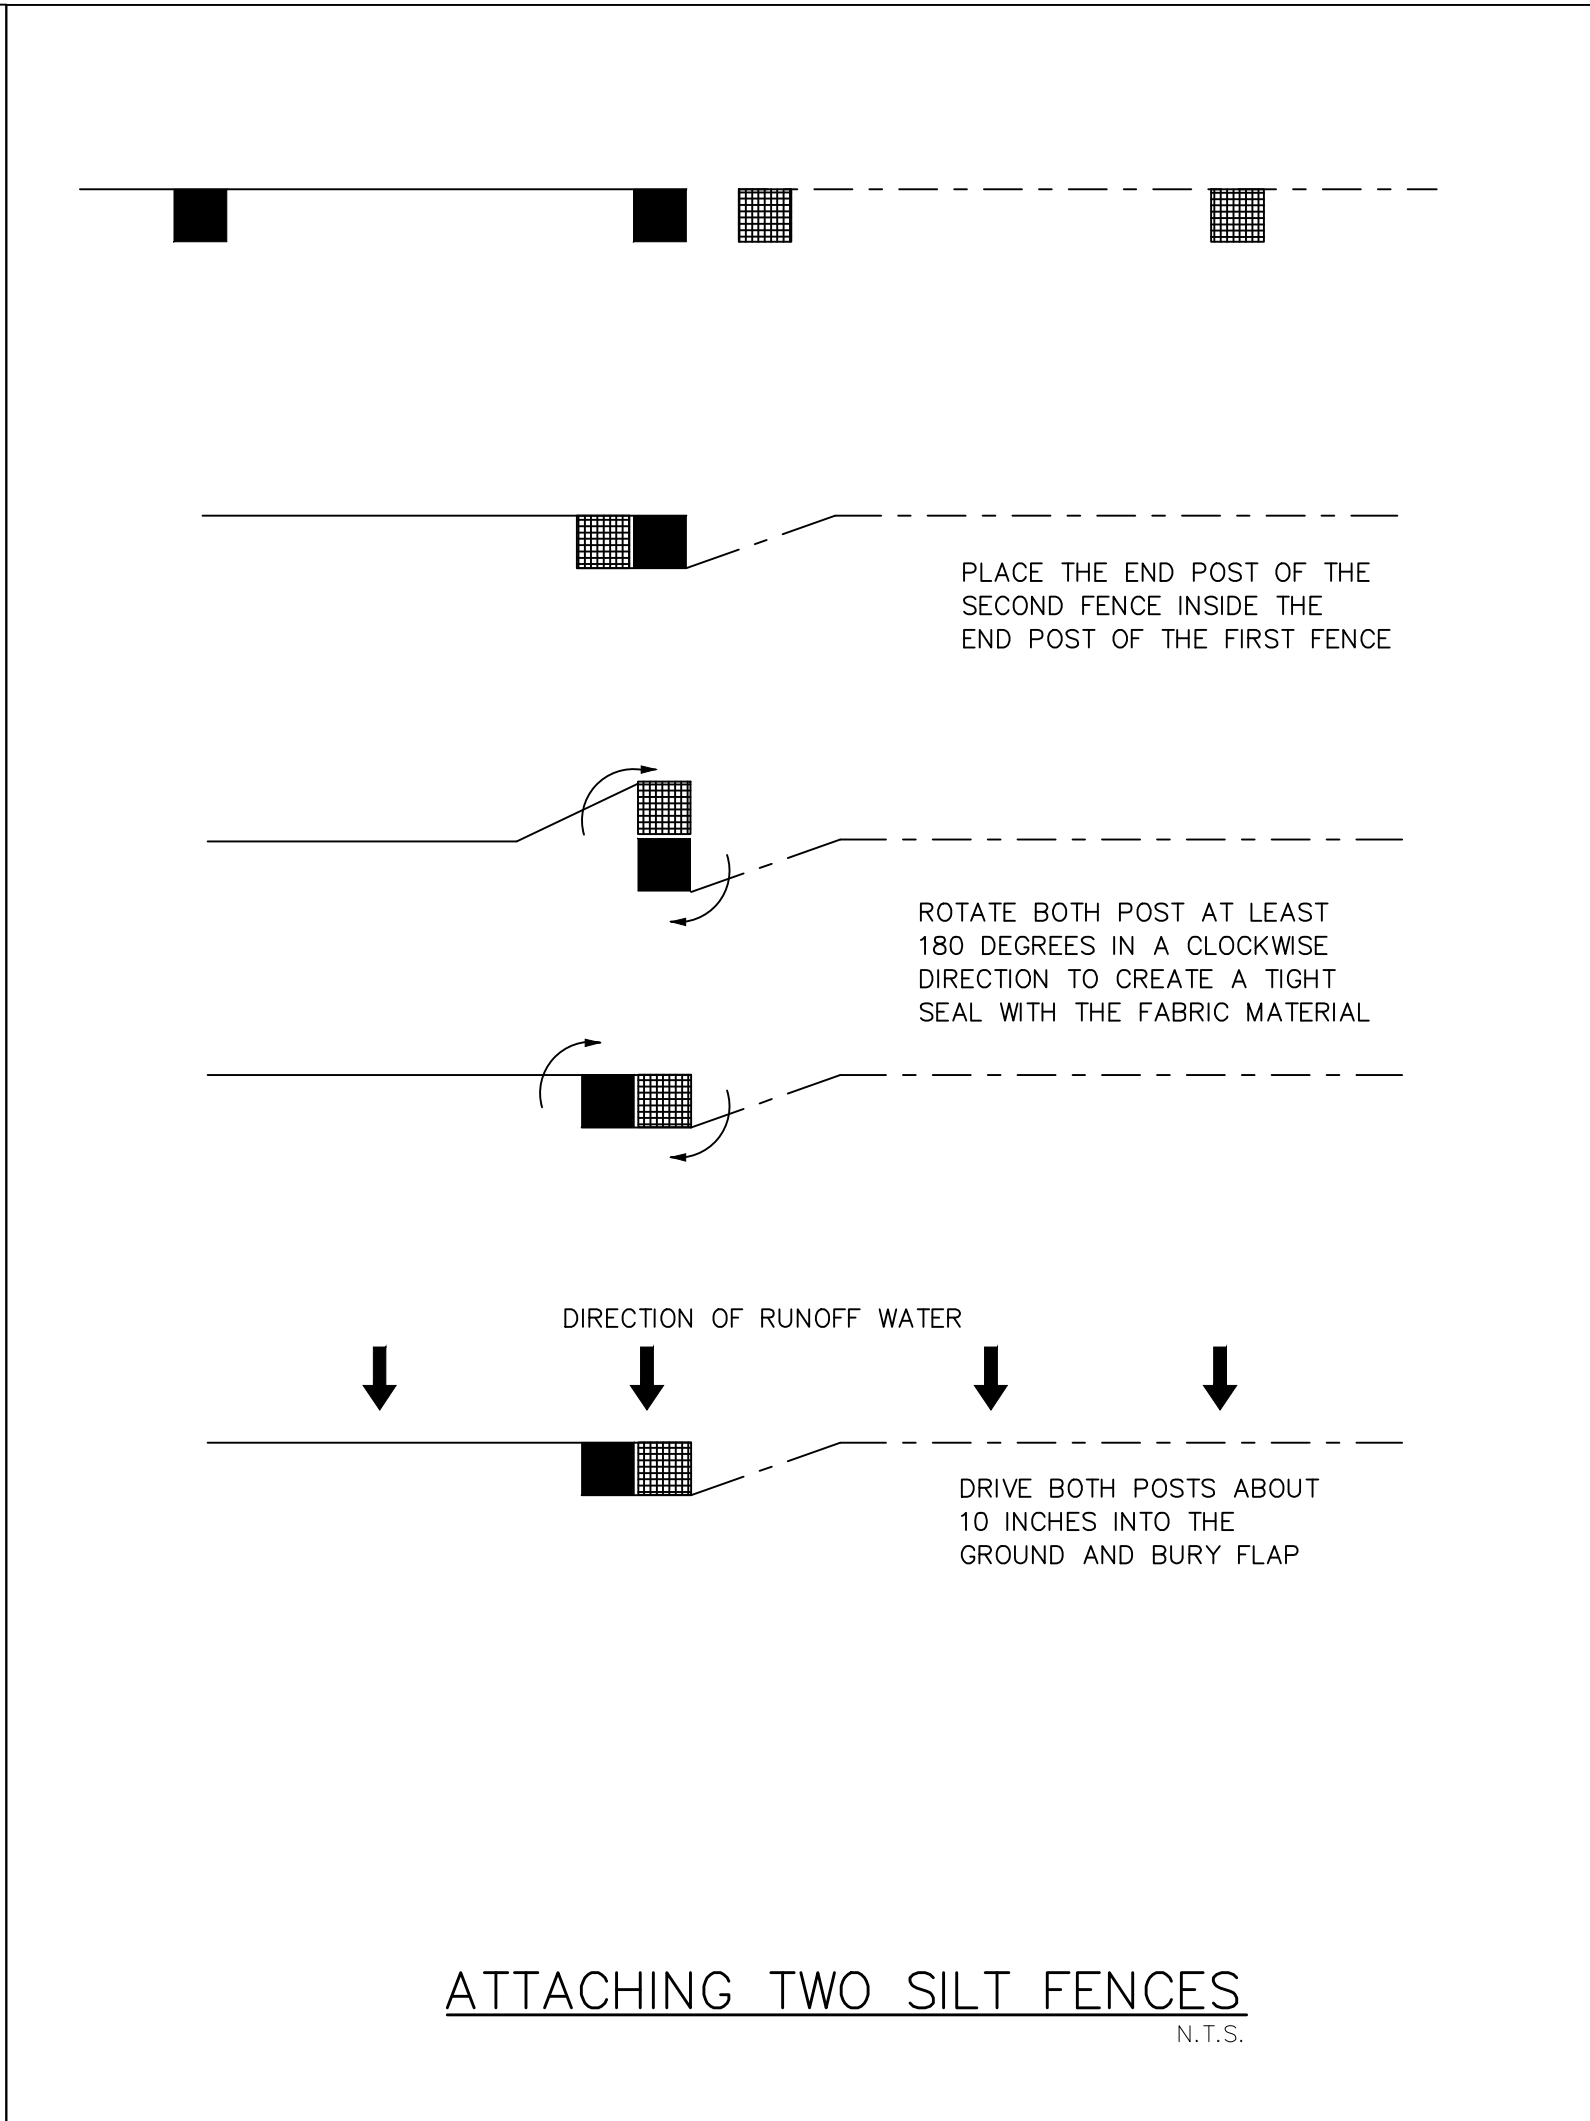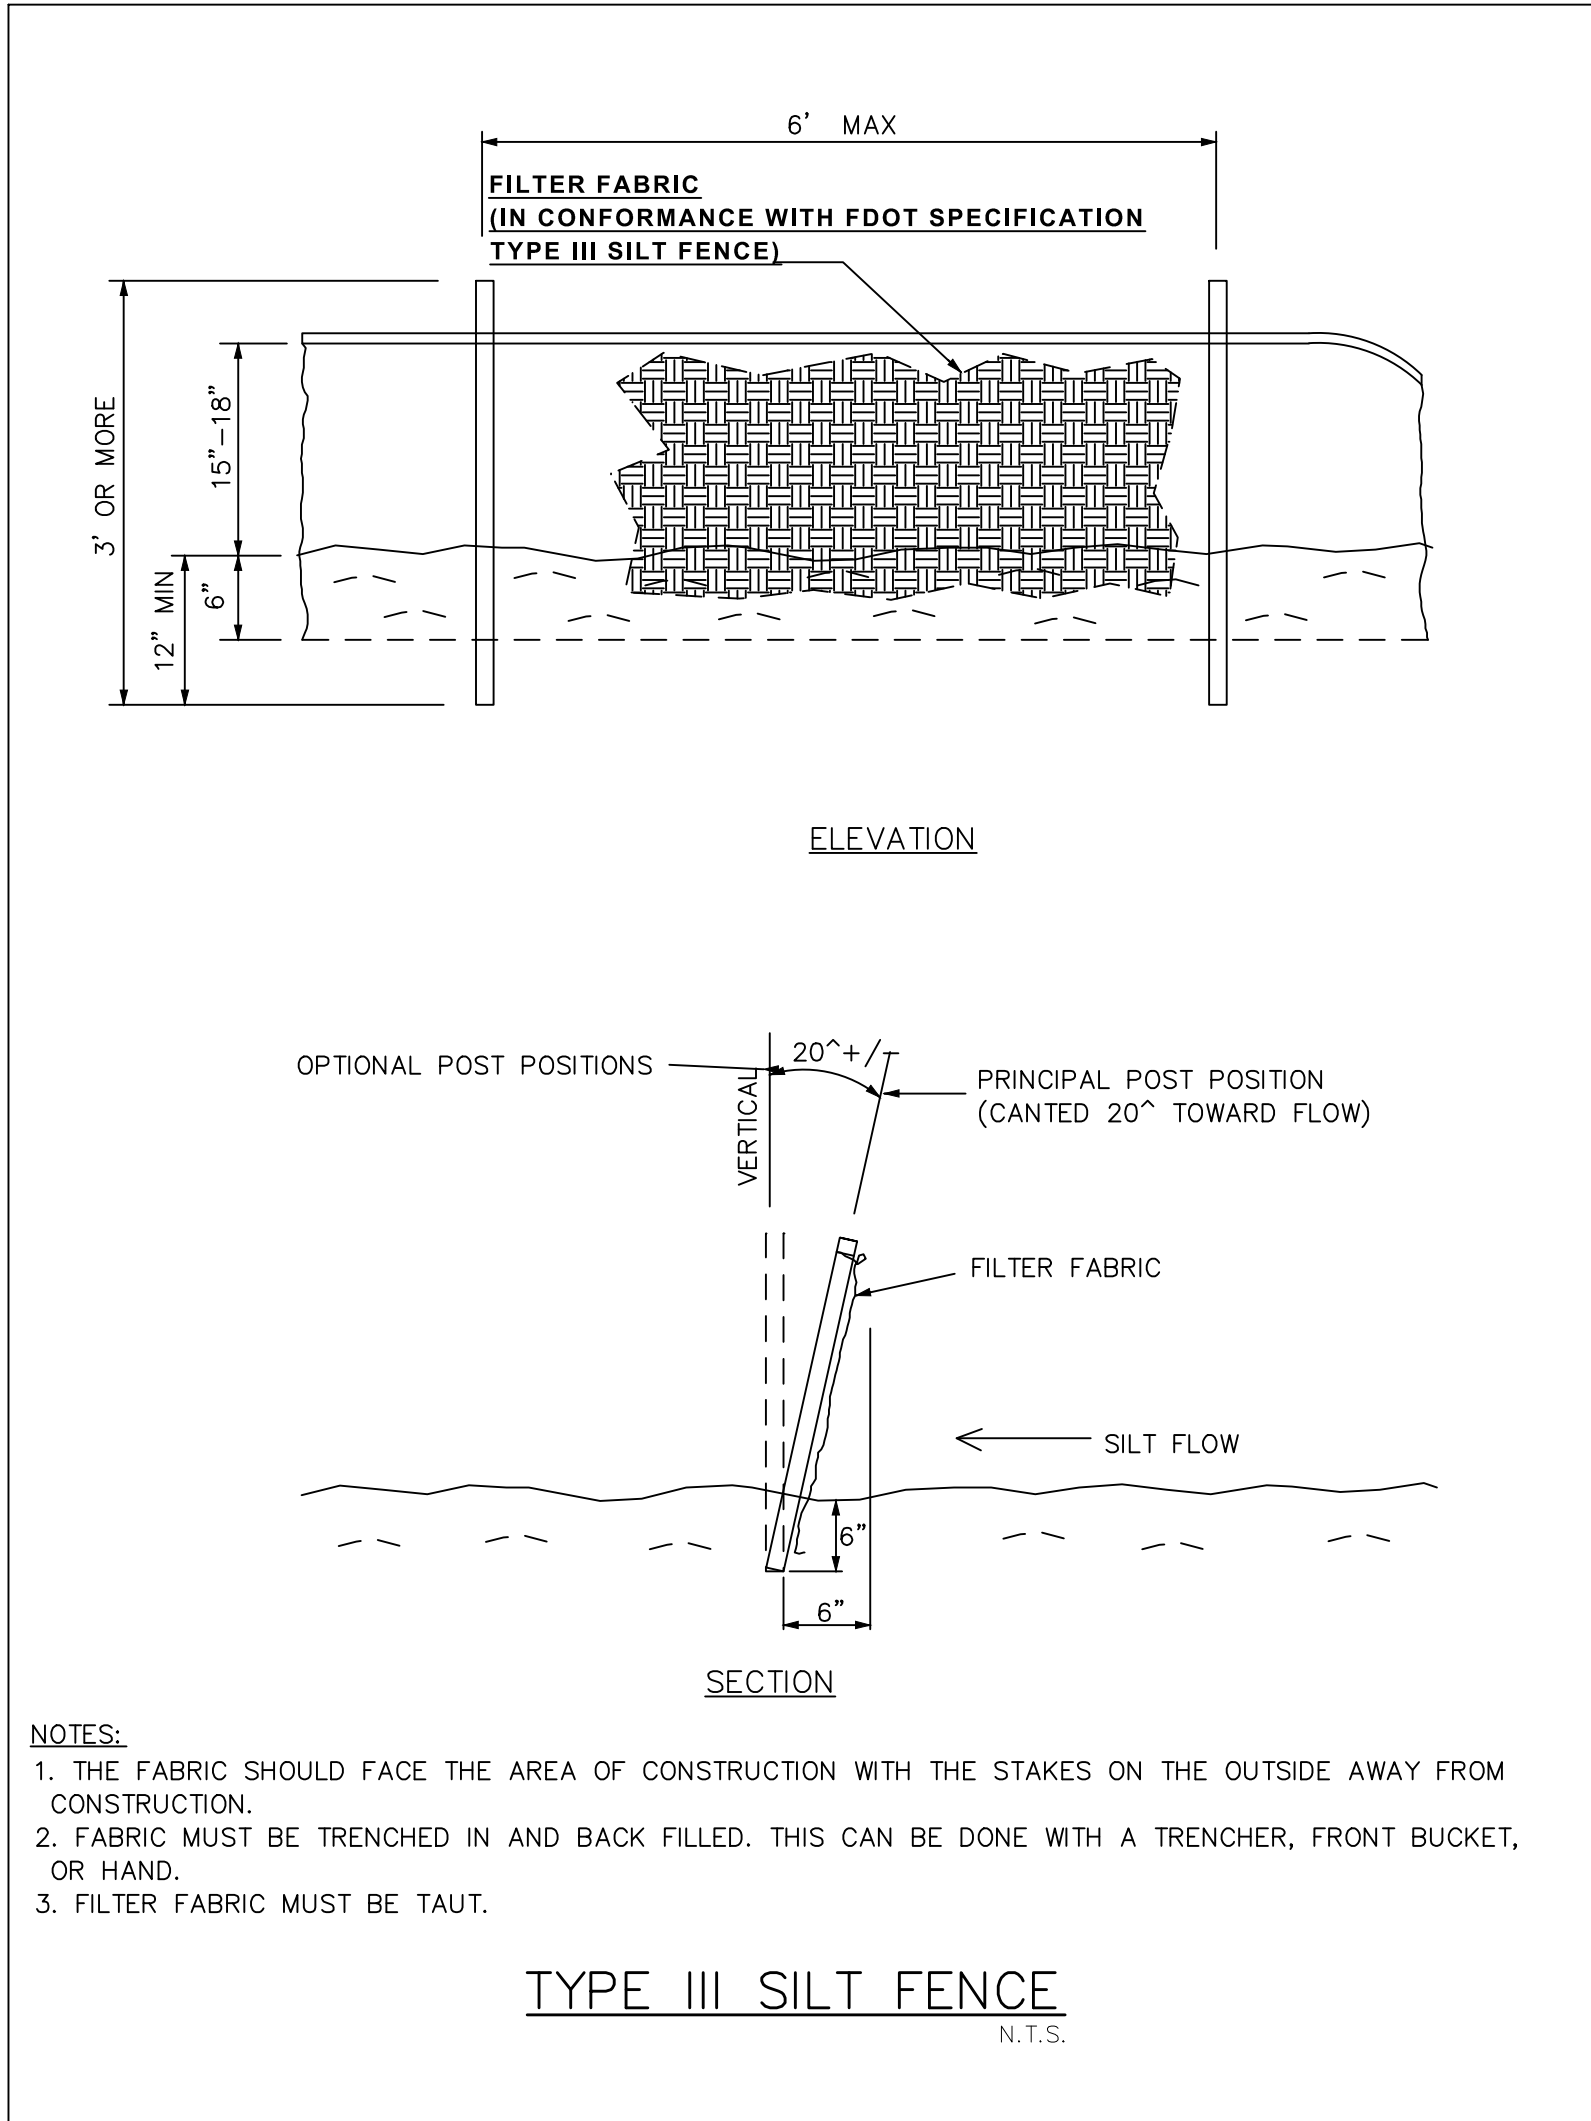

NOTES:

- "SWPPP INFORMATION" MUST BE DISPLAYED PROMINENTLY ACROSS THE TOP OF THE SIGN, AS SHOWN IN THE DETAIL.
- SIGN TO BE CONSTRUCTED OF A RIGID MATERIAL, SUCH AS PLYWOOD OR OUTDOOR SIGN BOARD. SIGN MUST BE CONSTRUCTED IN A MANNER TO PROTECT DOCUMENTS FROM DAMAGE DUE TO WEATHER (WIND, SUN, MOISTURE, ETC.).
- THE SWPPP INFORMATION SIGN MUST BE LOCATED NEAR THE ENTRANCE/EXIT OF THE SITE, SUCH THAT IT IS ACCESSIBLE/VIEWABLE BY THE GENERAL PUBLIC, BUT NOT OBSTRUCTING VIEWS AS TO CAUSE A SAFETY HAZARD.
- ALL POSTED DOCUMENTS MUST BE MAINTAINED IN A CLEARLY READABLE CONDITION AT ALL TIMES THROUGHOUT CONSTRUCTION AND UNTIL THE NOTICE-OF-TERMINATION (NOT) IS FILED FOR THE PERMIT.
- CONTRACTOR SHALL POST OTHER STORM WATER AND/OR EROSION AND SEDIMENT CONTROL RELATED PERMITS ON THE SIGN AS REQUIRED BY THE LOCAL AGENCY.
- SIGN SHALL BE LOCATED OUTSIDE OF PUBLIC RIGHT-OF-WAY AND EASEMENTS UNLESS APPROVED BY THE GOVERNING AGENCY.
- CONTRACTOR IS RESPONSIBLE FOR ENSURING STABILITY OF THIS SWPPP INFORMATION SIGN.

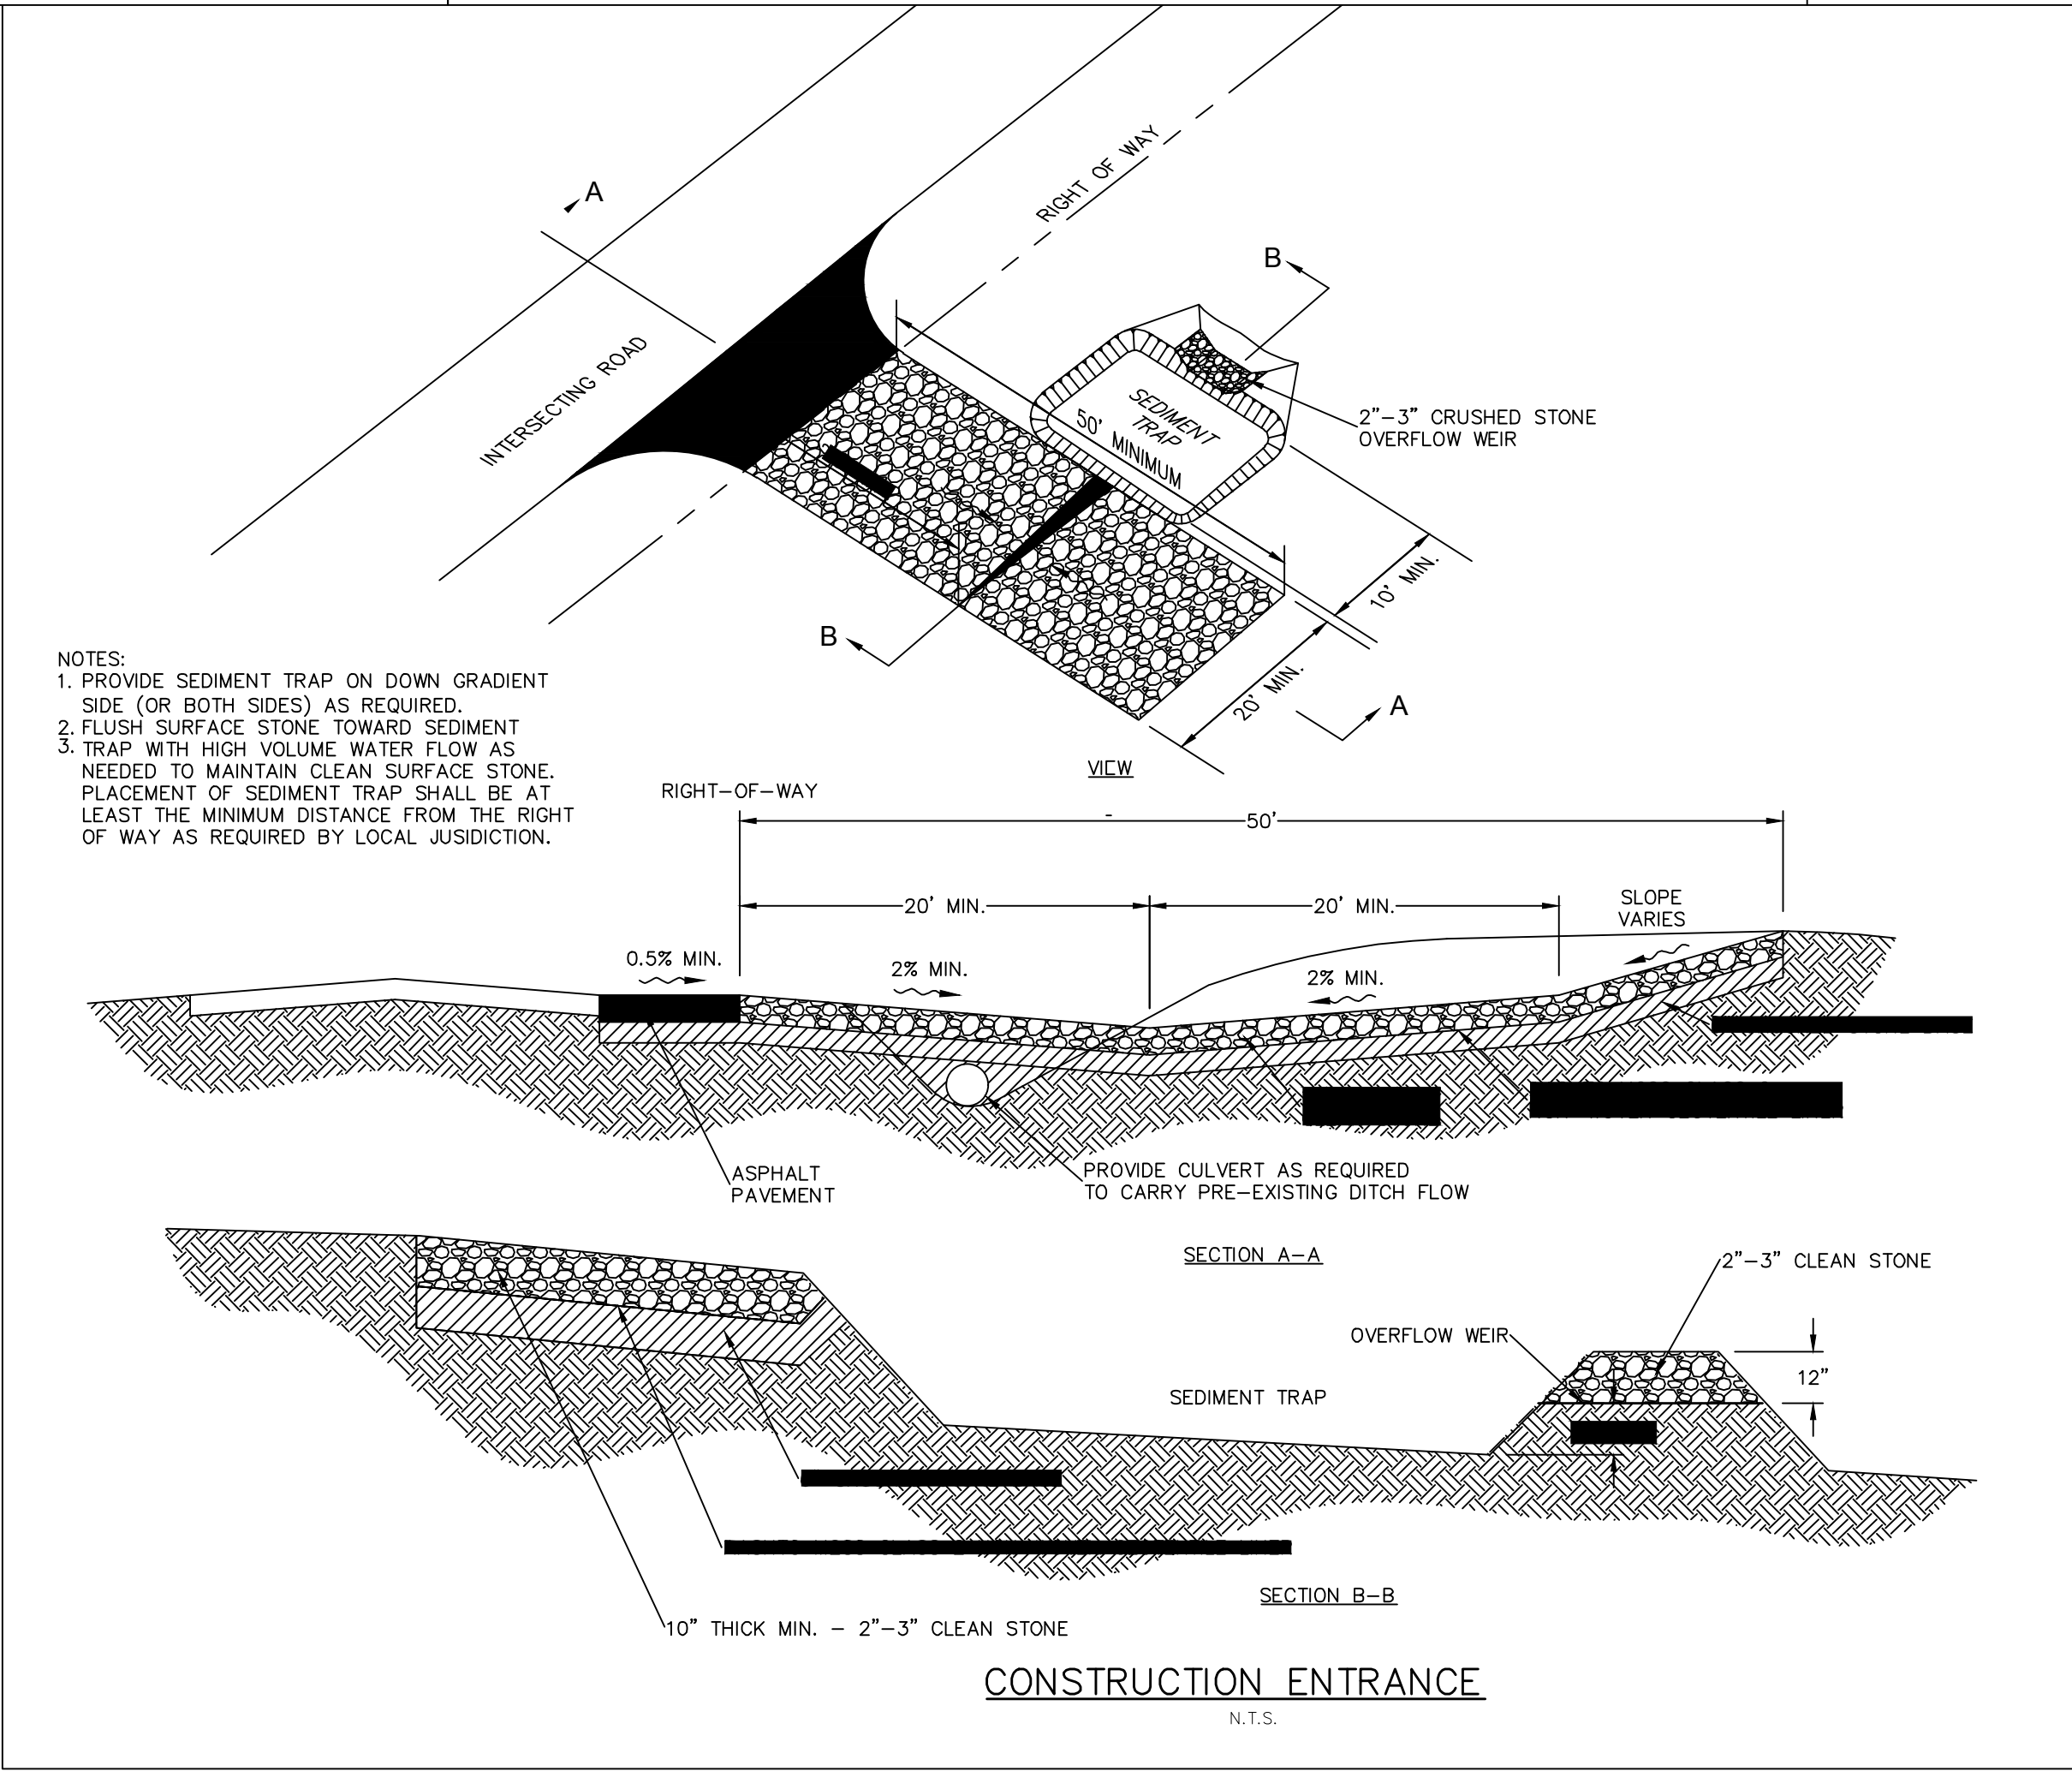

DESIGNER :	ISSUE DATE:	SYMBOL	REVISION	DATE	SYMBOL	REVISION	DATE
DRAWN BY:	COMP. FILE NO.:	A			C		
REVIEWED BY:	STATE PROJECT No.:	B			U		
Consultant :							
PROFESSIONAL REGISTRATION							
SHEET TITLE				EROSION CONTROL DETAILS			
PROJECT TITLE				BLUE SPRING STATE PARK RESTROOM REPLACEMENT			
SHEET NO.				C500			

George F. Young, Inc.
290 DR. MARTIN LUTHER KING, JR. STREET, N.E. ST. PETERSBURG, FLORIDA 33701
FLORIDA PROFESSIONAL ENGINEERING CERTIFICATE OF AUTHORIZATION NUMBER 11111
CHANGING ADDRESS: 11111 FLORIDA AVENUE, SUITE 11111, ST. PETERSBURG, FLORIDA 33701
SINCE 1919

Department of Environmental Protection
Division of Recreation and Parks
Bureau of Design and Construction
3800 Commonwealth Blvd., Tallahassee, FL 32399 (850) 245-2157

