
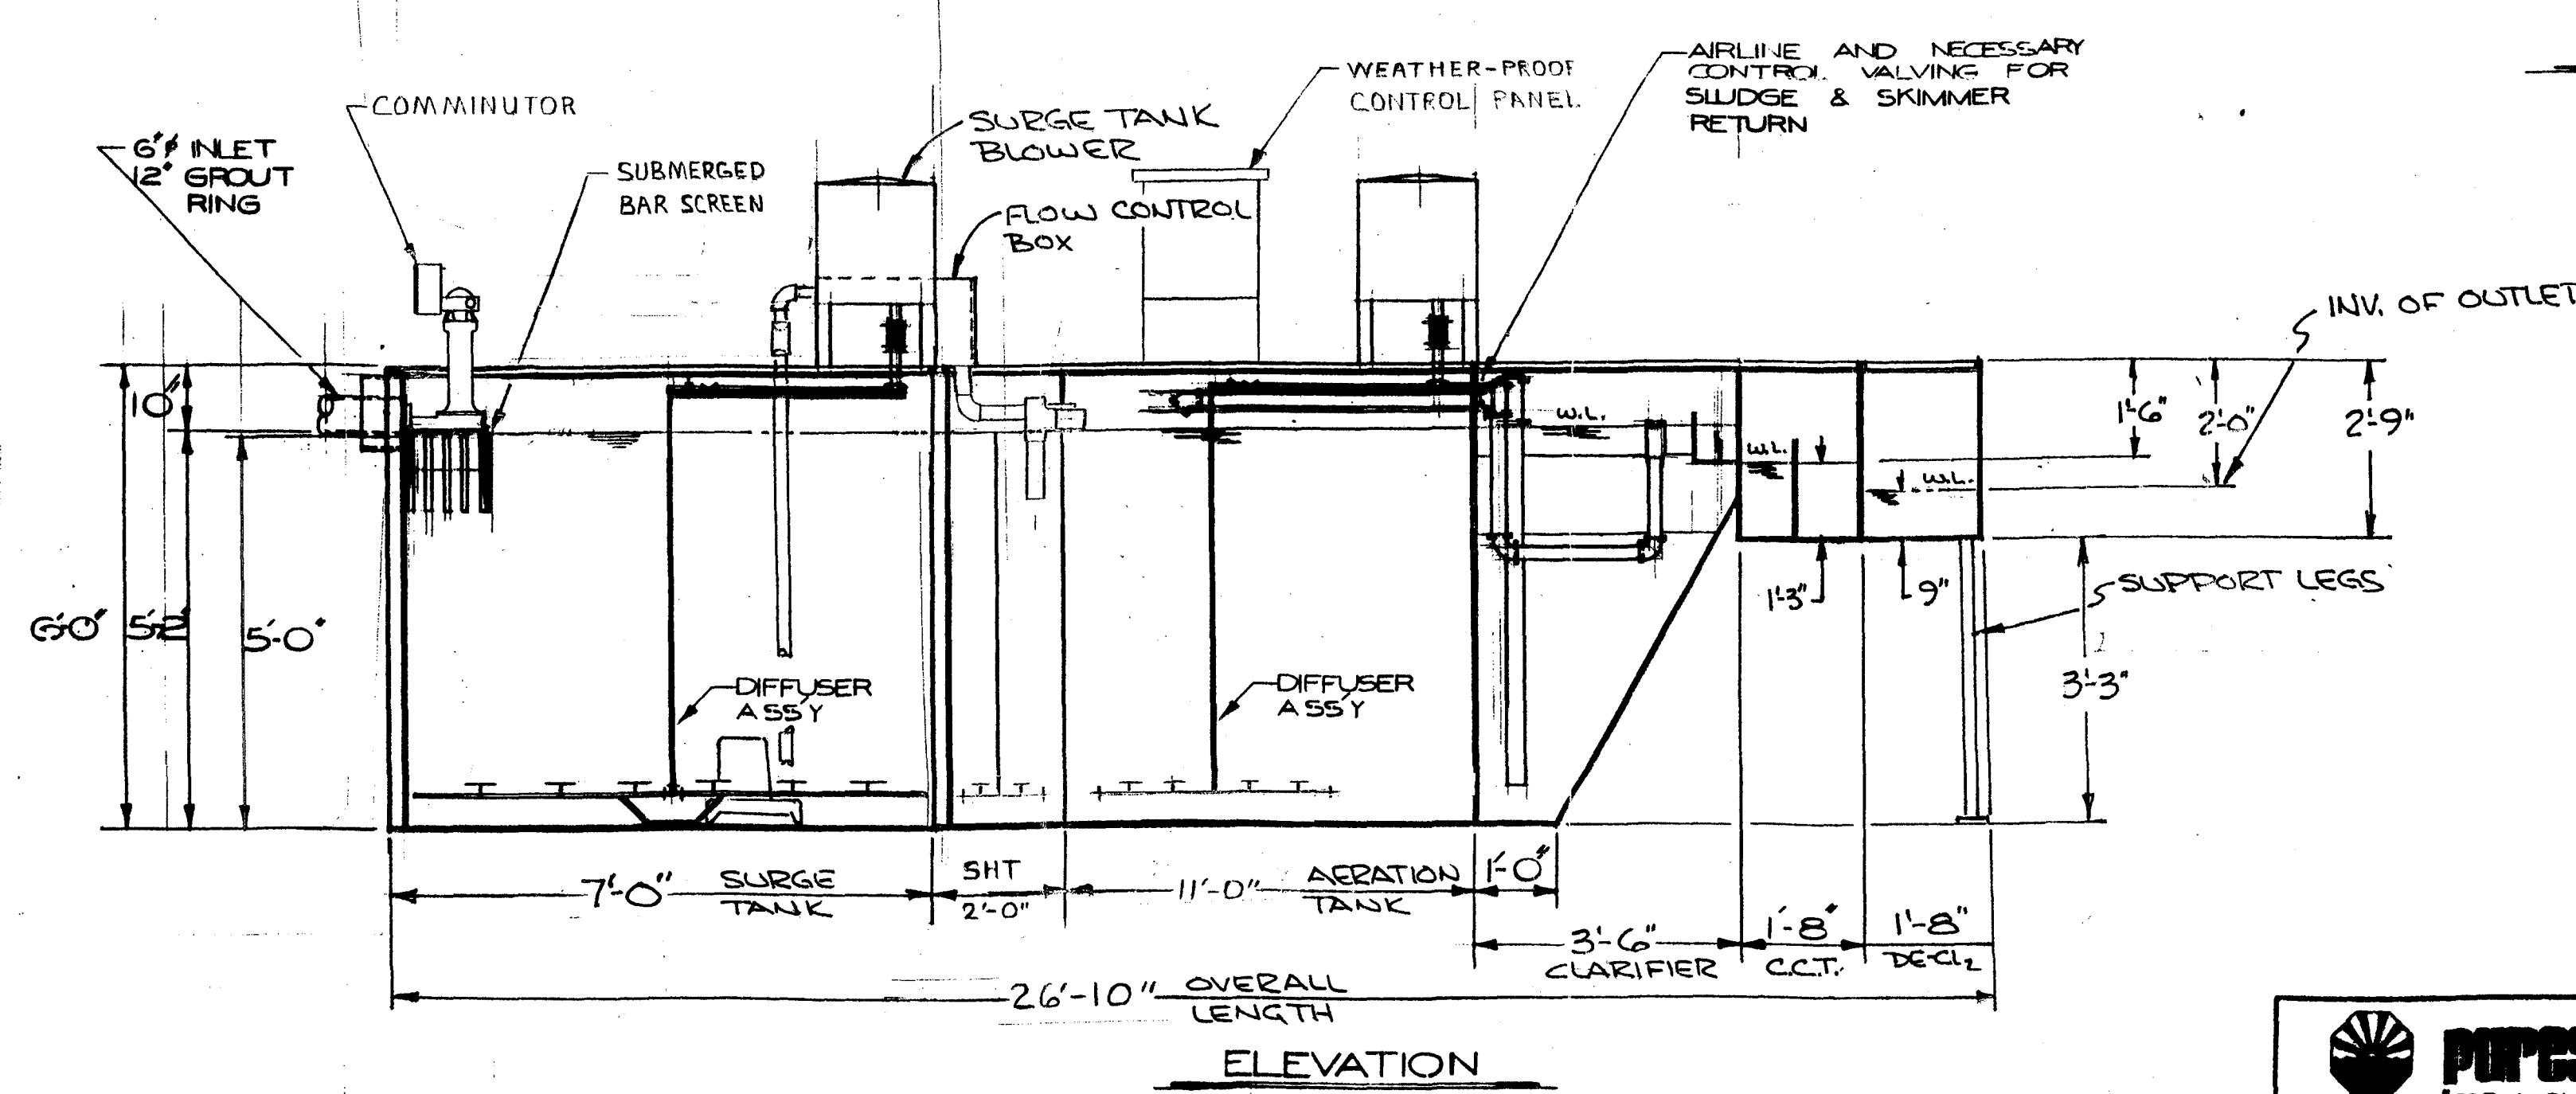
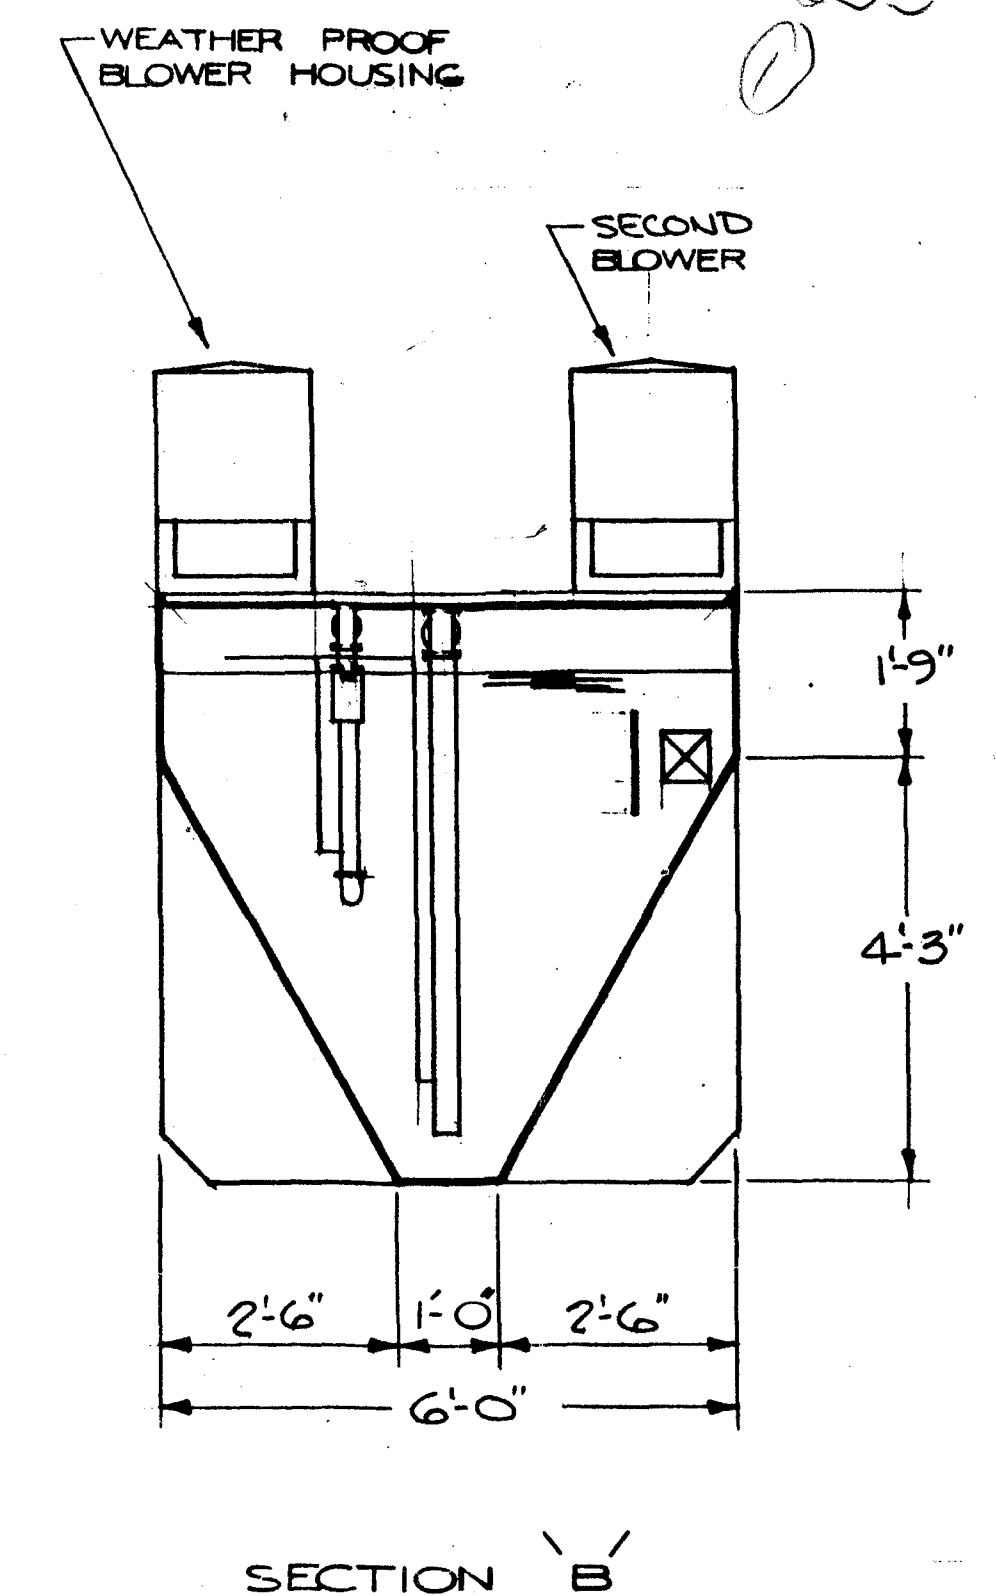


1065633
①

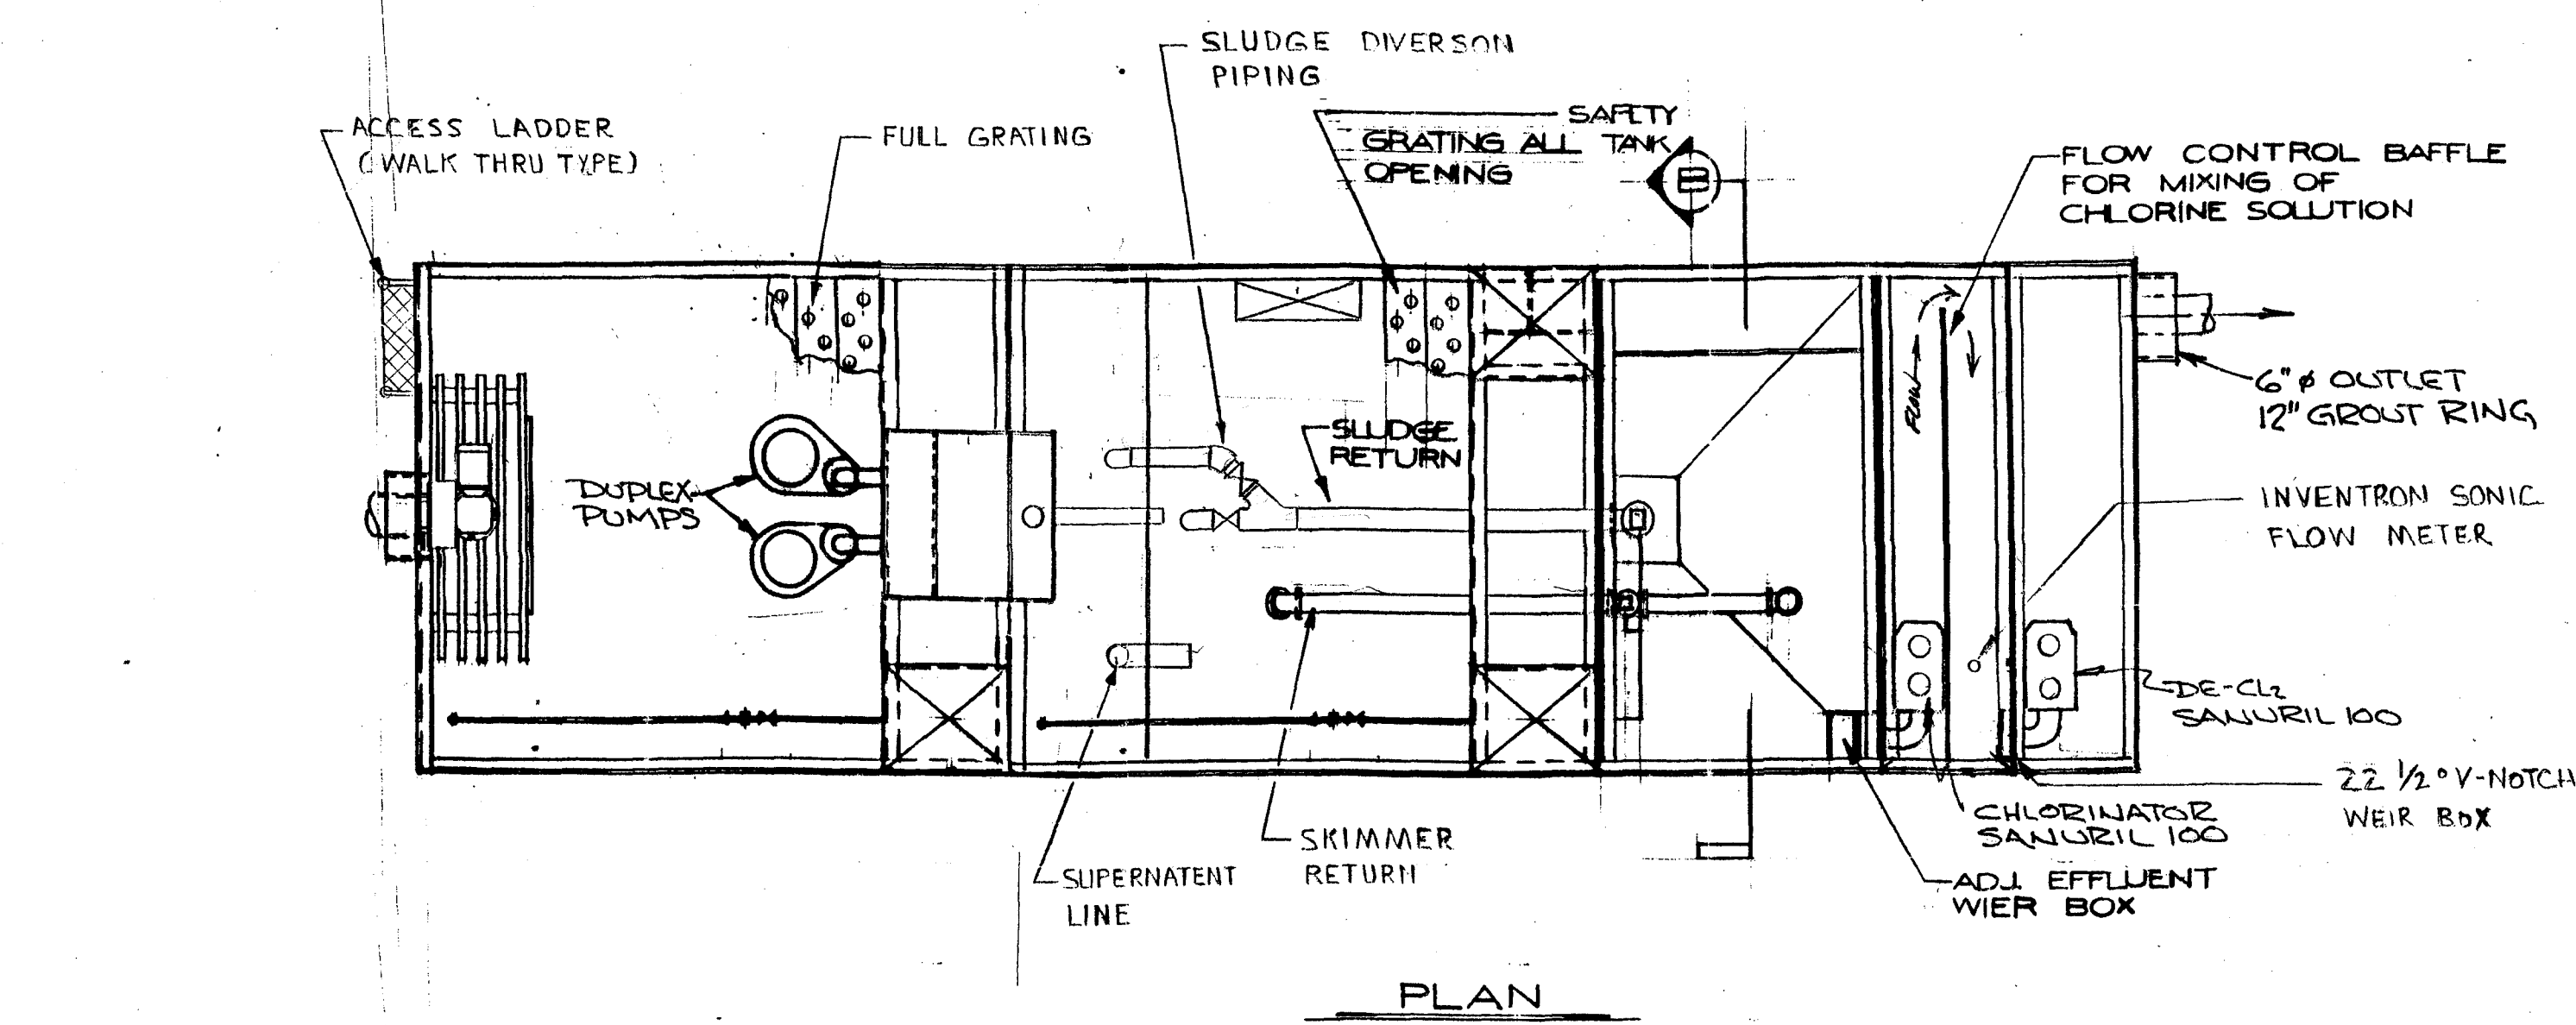

- NOTES:
- (1) BLOWER HOUSINGS ARE FIBERGLASS
 - (2) CONTROL PANEL IS NEMA 4X FIBERGLASS
 - (3) POWER SUPPLY IS 208 V, 3 PH, 60 HZ.
 - (4) TANKAGE SHALL BE PAINTED WITH COAL TAR EPOXY

MODEL NUMBER	FLOW G.P.D.	AERATION TANK VOL.	SURGE TANK VOL.	C.C.T. VOL.	DE-CL ₂ VOL.	SHT VOL.
PT-25-1	2500	2500	1000	52 GALS	52 GALS	448 GALS

FIGURE 1

 pipestream inc. "FOR A CLEAN WATER WORLD"		PROJECT NAME GULF POWER PLANT		
		PROJECT NUMBER 0148		
PREFABRICATED STEEL SEWAGE TREATMENT PLANT 3 16 STEEL PLATE		REVISED	DATE	SCALE: NONE
		MSD	12-14-92	DATE: 7-22-92
		MSD	12-28-92	DRAWN: KOWENS
		MSD	1-15-93	
		MSD	1-21-93	
GENERAL DETAIL		AP'VD.		
		DRAWING NUMBER EA-2.5-1-X		