


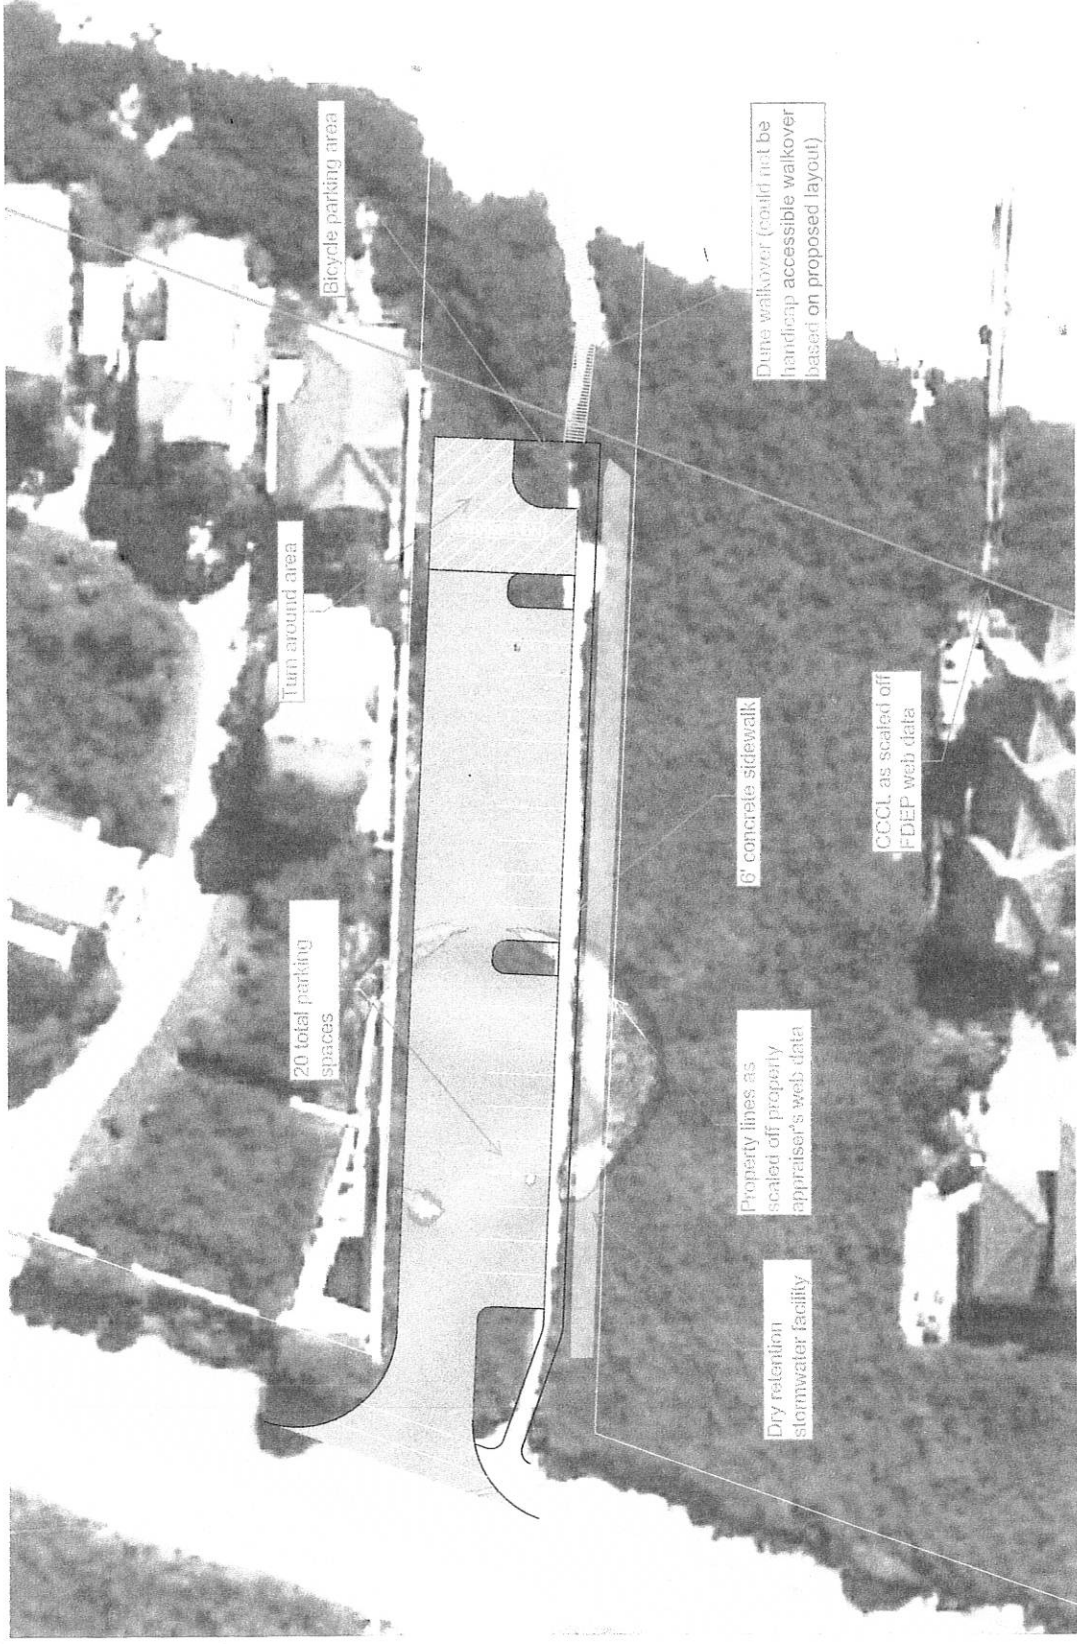

BRANDON C. POWELL FL. PE No. 60818		PREBLE-RISH, INC. CONSULTING ENGINEERS CIVIL • SURVEYING • SITE PLANNING 1001 S. GULF BLVD., SUITE 200 PENSACOLA, FL 32509 (904) 277-7700	PROJECT NO. 719,000 SCALE: DRAWN: CHECKED: SHEET 1
	Montigo Ave Conceptual Layout South Walton TDC		