


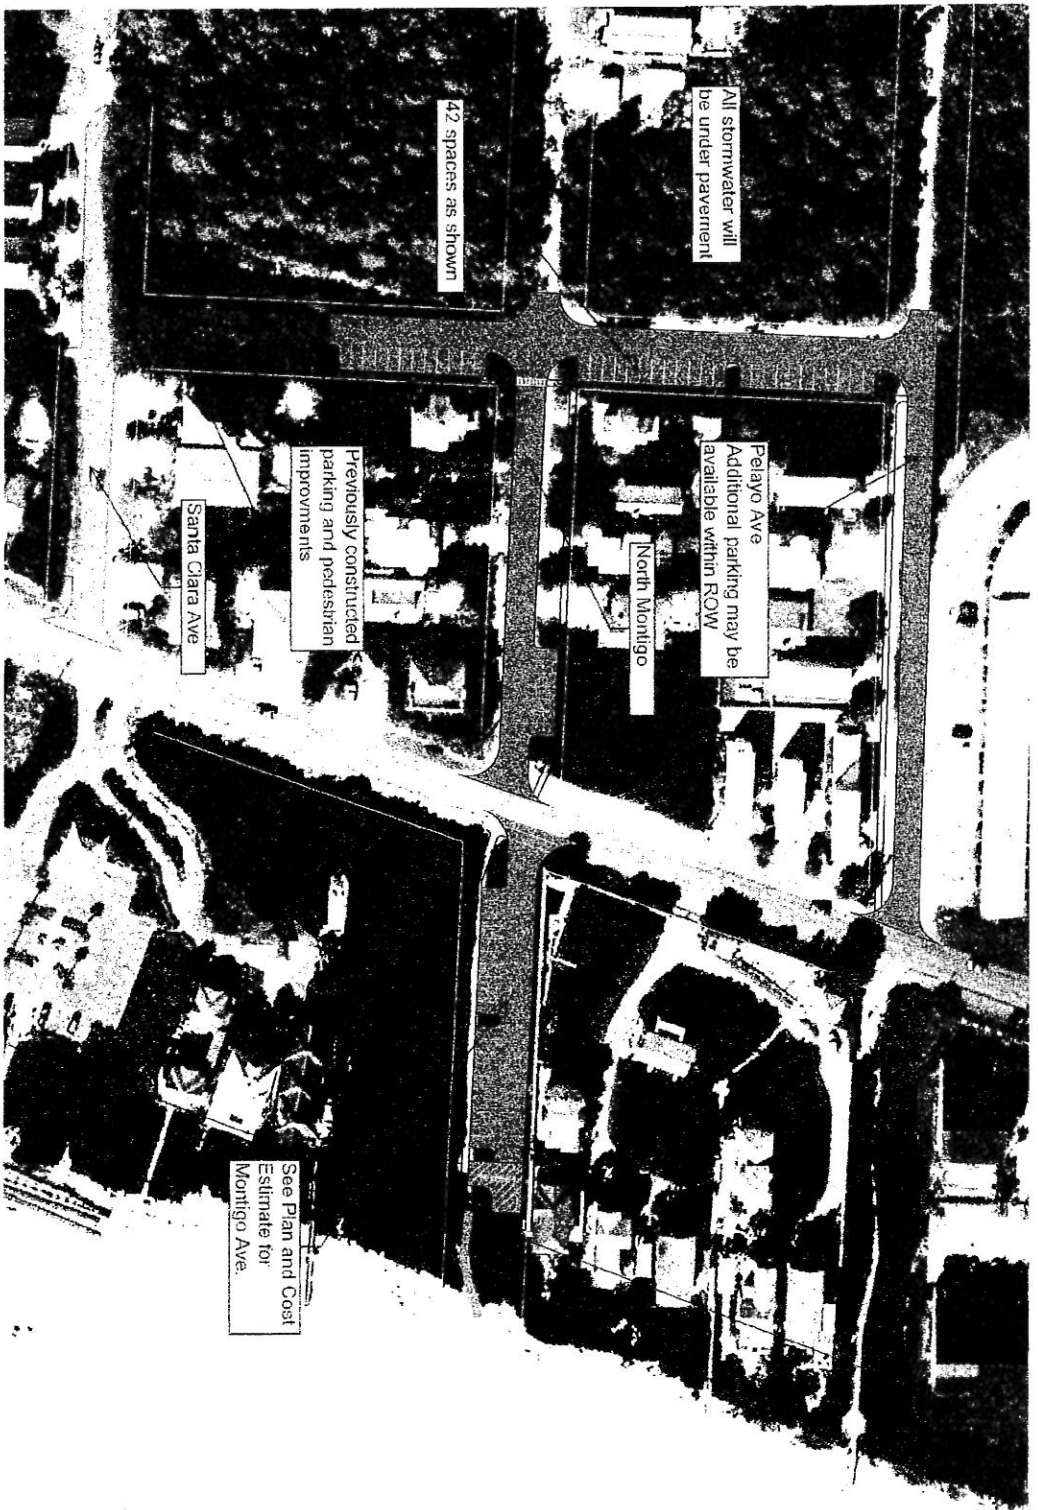

NO.	DATE	BY
1		
2		
3		
4		
5		

PREBLE-RISH, INC.
CONSULTING ENGINEERS
CIVIL • SURVEYING • SITE PLANNING
2010 W. 10th Street, Suite 100
Bismarck, ND 58102-1000
701.223.1234
FAX 701.223.1235
WWW.PREBLE-RISH.COM

Montigo, Santa Clara, and Pelajo Ave Area Conceptual Layout
South Walton TDC
DATE: 10/15/15
PROJECT NO.: 719.000
DRAWN: J. POWELL
CHECKED: J. POWELL
SHEET: 1