


December 17, 2014 (15:04:56 EST)
K:\248.120 CHERI LANE RESTORE STORMWATER\CIVIL3D\FOLDER_EXHIBITS\248120-EXHIBIT A.DWG

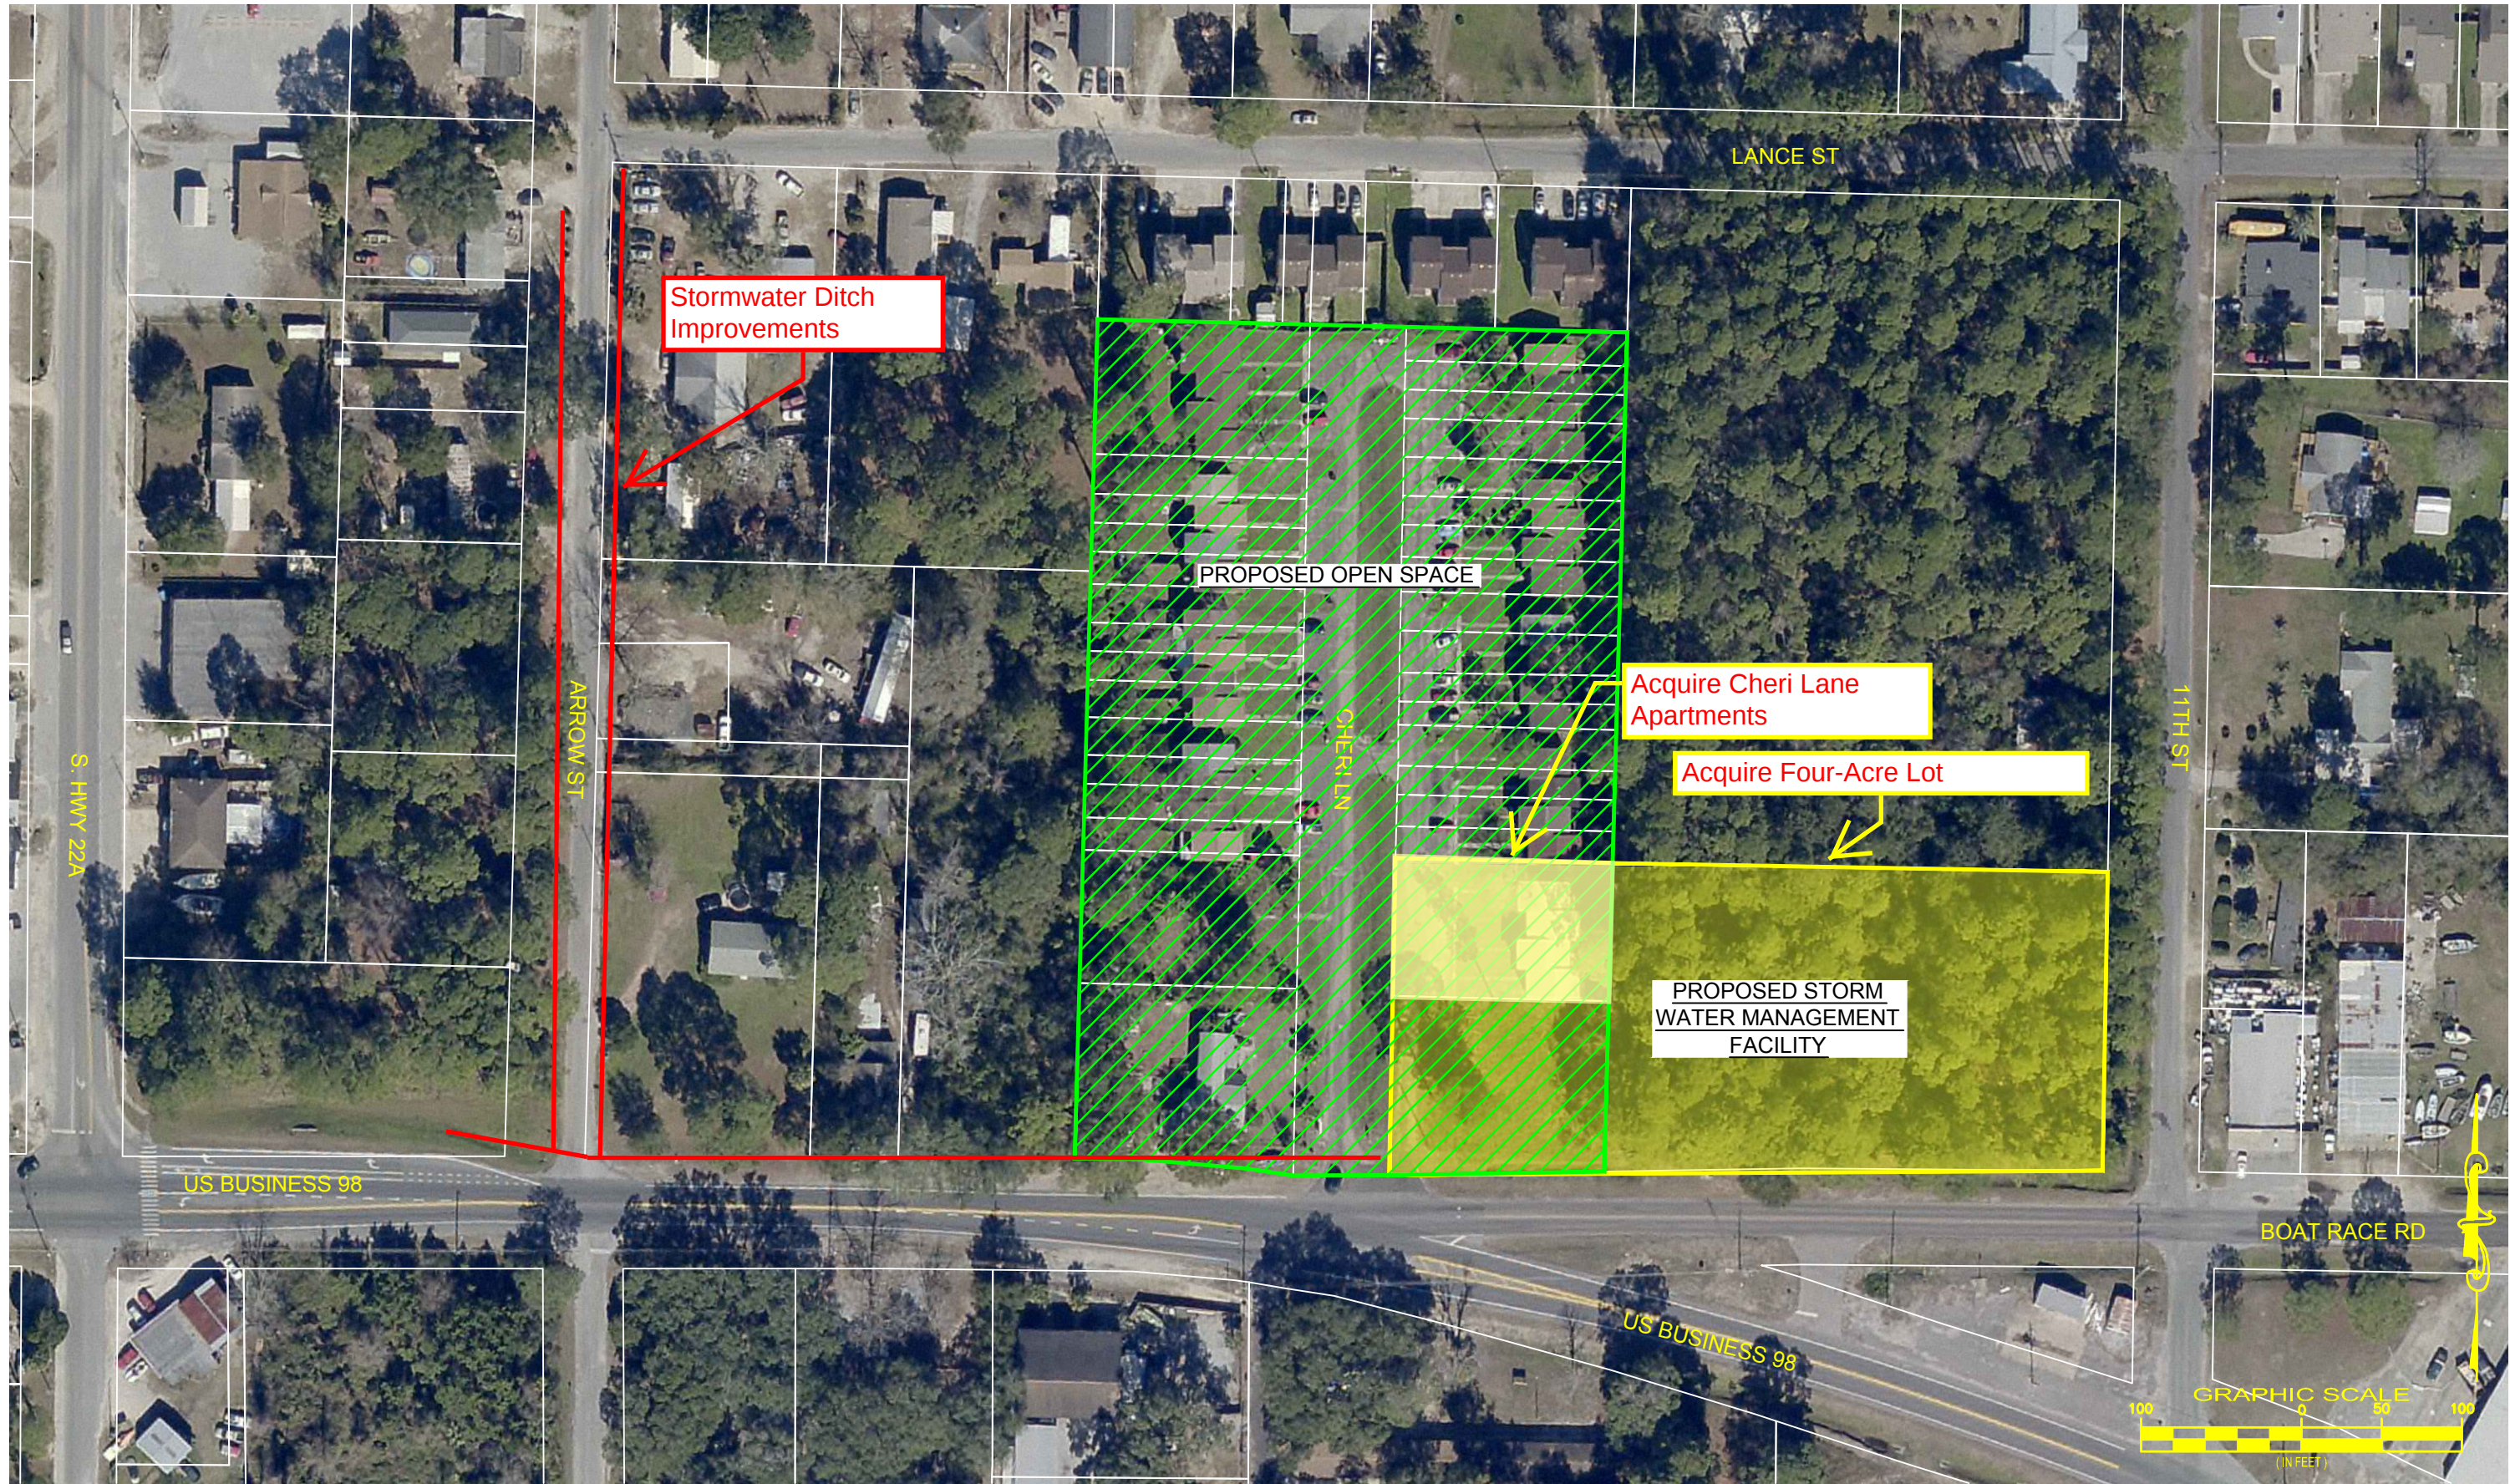

NO.	DATE:	APPR.	REVISION:
1			
2			
3			
4			
5			

PR

PREBLE-RISH, INC.

CONSULTING ENGINEERS

CIVIL • SURVEYING • SITE PLANNING

203 ABERDEEN PKWY, PANAMA CITY, FL 32405

(850) 522-0644

EXHIBIT A

CHERI LN. STORM WATER MANAGEMENT FACILITY

CITY OF PARKER

BAY COUNTY, FLORIDA

DATE: DCE, 2014	PROJECT NO. 248.120
SCALE: 1" = 100'	
DRAWN: S. RAY	SHEET A
CHECKED: J. DUB	