


January 15, 2015 (05:55:17 EST)
R:\220.035 SANDY CREEK WATER SYSTEM IMPROV\civil\3DPOLE\EXHIBITS\220035-EXHIBIT 1.DWG

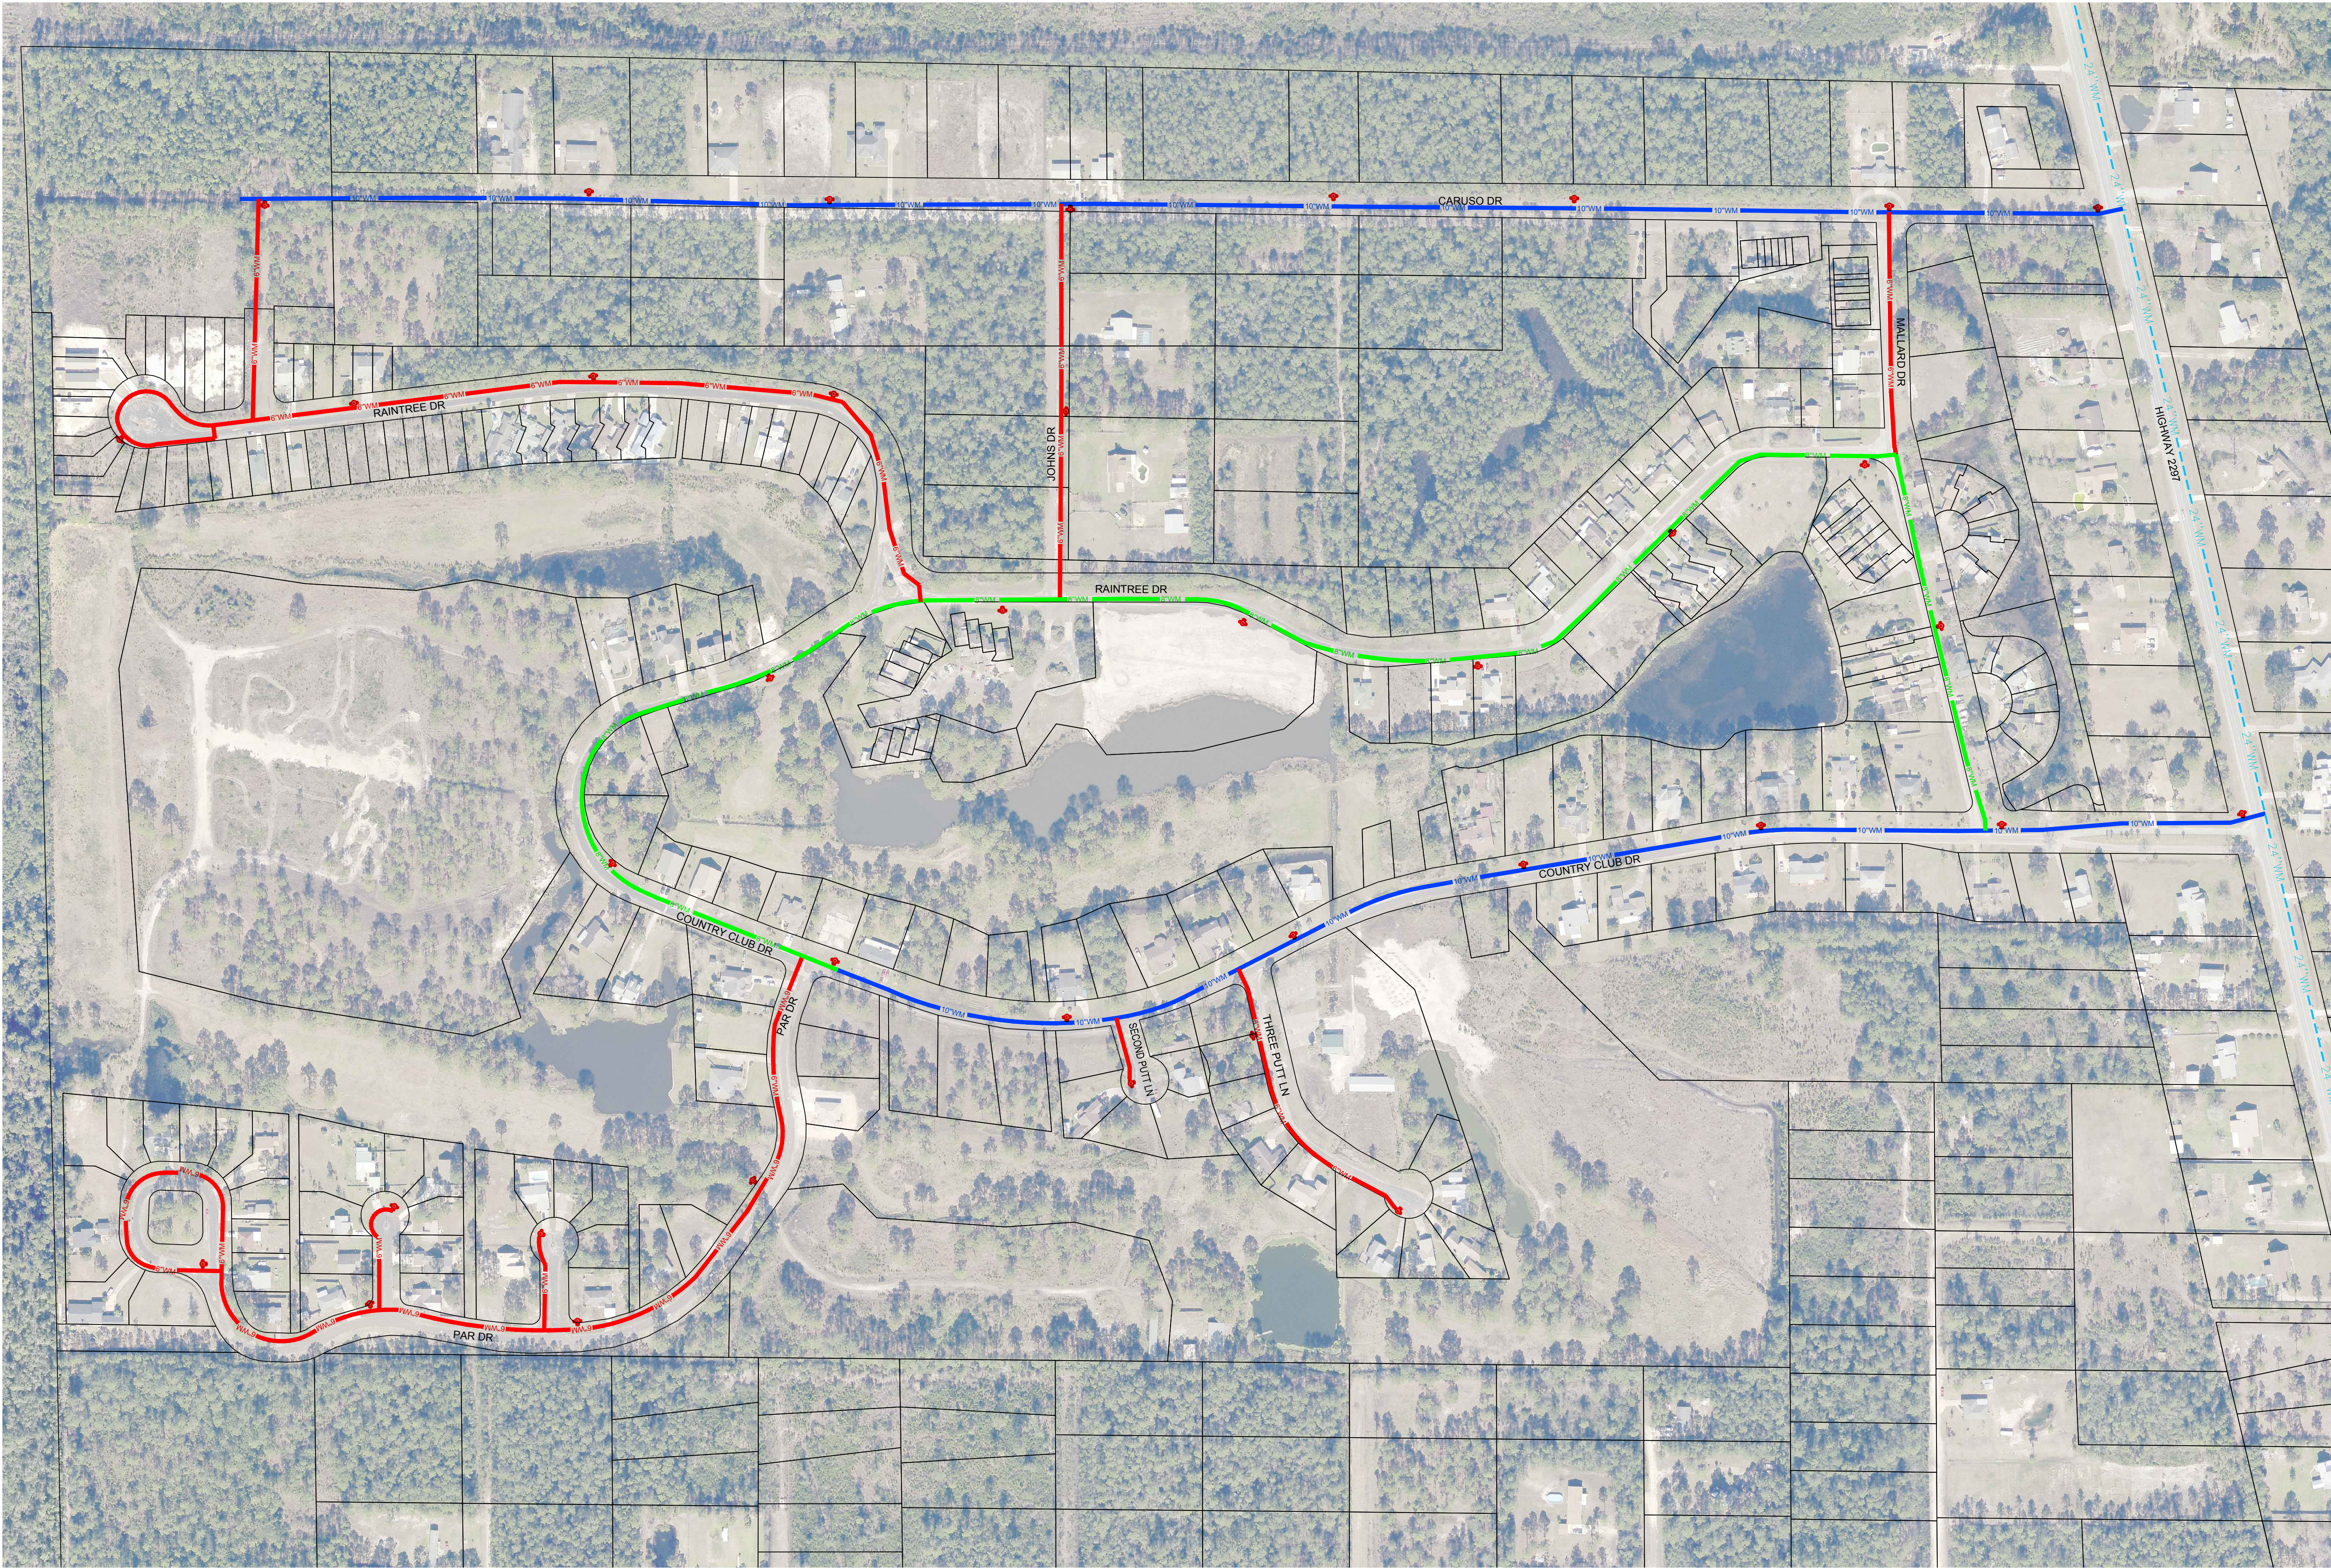

LEGEND

10"WM	PROPOSED 10" WATER MAIN
8"WM	PROPOSED 8" WATER MAIN
6"WM	PROPOSED 6" WATER MAIN
Fire Hydrant Symbol	PROPOSED FIRE HYDRANT

EXHIBIT 1

SANDY CREEK WATER SYSTEM IMPROVEMENTS
CITY OF CALLAWAY
BAY COUNTY
FLORIDA

PREBLE-RISH INC
CONSULTING ENGINEERS AND SURVEYORS
CIVIL • SURVEYING • SITE PLANNING
203 ABERDEEN PKWY, PANAMA CITY, FL 32405
(850) 522-0644

SCALE: 1" = 160'

DESIGNED: J. W.
DRAWN: S. RAY
CHECKED: J. SKLARSKI
DATE: JANUARY 2015

NOT APPROVED UNLESS DRAWING WITH PROFESSIONAL ENGINEER'S SEAL				PERSON	
NO.	DATE	APPR.			
1					
2					
3					
4					
5					
6					
7					

EB 0006155

PHILIP A. JONES 49851
CHRIS SHORTT 78424
JOHNATHAN SKLARSKI 67281