

ENGINEERING PLANS
FOR
***BOB SIKES INDUSTRIAL PARK WWTF EFFLUENT
DISPOSAL EXPANSION***

***OKALOOSA COUNTY WATER & SEWER SYSTEM
OKALOOSA COUNTY, FLORIDA
THE BOARD OF COUNTY COMMISSIONERS***

CHAIRMAN

BILL ROBERTS

BOARD MEMBERS

DON AMUNDS
JAMES CAMPBELL
WAYNE C. HARRIS
JOHN JANNAZO

CLERK

DON W. HOWARD



COUNTY ADMINISTRATOR

JAMES D. CURRY

OKALOOSA COUNTY
WATER AND SEWER

JEFF LITRELL, DIRECTOR


FEBRUARY 2009
Job No. 41-264 PHASE II



POLYENGINEERING, INC.
ARCHITECTURE. ENGINEERING. SOLUTIONS

POST OFFICE BOX 841
102 SUNSET LANE
SHALIMAR, FLORIDA 32579
850-609-1100
WWW.POLYENGINEERING.COM

Polyengineering, Inc. - C:\CLEANSTUFF-29-999\41264 CrestView WWTF Operating Permit\WP\PHASE \GENERAL\41264 Index.dwg [VIC-MAP (1)] Last Printed: March 13, 2009 - 09:51am By: Alderman

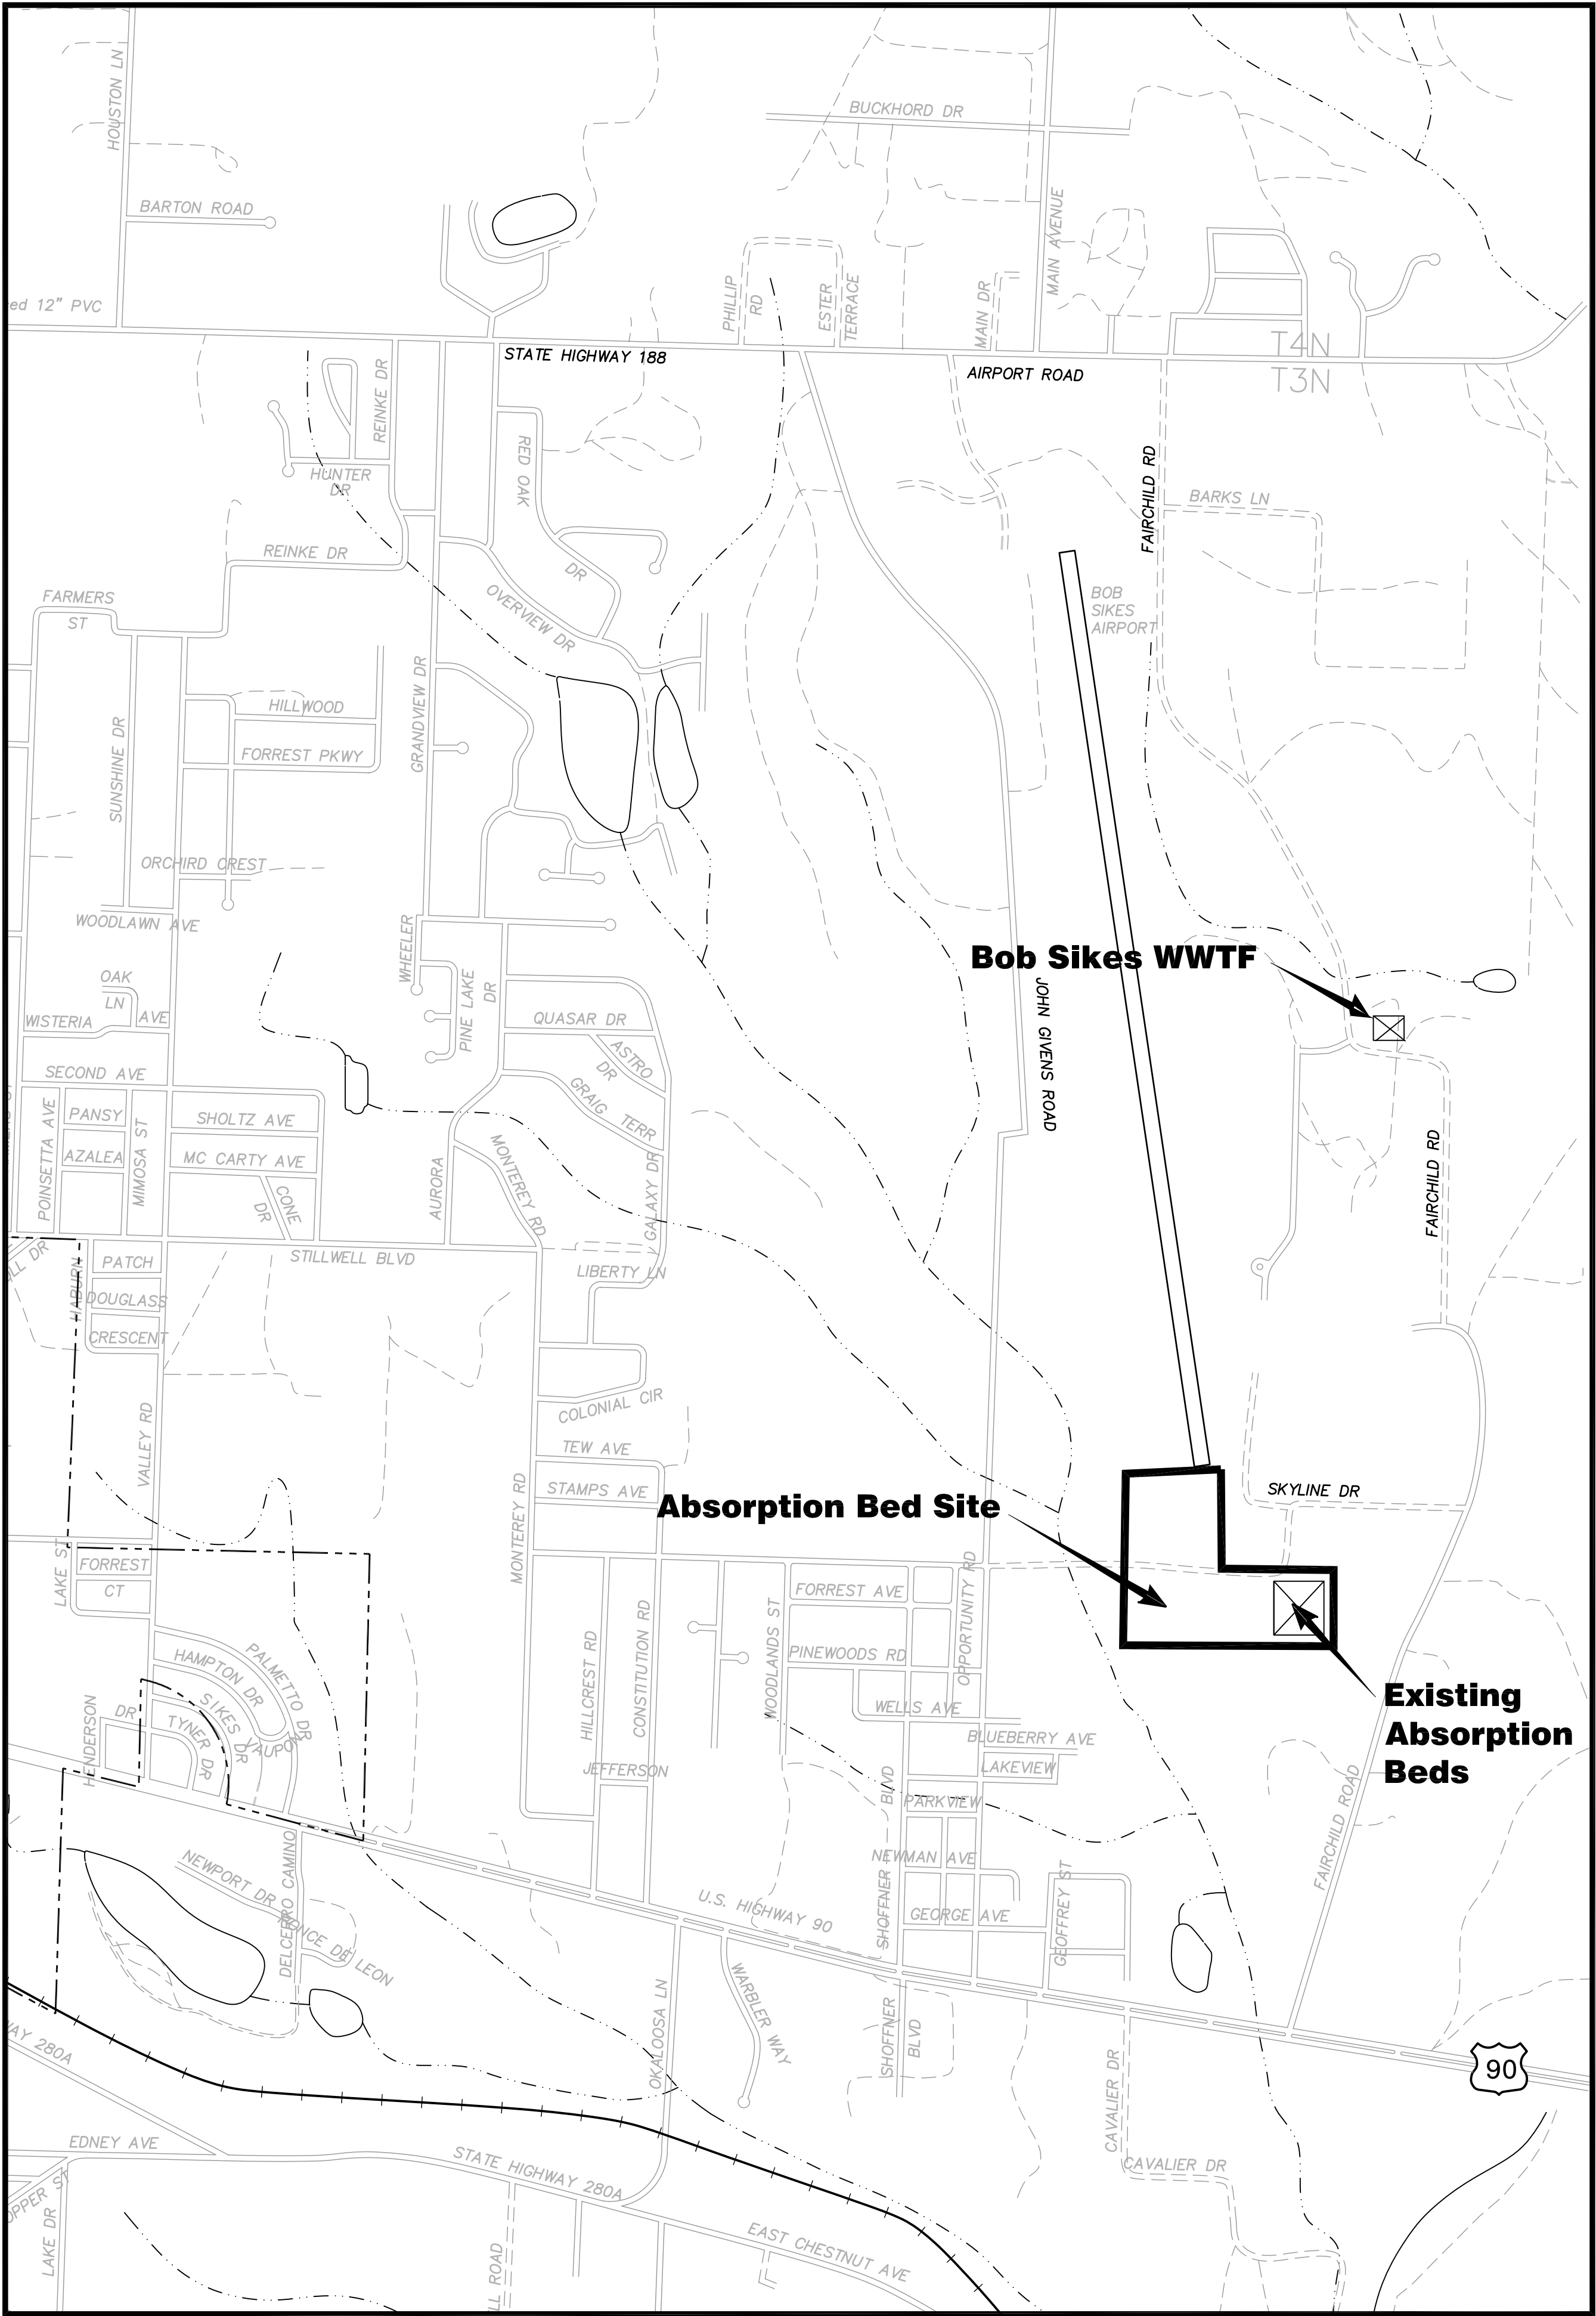

INDEX

VICINITY MAP AND INDEX	G-1
PLAN AND PROFILE STA.0+00 TO STA. 12+00	C-1
PLAN AND PROFILE STA. 12+00 TO STA. 24+00	C-2
PLAN AND PROFILE STA. 24+00 TO STA. 36+00	C-3
PLAN AND PROFILE STA. 36+00 TO STA. 48+00	C-4
PLAN AND PROFILE STA. 48+00 TO STA. 60+00	C-5
PLAN AND PROFILE STA. 60+00 TO STA. 64+26.69	C-6
ABSORPTION BED LAYOUT	C-7
ABSORPTION BED OVERALL LAYOUT	C-8
ABSORPTION BEDS	C-9
ABSORPTION BEDS	C-10
ABSORPTION BEDS	C-11
NEW IN-LINE DISC FILTERS	C-12
ABSORPTION BED DETAILS	C-13
ABSORPTION BED DETAILS	C-14
CONTROL DIAGRAM	E-1
CONTROL DIAGRAM	E-2
CONTROL DIAGRAM	E-3
CONTROL PANEL INSIDE	E-4
CONTROL PANEL FRONT	E-5

ENGINEER OF RECORD
BETH BRANT
REGISTRATION NUMBER
FL LIC. NO. 57972

BOB SIKES PARK
WWTF EFFLUENT DISPOSAL
EXPANSION
PHASE II
OKALOOSA COUNTY WATER AND SEWER SYSTEM
OKALOOSA COUNTY, FLORIDA

POLYENGINEERING, INC.
ARCHITECTURE, ENGINEERING, SOLUTIONS
Post Office Box 841
102 Sunset Lane
Shalimar, Florida 32579
850-609-1100
WWW.POLYENGINEERING.COM

Revisions			
Key	Revised By	Appr'd. By	Date
Δ			
Δ			
Δ			

Field Book No.

Drawn By
DH

Appr'd. By
BB

Date
FEBRUARY 2009


Project No.
41-264

Sheet title
VICINITY MAP
AND
INDEX



Sheet No

G-1
1 of 1


Polyengineering, Inc. - G:\CLEANSTUFF-29-999\41264 CrestView WWTF Operating Permit\WP\PHASE I\Sheet C-2 to C-7\ 41264TOP0.dwg [41264-02] Last Printed: March 13, 2009 - 09:52am By: Alderman

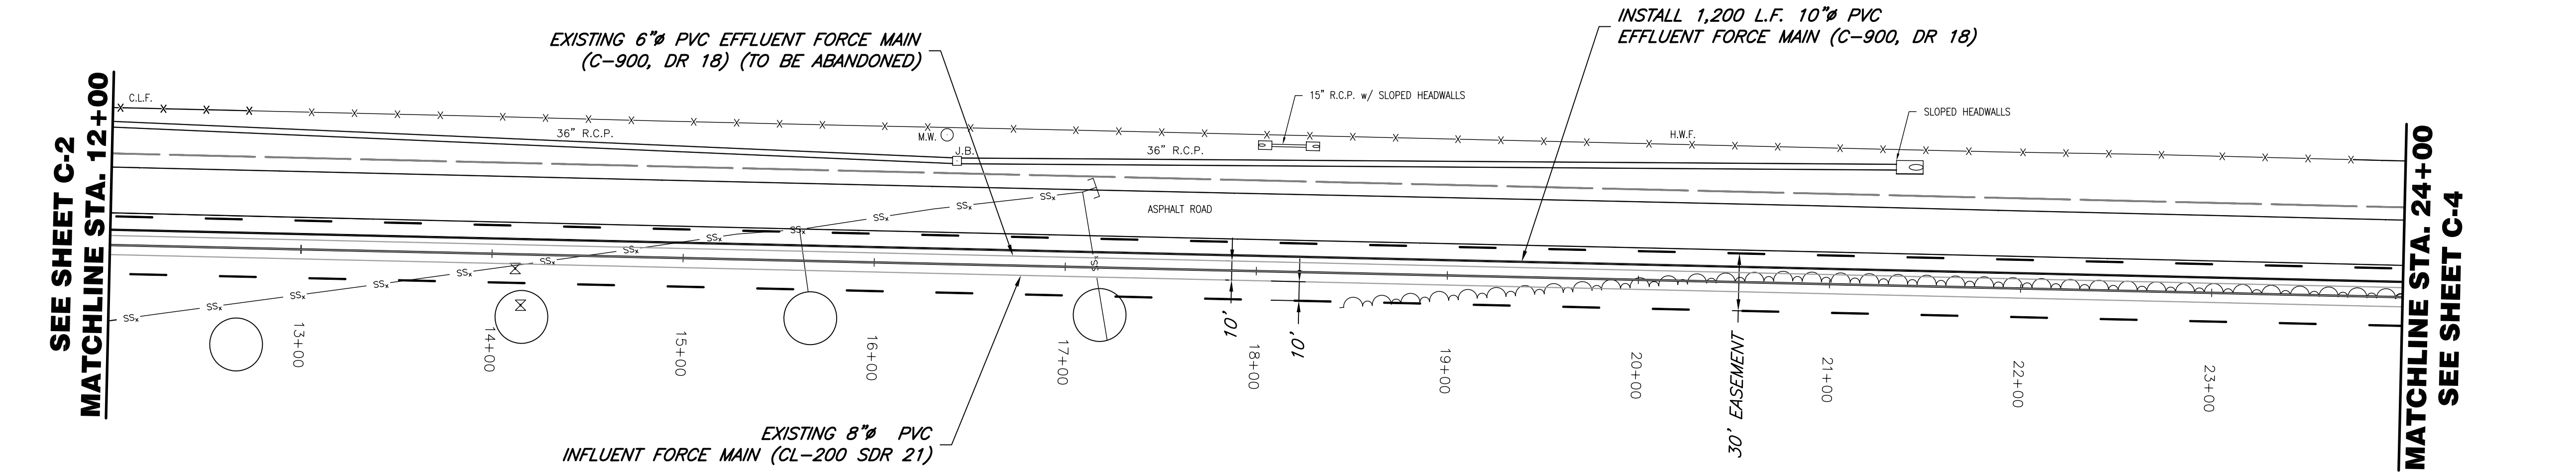

NOTE:
1. NEW 10" FORCE MAIN TO BE INSTALLED 3' MINIMUM FROM
EXISTING 6" FORCE MAIN (TO BE ABANDONED)

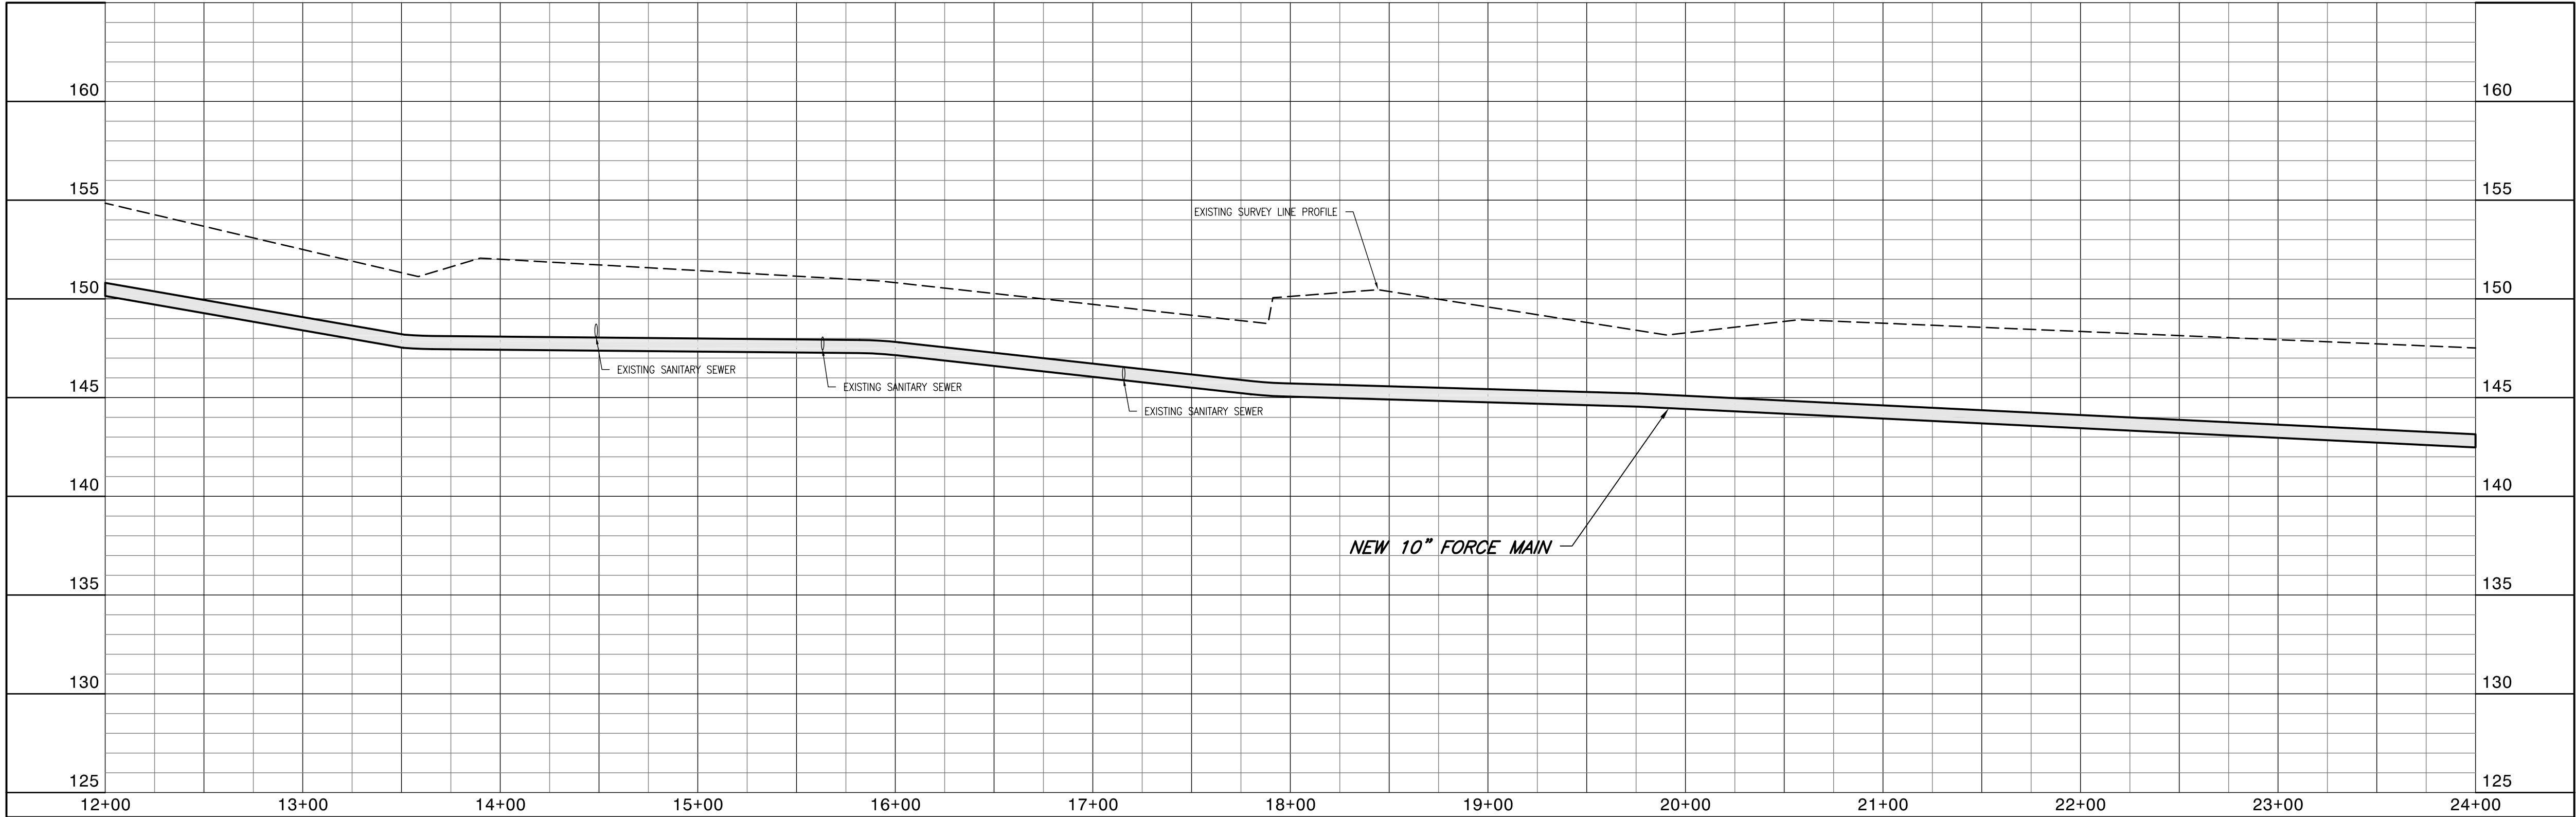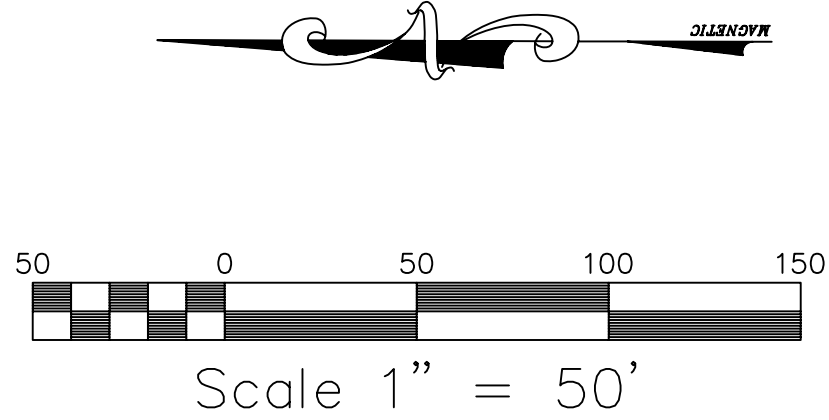

ENGINEER OF RECORD
BETH BRANT
REGISTRATION NUMBER
FL LIC. NO. 57972

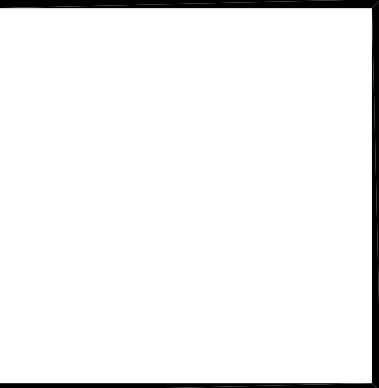

Cert. of Auth. No.
CA-1818

These drawings are copy-
righted and the property
of Polyengineering. Any
use, partial or full repro-
duction is prohibited
except by written Agree-
ment with Polyengineering

BOB SIKES PARK
WWTF EFFLUENT DISPOSAL
EXPANSION
PHASE II
OKALOOSA COUNTY WATER AND SEWER SYSTEM
OKALOOSA COUNTY, FLORIDA

POLYENGINEERING, INC.
ARCHITECTURE, ENGINEERING, SOLUTIONS

Post Office Box 841
102 SUNSET LANE
SHALIMAR, FLORIDA 32579
850-609-1100
WWW.POLYENGINEERING.COM

Revisions			
Key	Drawn By	Apprvd. By	Date
1			
2			
3			
4			

Field Book No.
0016

Drawn By
D.H./B.J.

Apprvd. By
B.B.

Date
FEBRUARY 2009



Project No.
41-264

Sheet title
STA. 12+00
TO
STA. 24+00

Sheet No

C-2
2 OF 14

Polyengineering, Inc. - G:\CLEANSTUFF-29-999\41264 Crestview WWTF Operating Permit\WIP\PHASE II\Sheet C-2 to C-7\ 41264TOP0.dwg [41264-03] Last Printed: March 13, 2009 - 09:53am By: Alderman

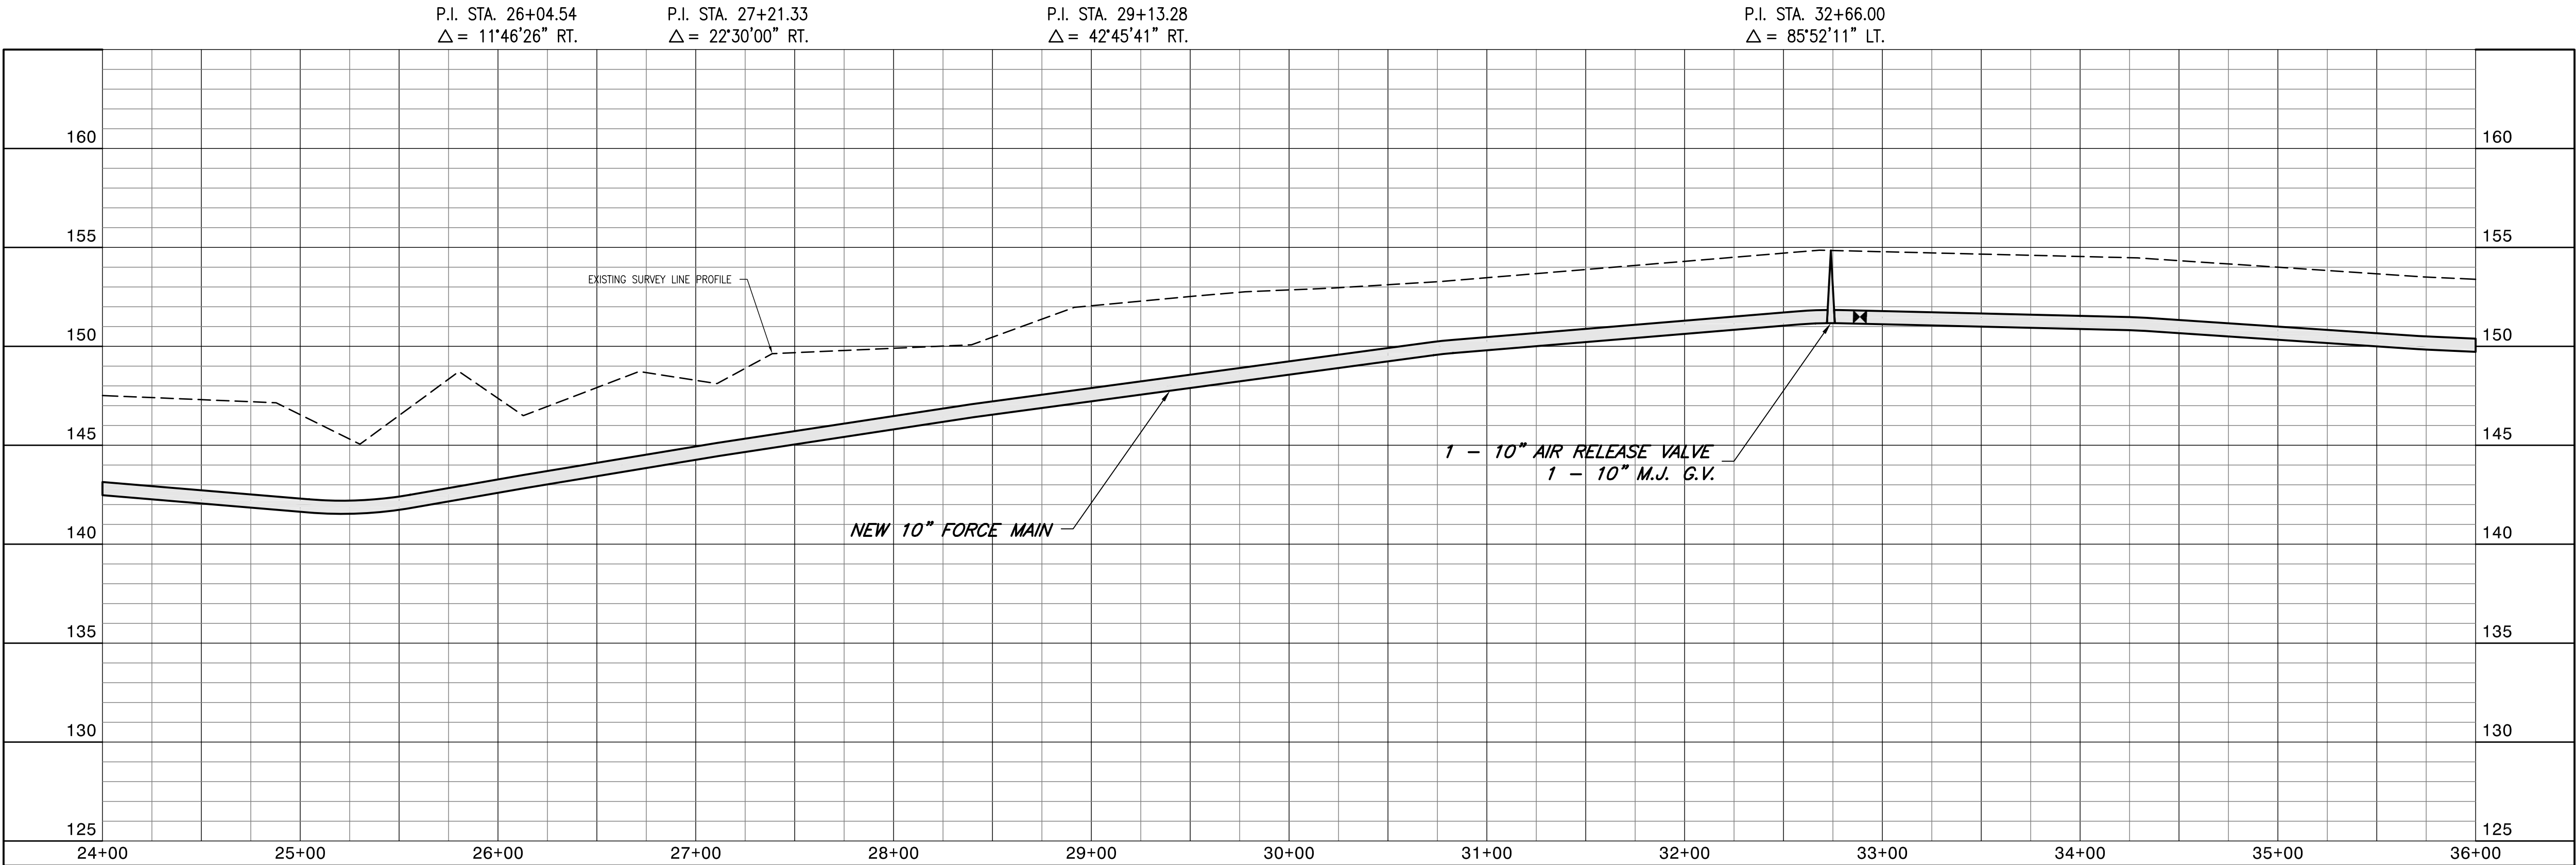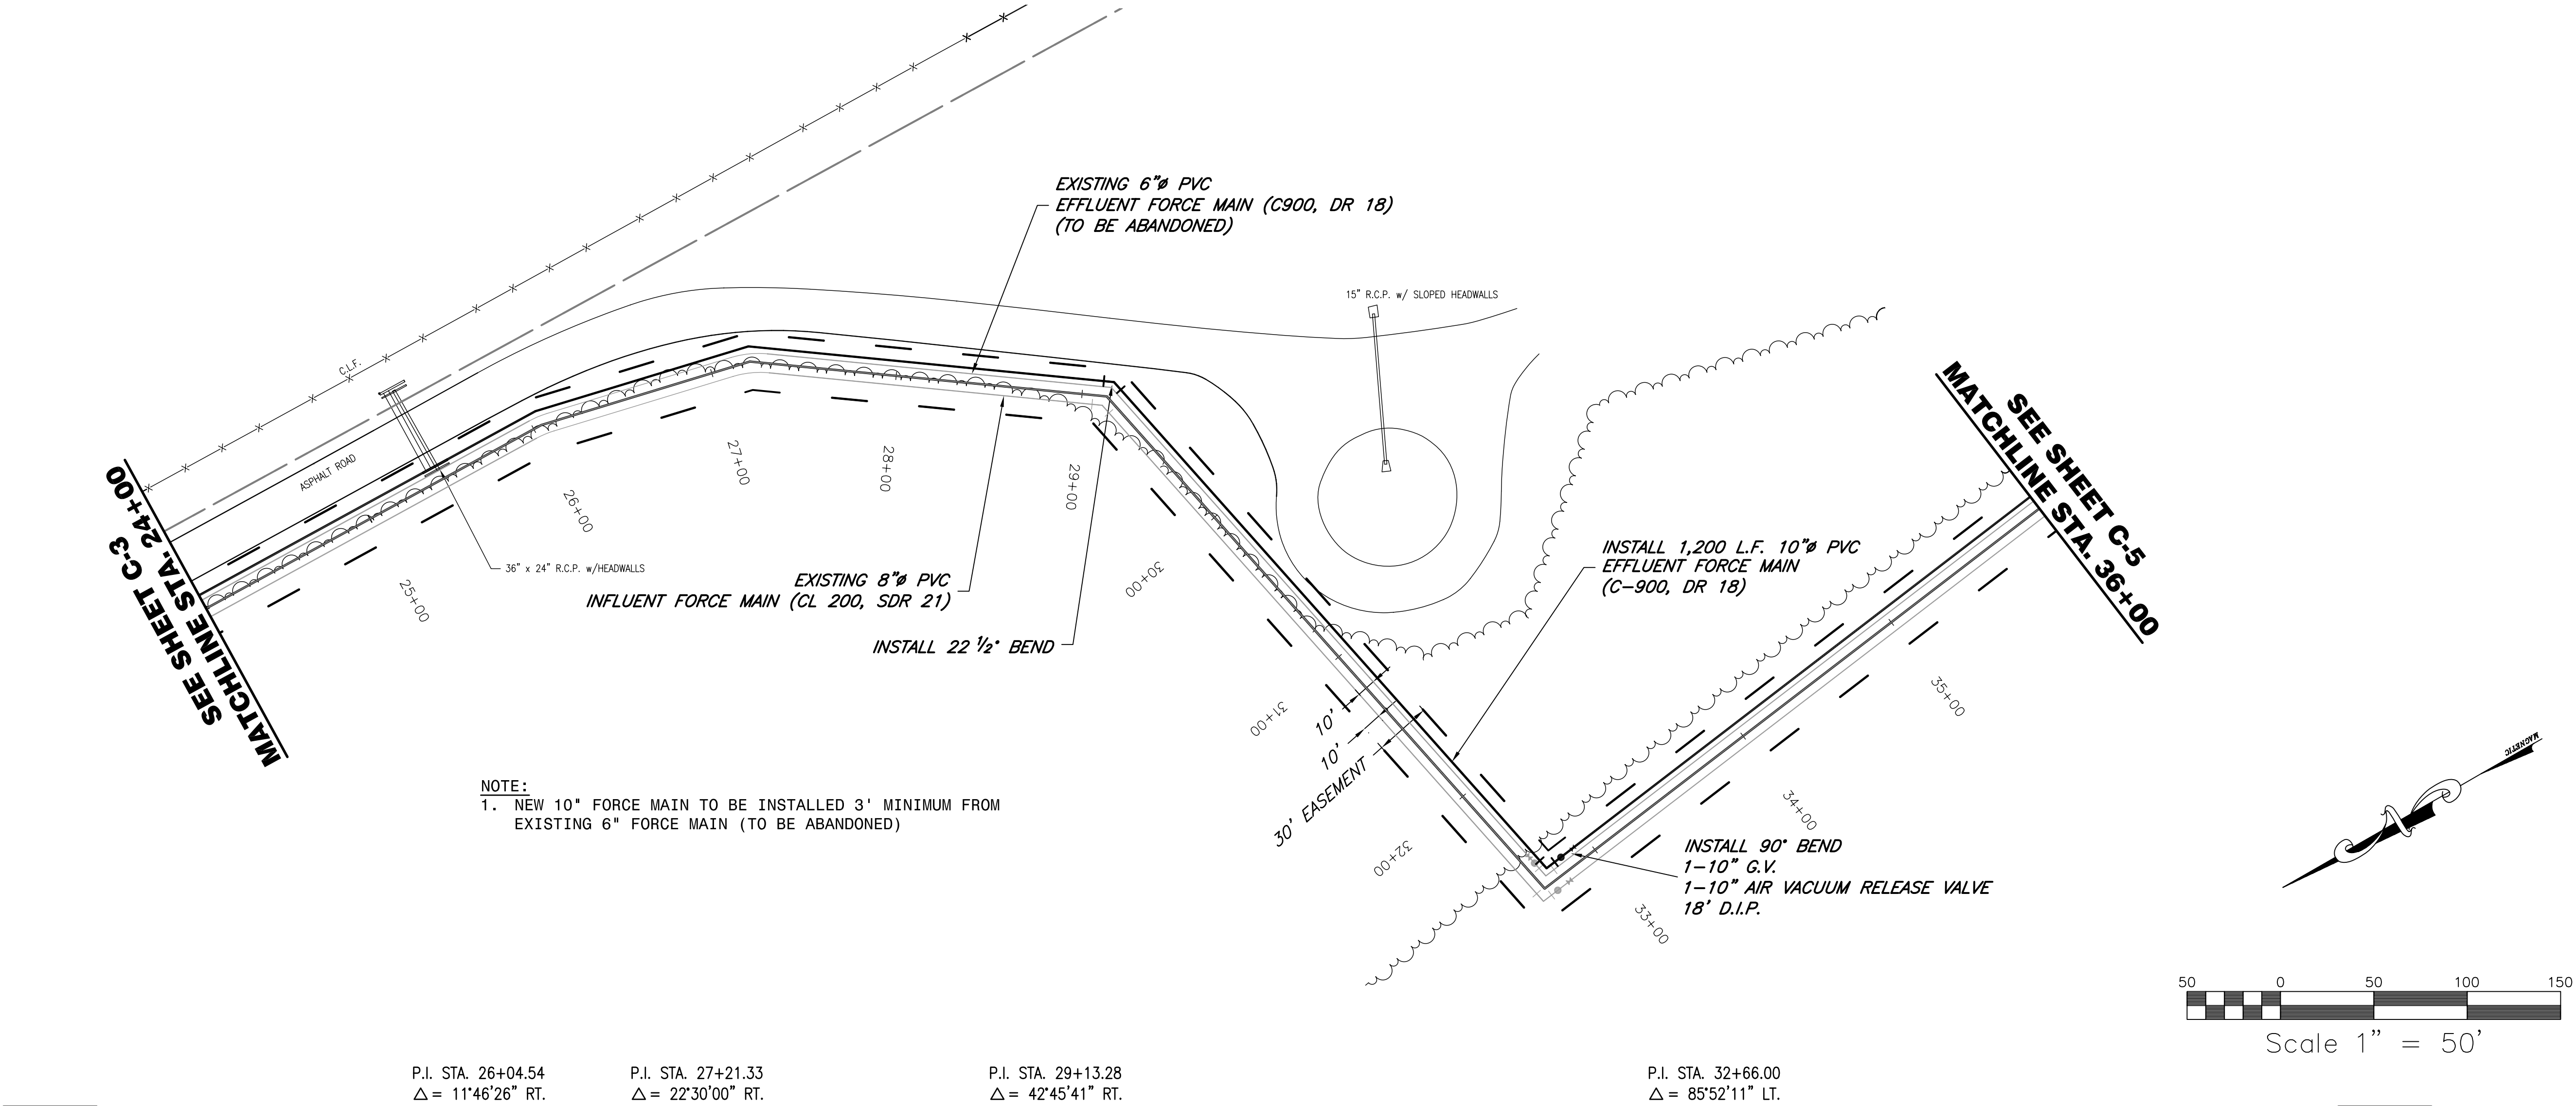

ENGINEER OF RECORD
BETH BRANT
REGISTRATION NUMBER
FL LIC. NO. 57972


Cert. of Auth. No.
CA-1818

These drawings are copy-righted and the property of Polyengineering. Any use, partial or full reproduction is prohibited except by written Agreement with Polyengineering

BOB SIKES PARK
WWTF EFFLUENT DISPOSAL
EXPANSION
PHASE II
OKALOOSA COUNTY WATER AND SEWER SYSTEM
OKALOOSA COUNTY, FLORIDA

POLYENGINEERING, INC.
ARCHITECTURE, ENGINEERING, SOLUTIONS

Post Office Box 841
102 Sunset Lane
Shalimar, Florida 32579
850-609-1100
WWW.POLYENGINEERING.COM

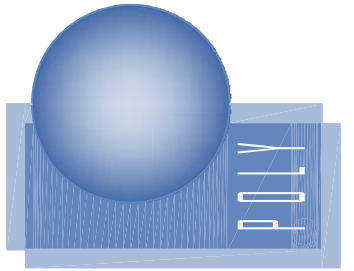

Key	Revised	By	Appr'd.	Date
Δ				
Δ				
Δ				
Δ				

Field Book No.
0016

Drawn By
D.H./B.J.

Appr'd. By
B.B.

Date
FEBRUARY 2009




Project No.
41-264

Sheet title
STA. 24+00
TO
STA. 36+00

Sheet No

C-3
3 OF 14

Polyengineering, Inc. - G:\CLEANSTUFF-29-999\41264 CrestView WWTF Operating Permit\WP\PHASE II\Sheet C-2 to C-7\ 41264TOP0.dwg [41264-04] Last Printed: March 13, 2009 - 09:54am By: Alderman

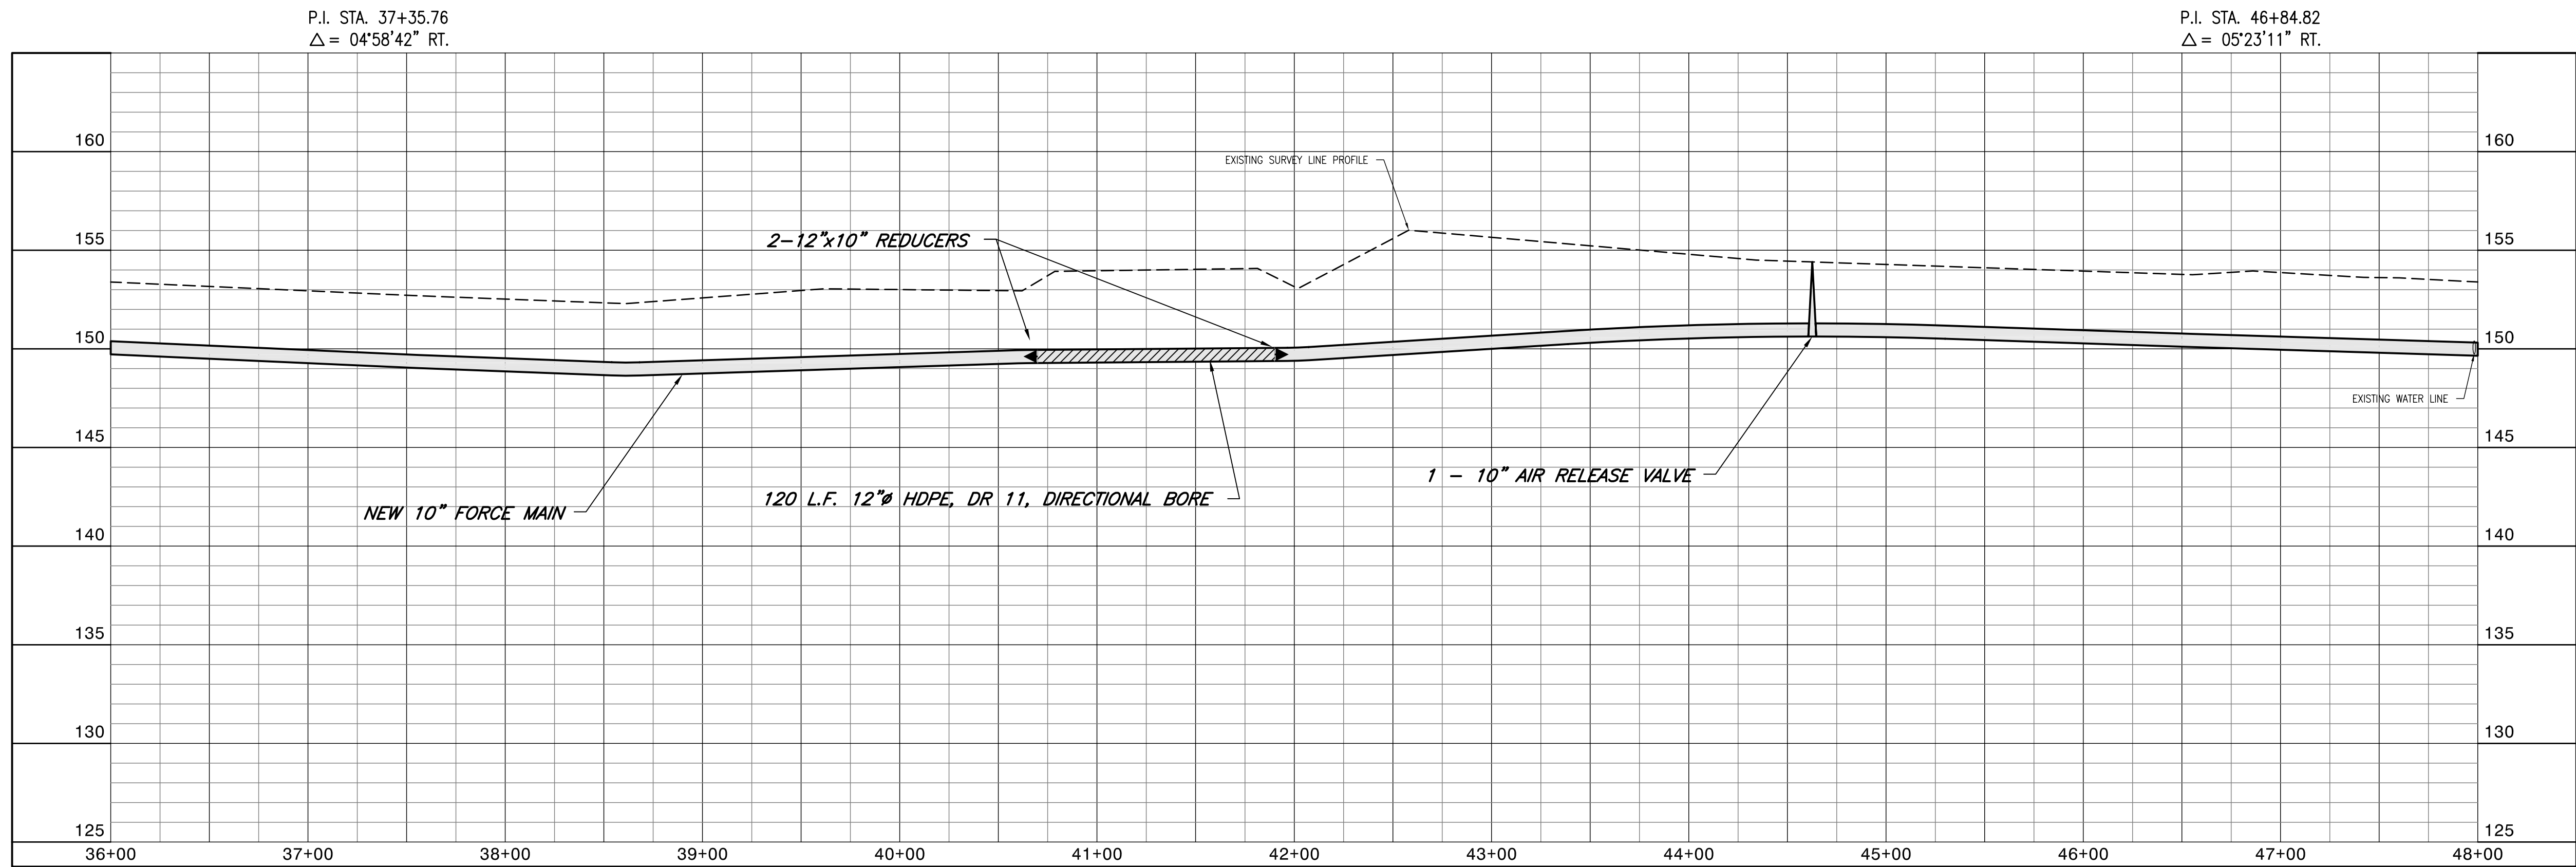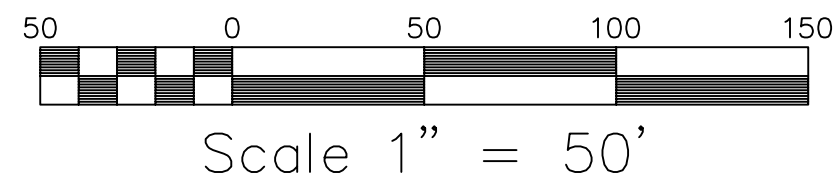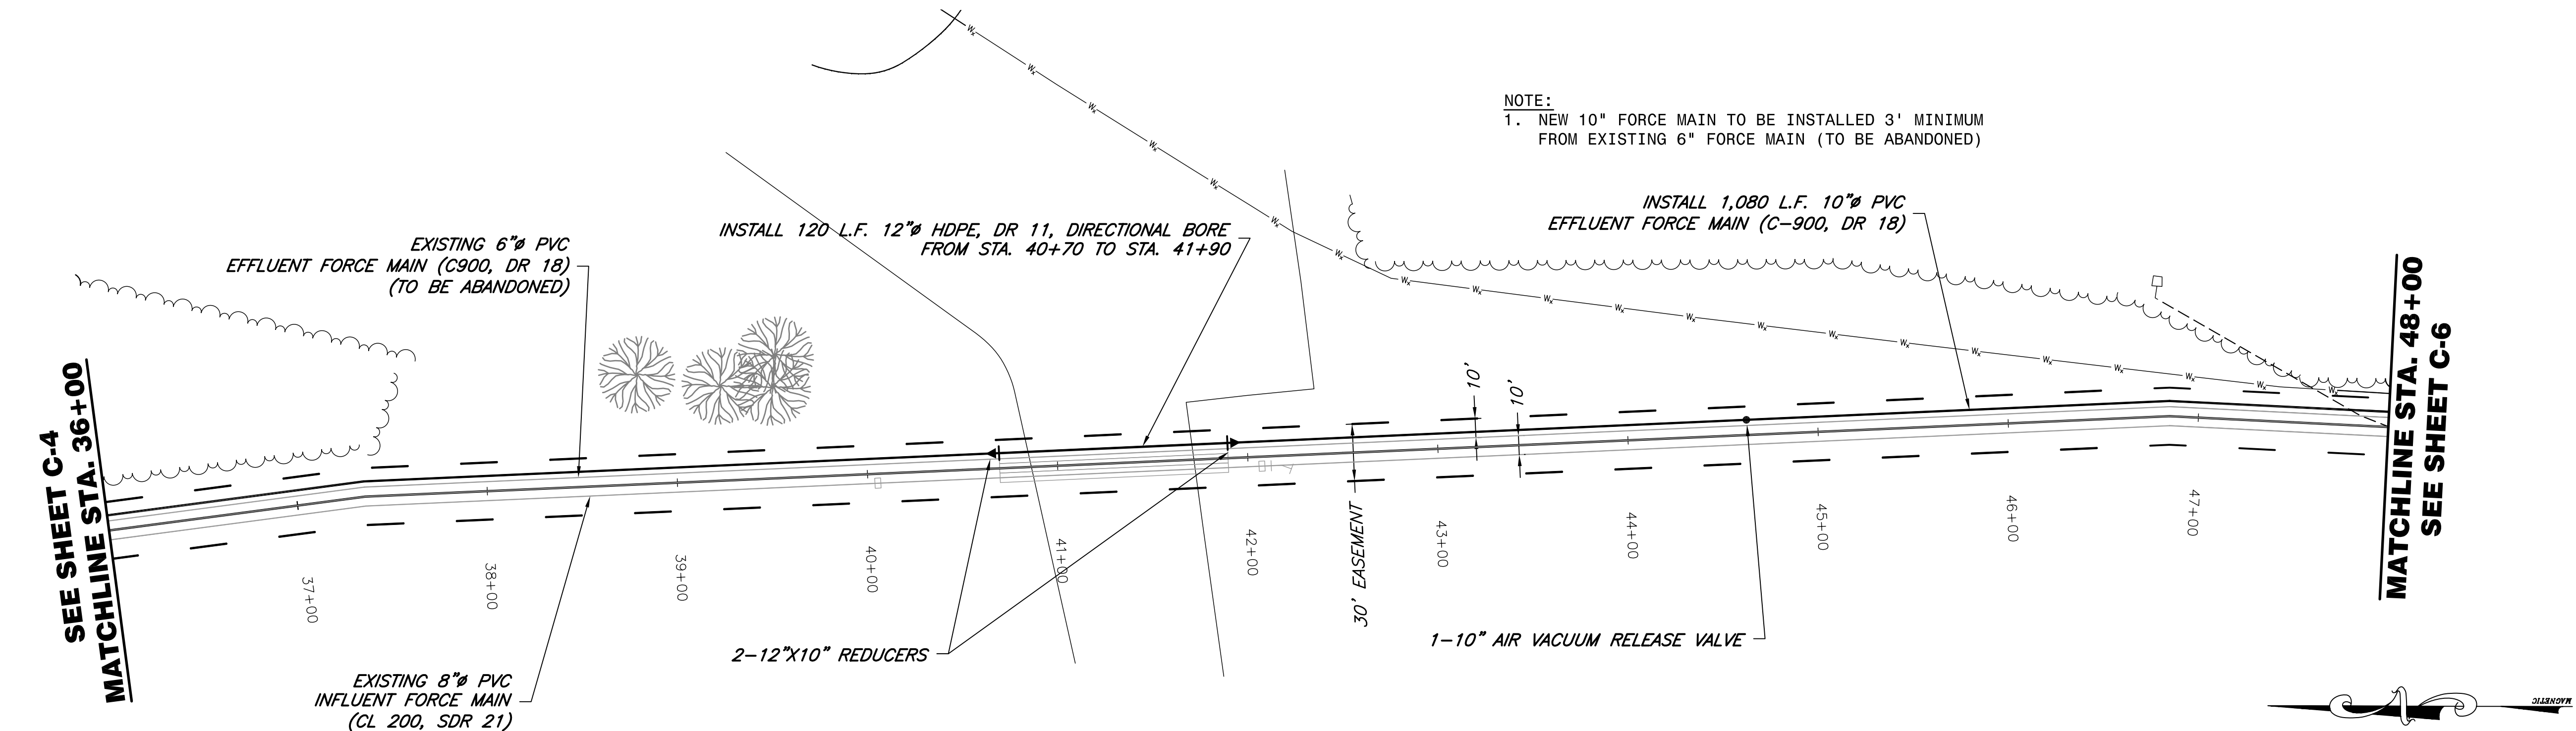

ENGINEER OF RECORD
BETH BRANT
REGISTRATION NUMBER
FL LIC. NO. 57972

Cert. of Auth. No.
CA-1818

These drawings are copy-
righted and the property
of Polyengineering. Any
use, partial or full repro-
duction is prohibited
except by written Agree-
ment with Polyengineering

BOB SIKES PARK
WWTF EFFLUENT DISPOSAL
EXPANSION
PHASE II
OKALOOSA COUNTY WATER AND SEWER SYSTEM
OKALOOSA COUNTY, FLORIDA

POLYENGINEERING, INC.
ARCHITECTURE, ENGINEERING, SOLUTIONS

Post Office Box 841
102 SUNSET LANE
SHALIMAR, FLORIDA 32579
850-609-1100
WWW.POLYENGINEERING.COM

Revisions			
Key	Drawn By	Apprvd. By	Date
1			
2			
3			
4			

Field Book No.
0016

Drawn By
D.H./B.J.

Apprvd. By
B.B.

Date
FEBRUARY 2009



Project No.
41-264

Sheet title
STA. 36+00
TO
STA. 48+00


Sheet No.

C-4
4 OF 14

Polyengineering, Inc. - G:\CLEANSTUFF-29-999\41264 CrestView WWTF Operating Permit\WP\PHASE II\Sheet C-2 to C-7) 41264TOP0.dwg [41264-05] Last Printed: March 13, 2009 - 09:54am By: Alderman

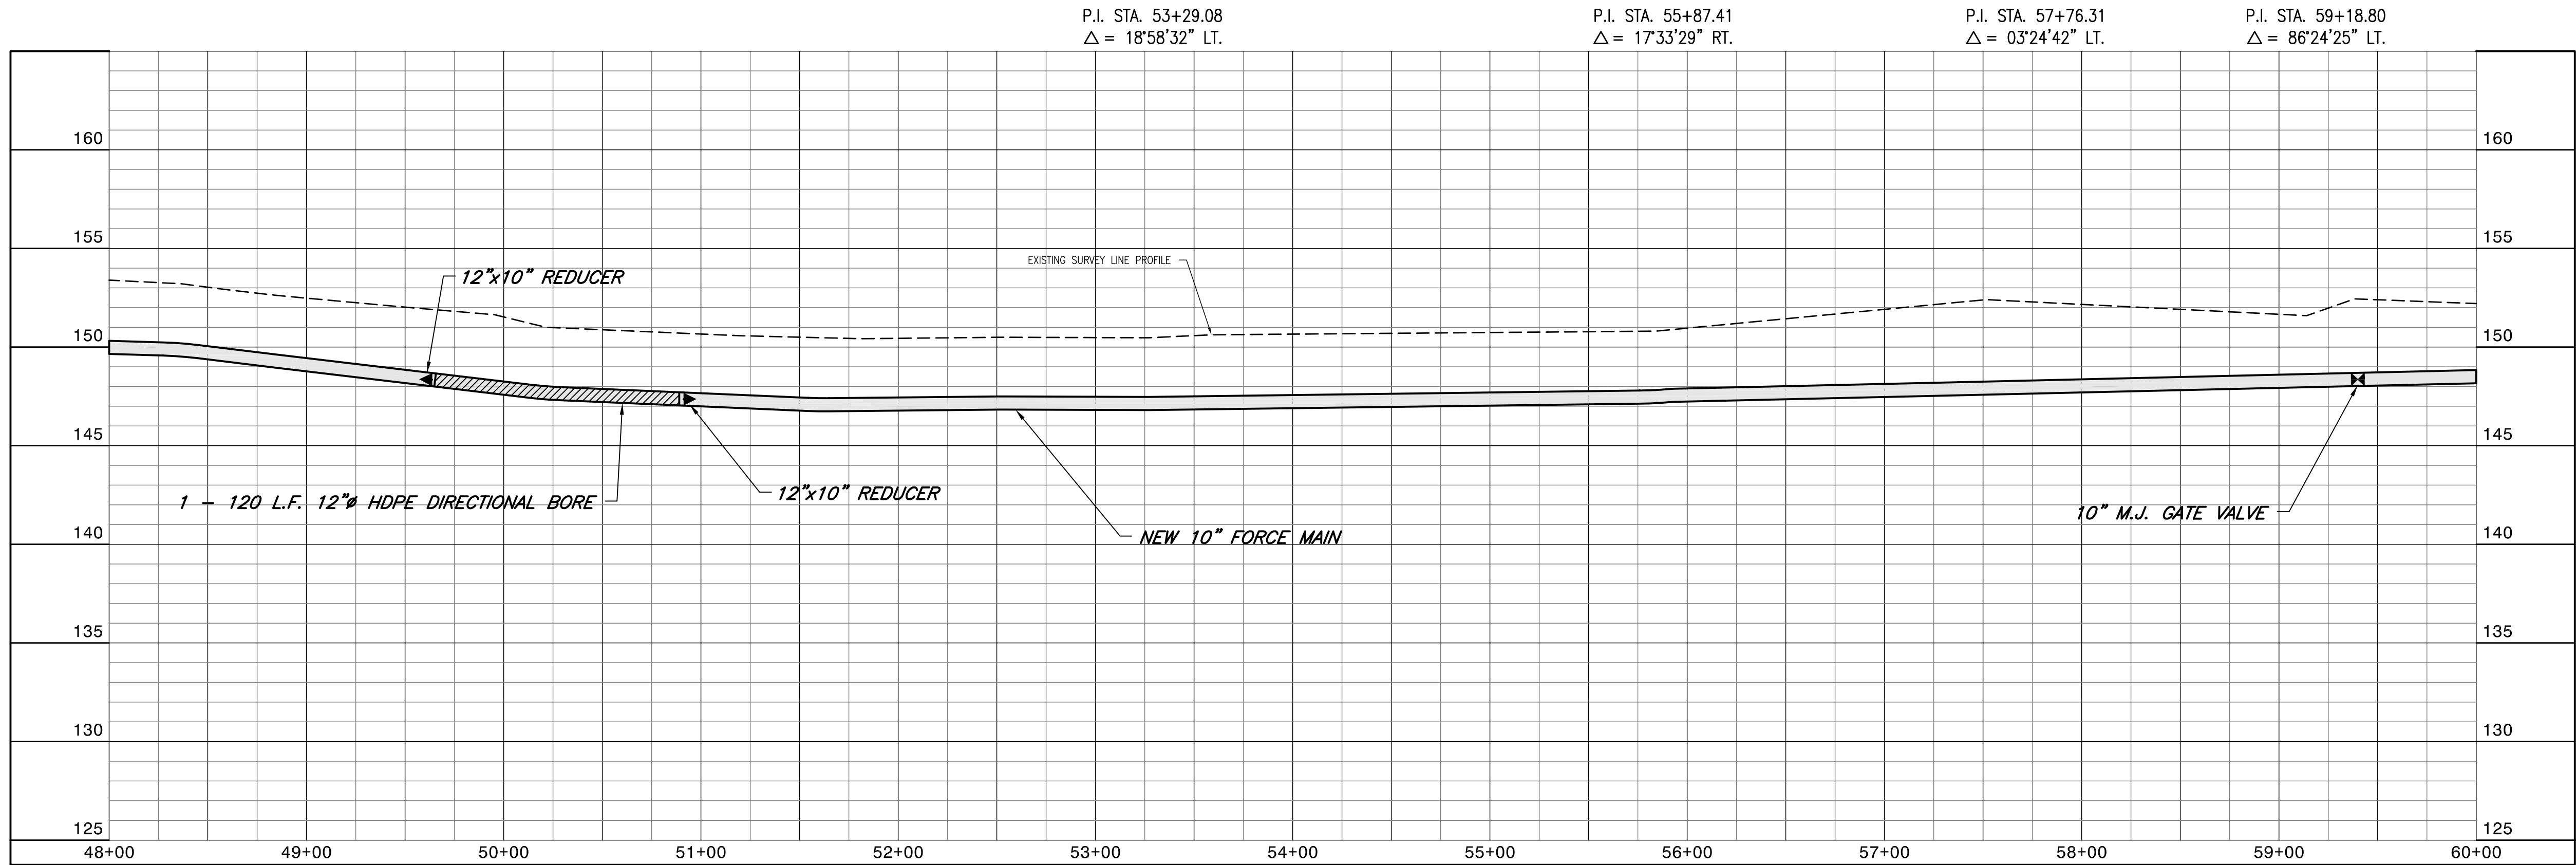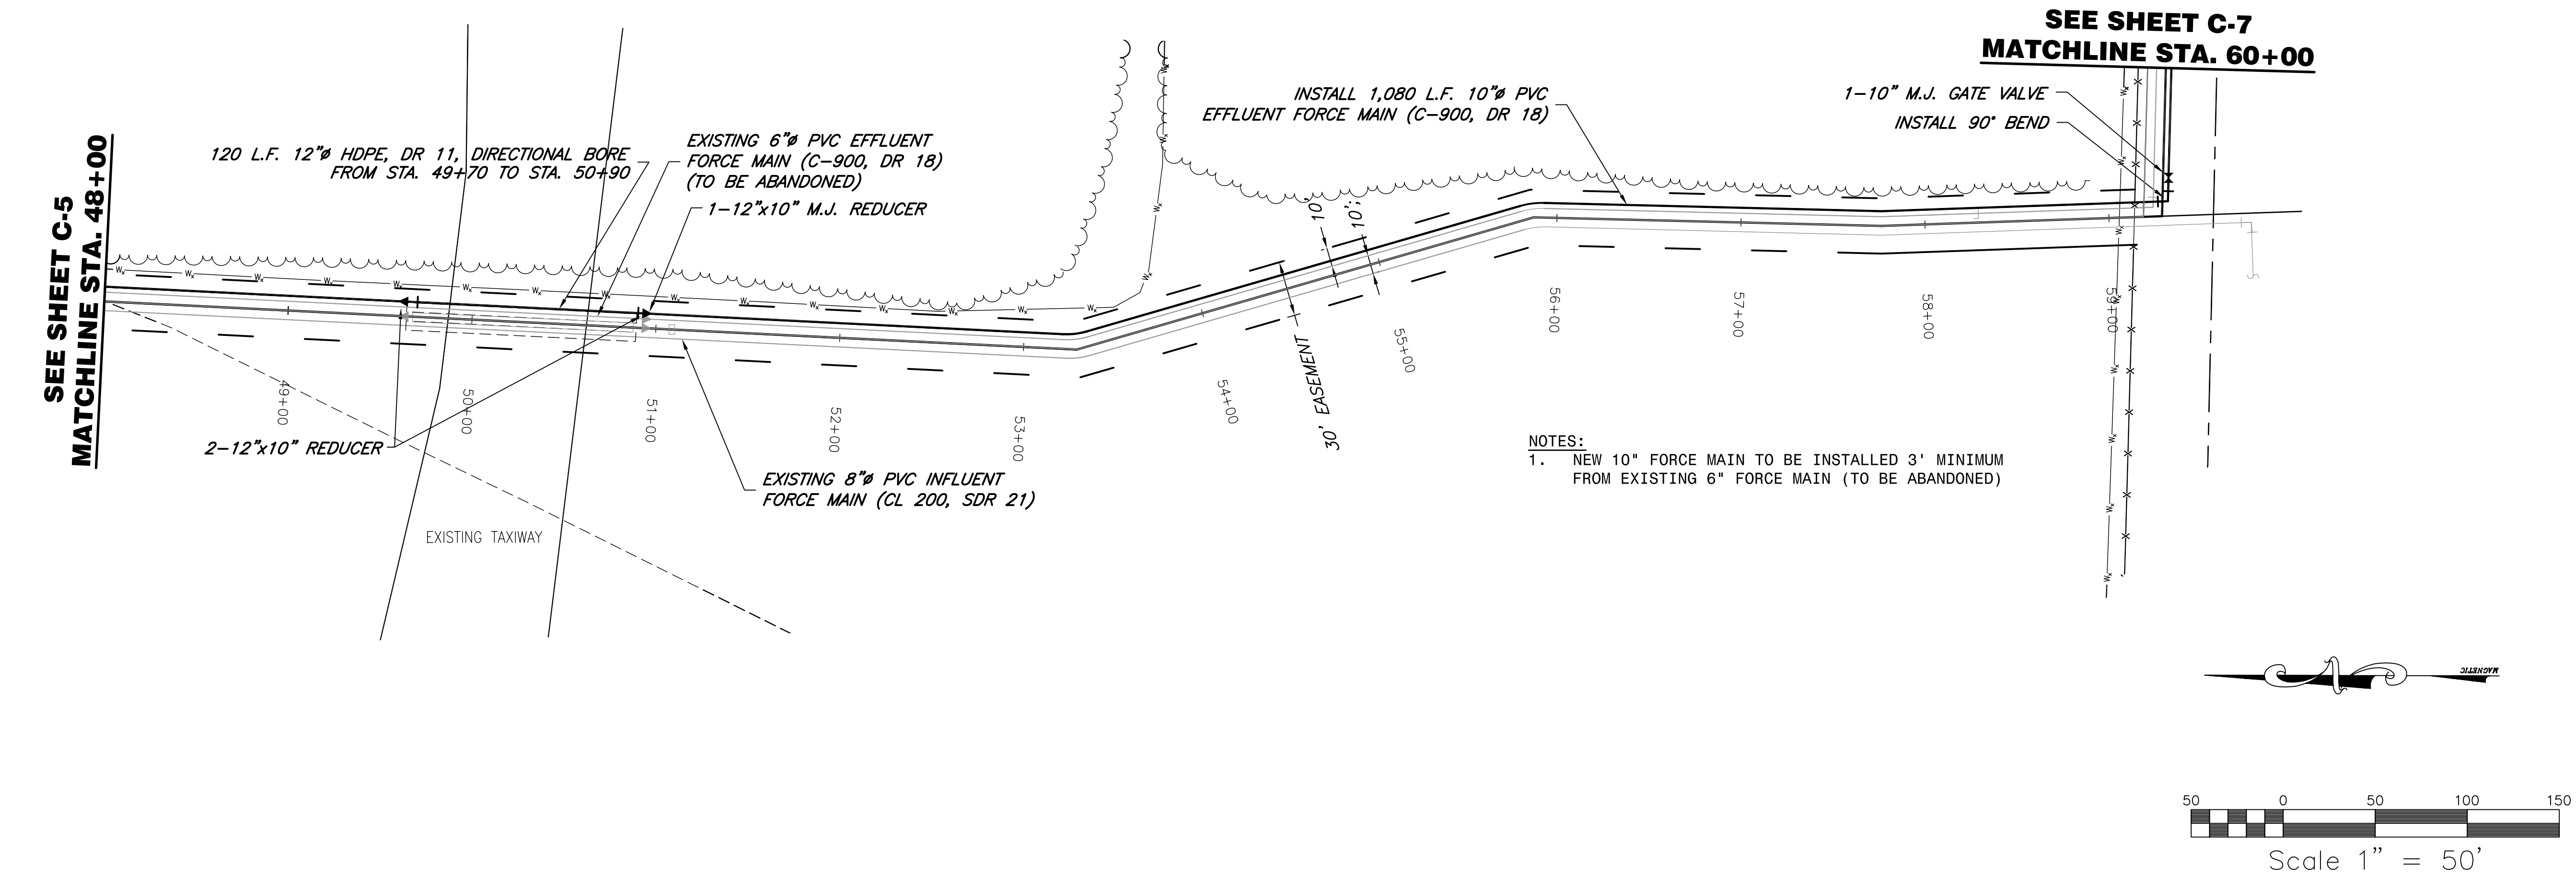

ENGINEER OF RECORD
BETH BRANT
REGISTRATION NUMBER
FL LIC. NO. 57972

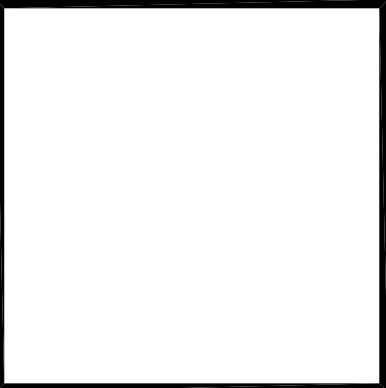

Cert. of Auth. No.
CA-1818

These drawings are copy-
righted and the property
of Polyengineering. Any
use, partial or full repro-
duction is prohibited
except by written Agree-
ment with Polyengineering

**BOB SIKES PARK
WWTF EFFLUENT DISPOSAL
EXPANSION
PHASE II**
OKALOOSA COUNTY WATER AND SEWER SYSTEM
OKALOOSA COUNTY, FLORIDA

POLYENGINEERING, INC.
ARCHITECTURE, ENGINEERING, SOLUTIONS

Post Office Box 841
102 SUNSET LAKE
SHALIMAR, FLORIDA 32579
850-609-1100
WWW.POLYENGINEERING.COM

Revisions			
Key	Drawn By	Apprvd. By	Date
1			
2			
3			
4			

Field Book No.
0016

Drawn By
D.H./B.J.



Apprvd. By
B.B.

Date
FEBRUARY 2009

Project No.
41-264

Sheet title
STA. 48+00
TO
STA. 60+00

Sheet No
C-5
5 OF 14

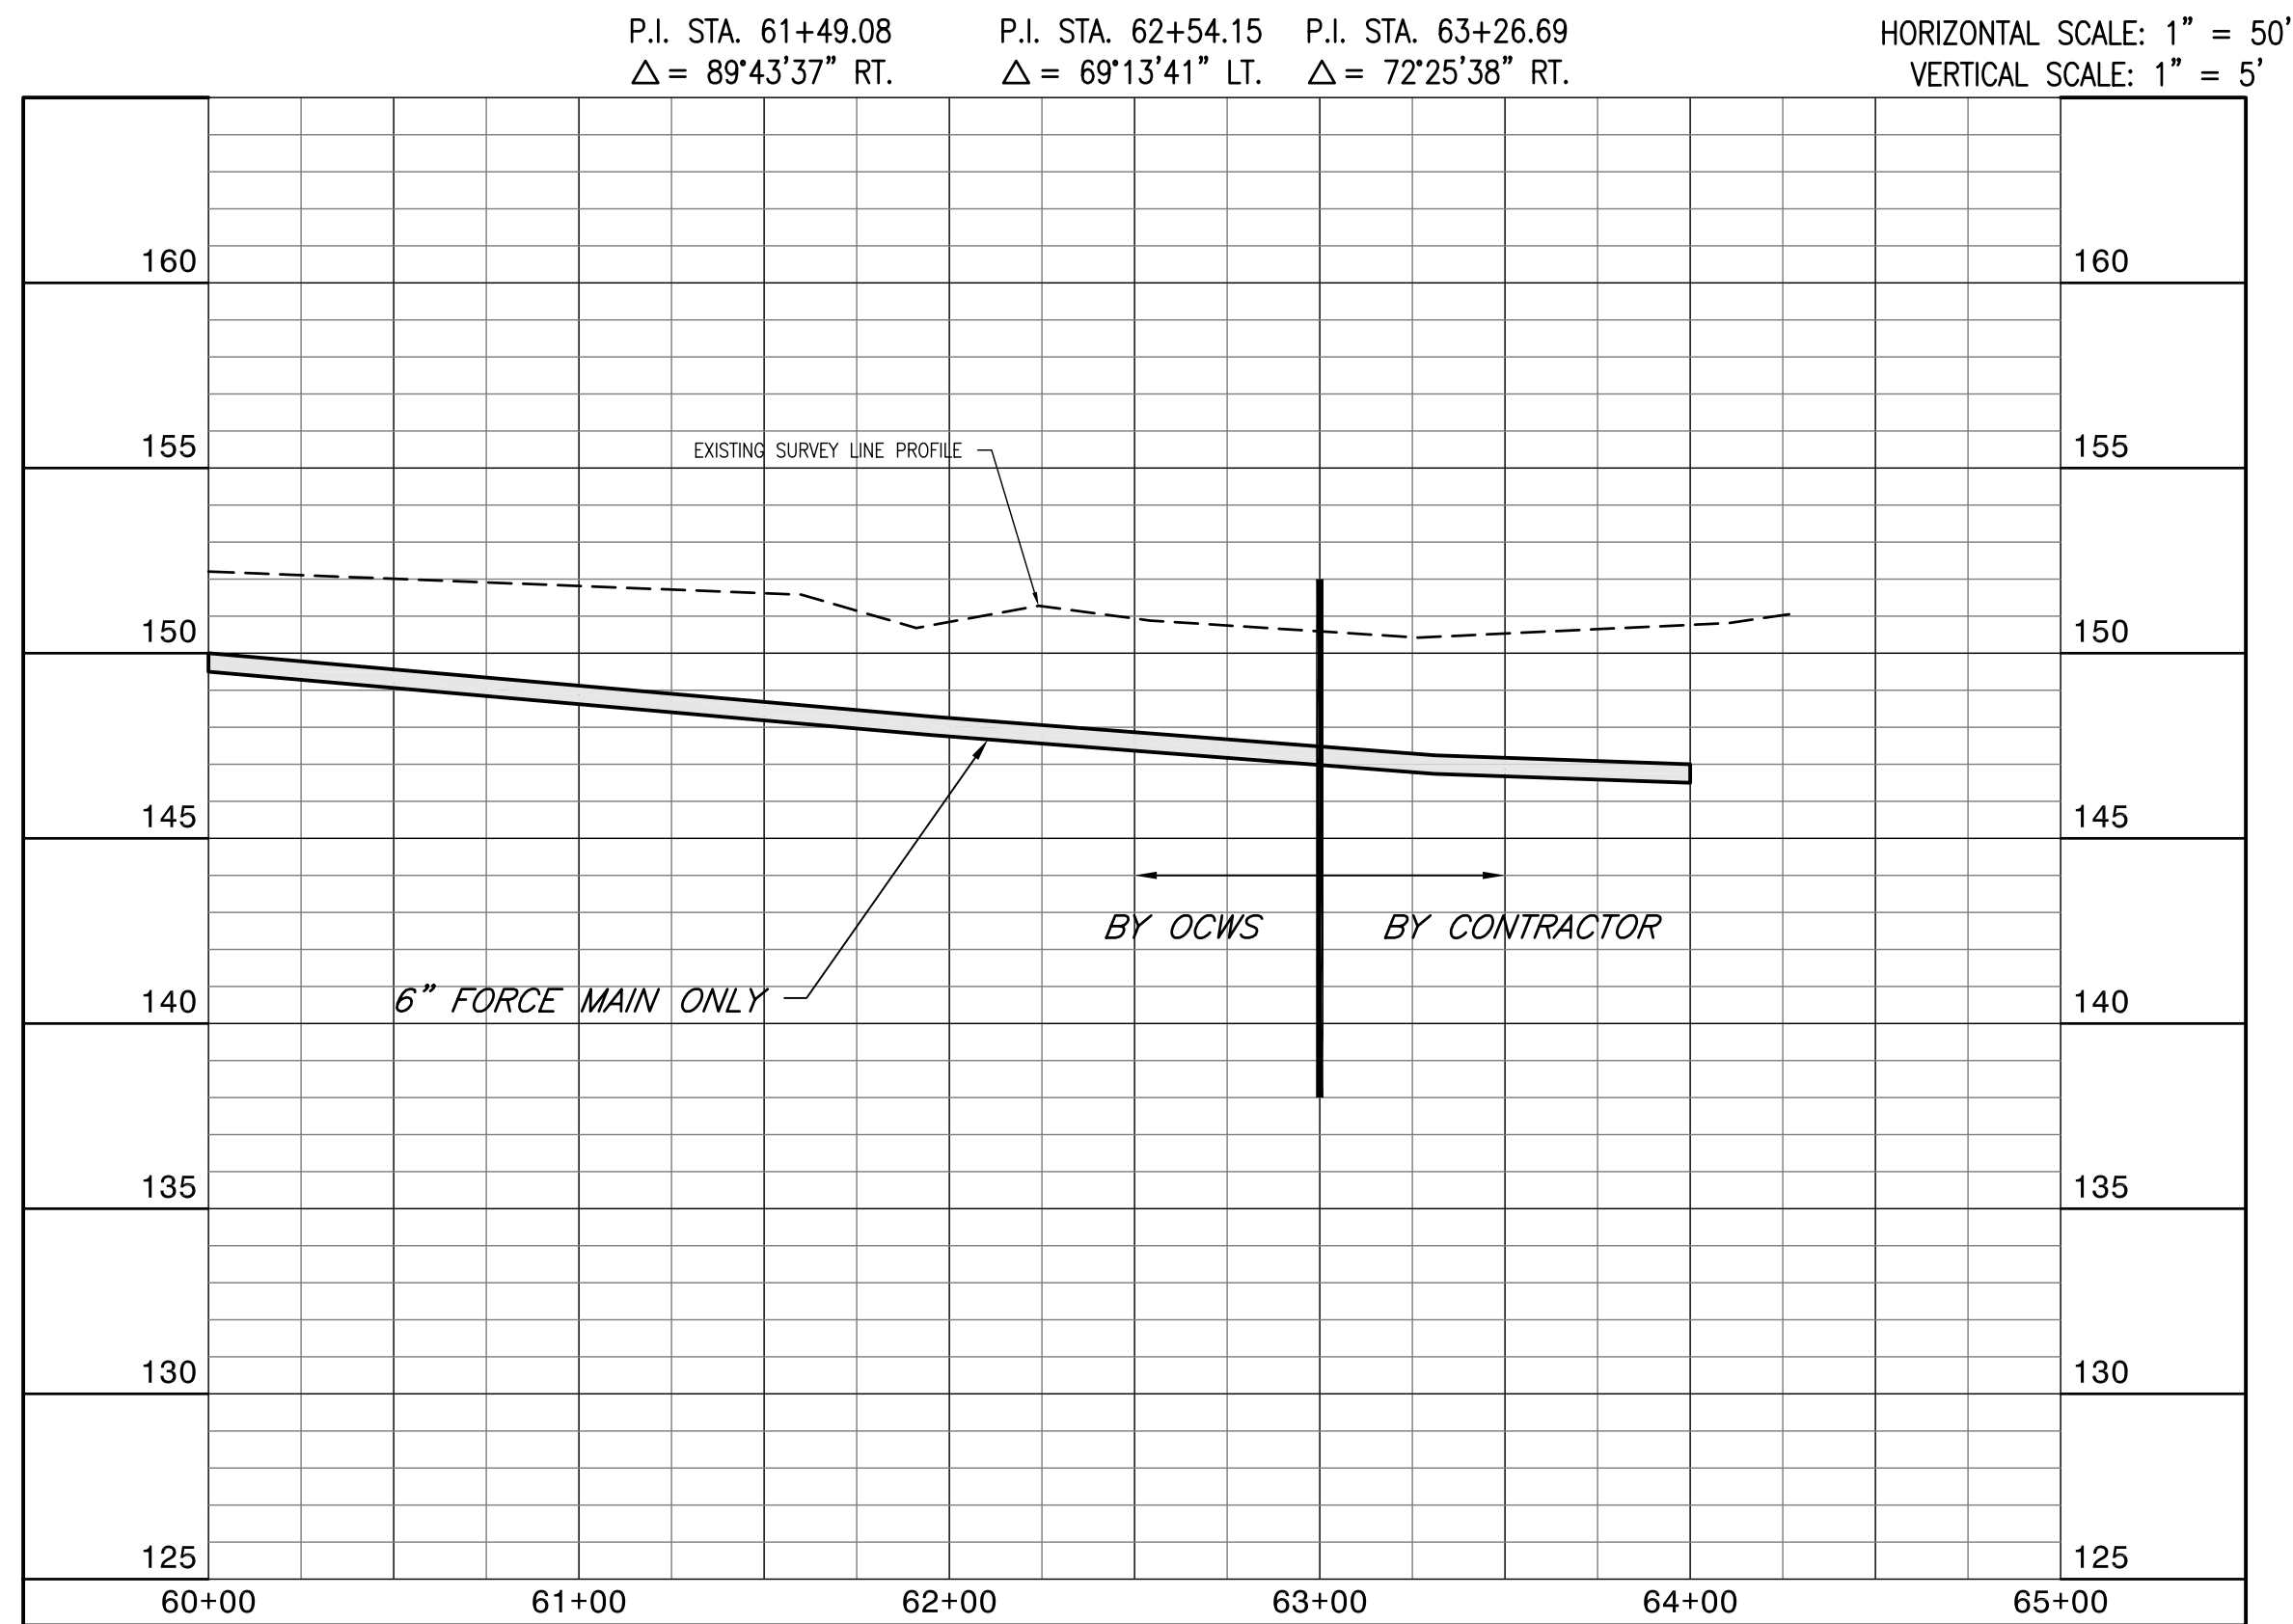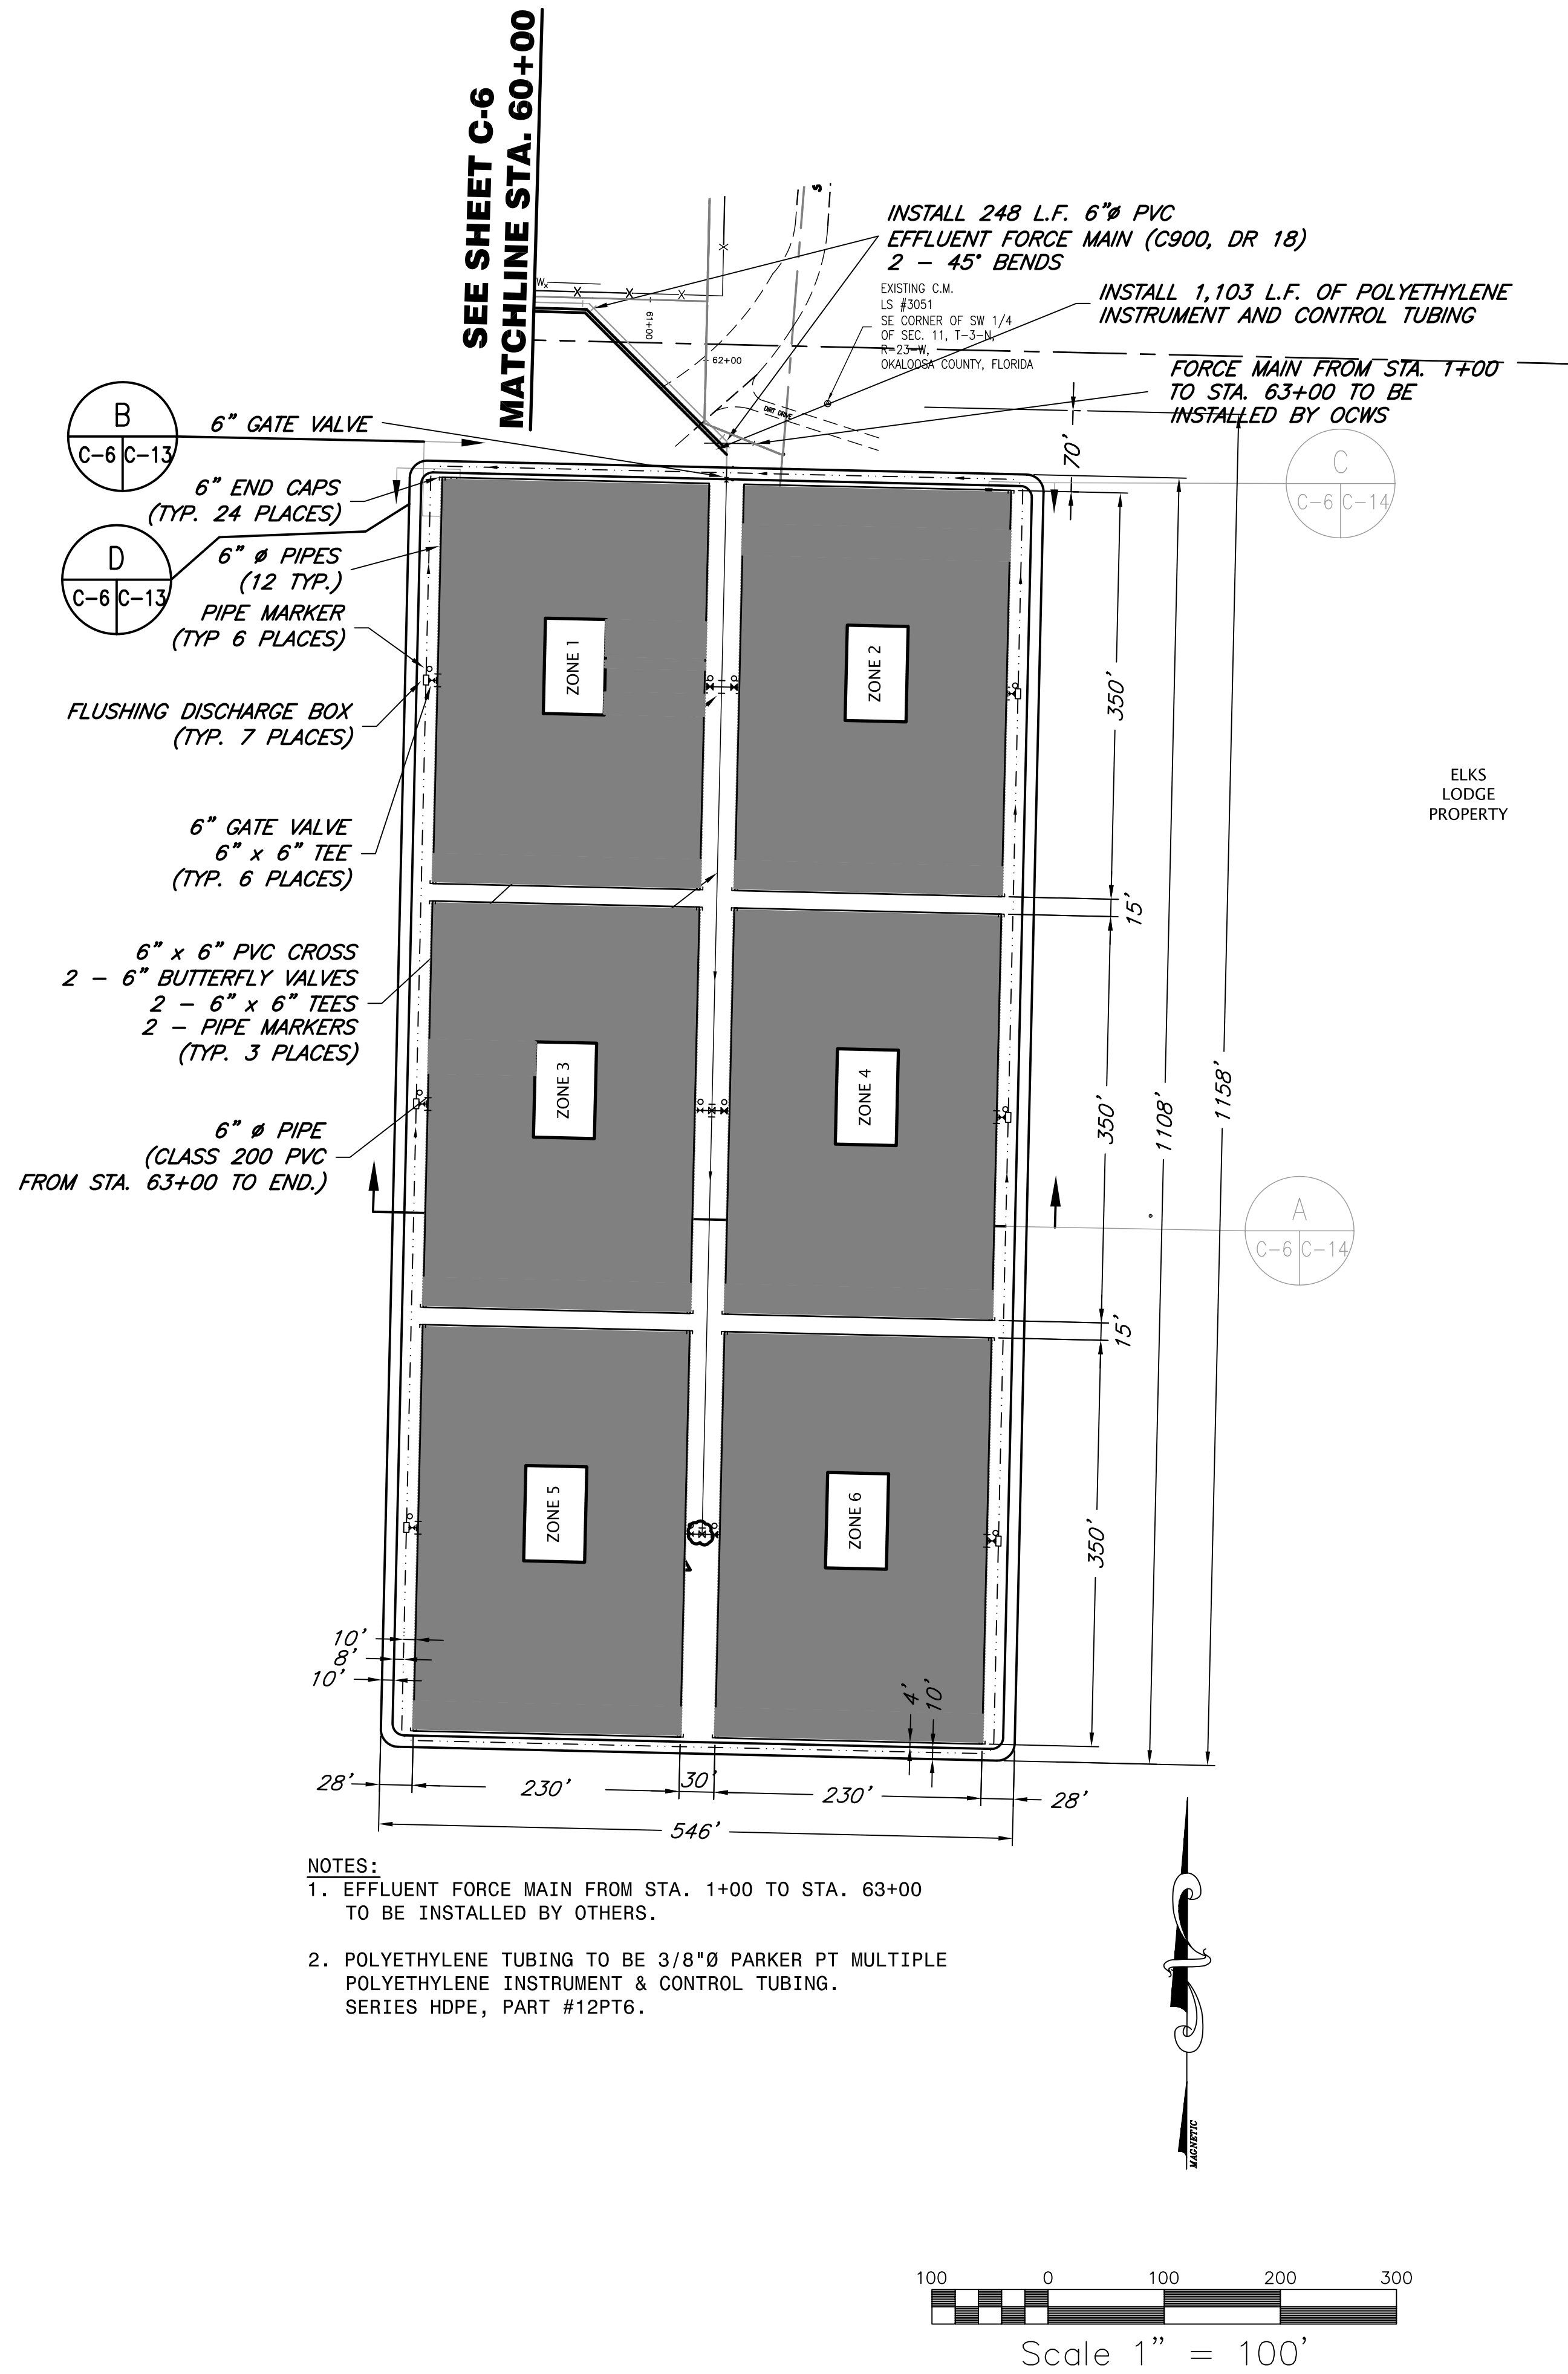

Cert. of Auth. No.
CA-1818

These drawings are copy-
righted and the property
of Polyengineering. Any
use, partial or full repro-
duction is prohibited
except by written Agree-
ment with Polyengineering

BOB SIKES PARK
WWTF EFFLUENT DISPOSAL
EXPANSION
PHASE II
OKALOOSA COUNTY WATER AND SEWER SYSTEM
OKALOOSA COUNTY, FLORIDA

POLYENGINEERING, INC.
ARCHITECTURE, ENGINEERING, SOLUTIONS

Post Office Box 841
102 Sunset Lane
Shalimar, Florida 32579
850-609-1100
WWW.POLYENGINEERING.COM

Revisions			
Key	Drawn By	Apprvd. By	Date
1			
2			
3			
4			

Field Book No.
0016

Drawn By
D.H./B.J.

Apprvd. By
B.B.

Date
FEBRUARY 2009



Project No.
41-264

Sheet title
ABSORPTION
BED LAYOUT


Sheet No

ENGINEER OF RECORD
BETH BRANT
REGISTRATION NUMBER
FL LIC. NO. 57972

C-6
6 OF 14

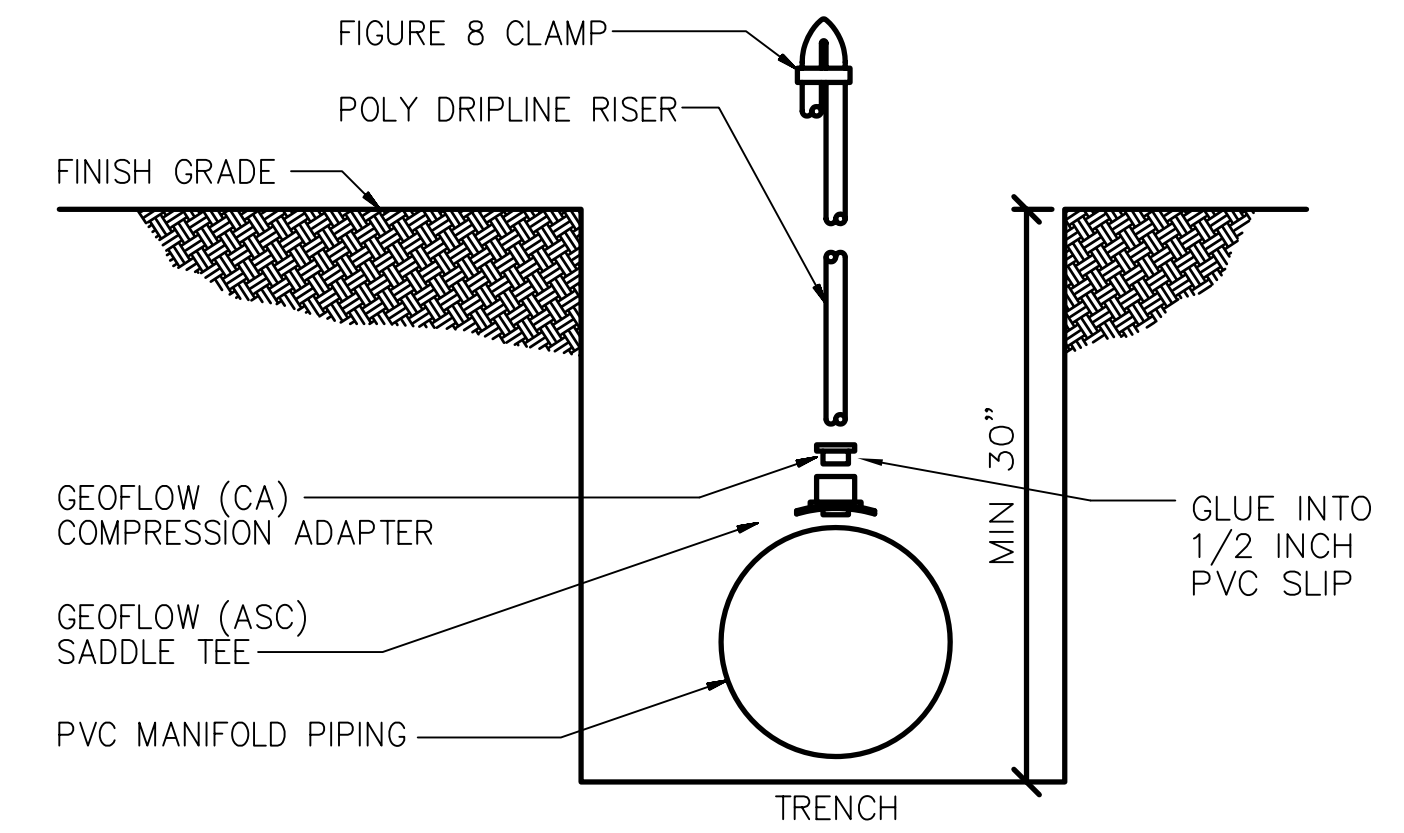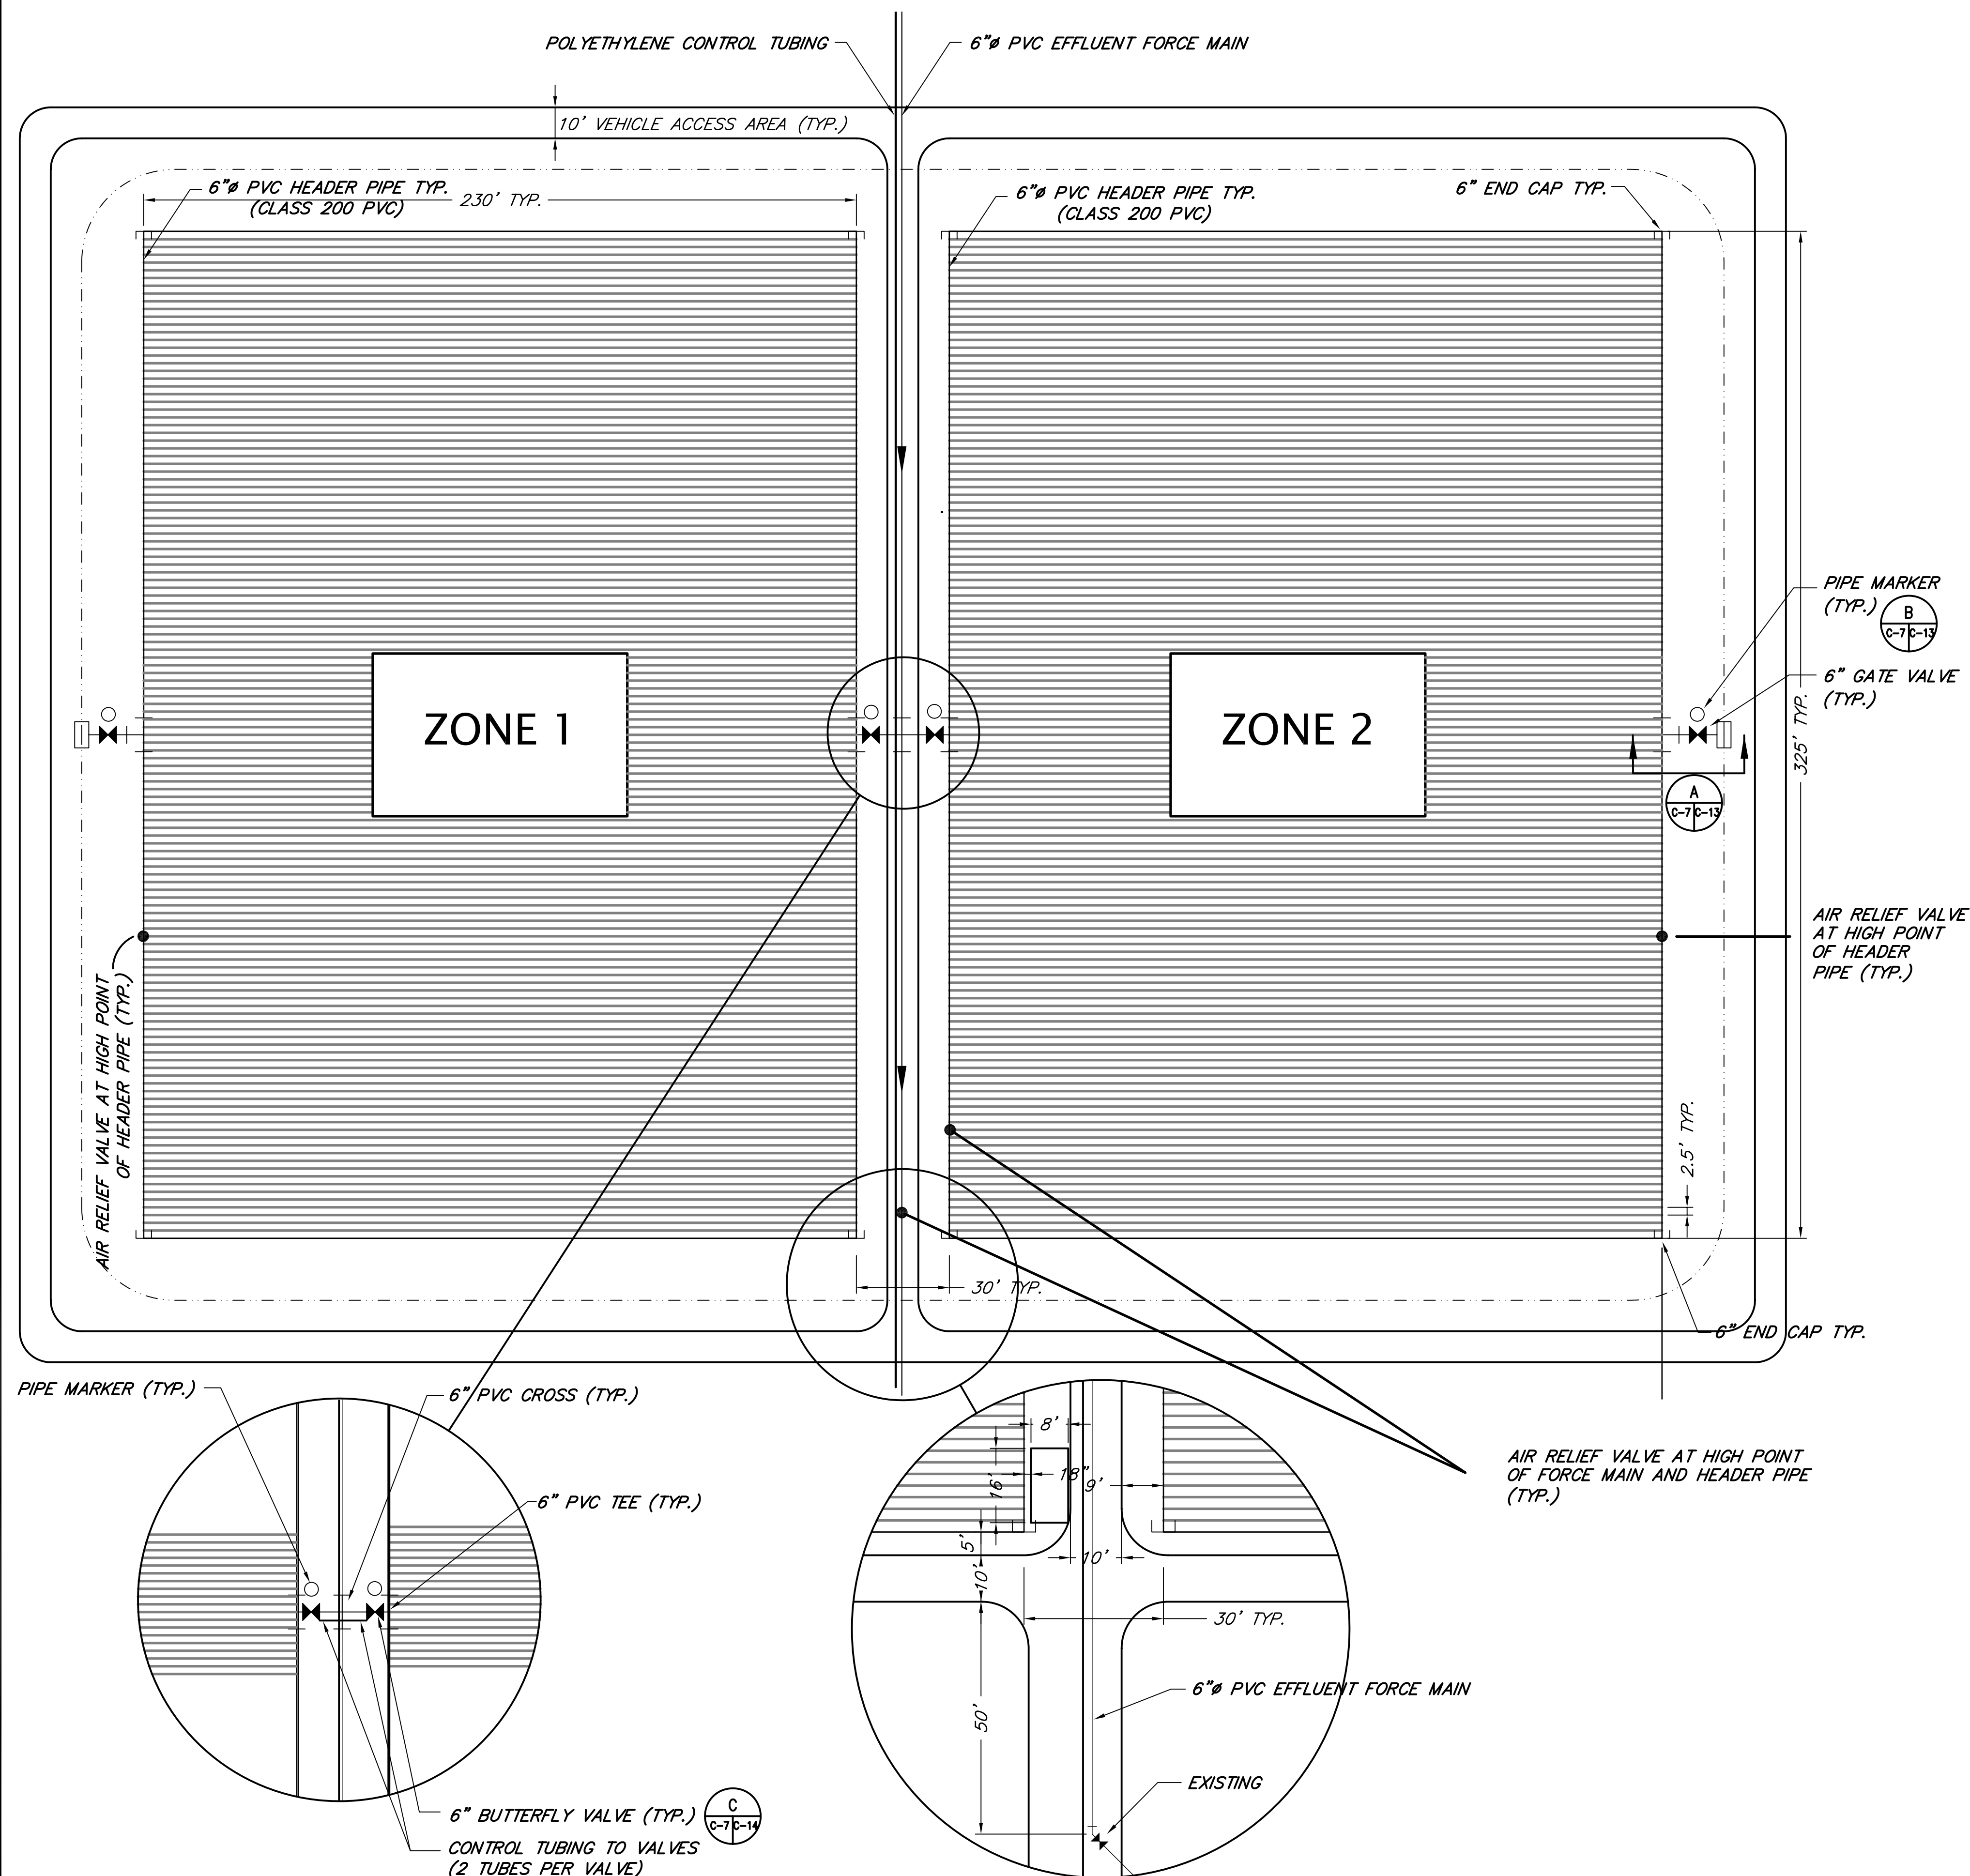

SADDLE TEE MANIFOLD (STEP #2)

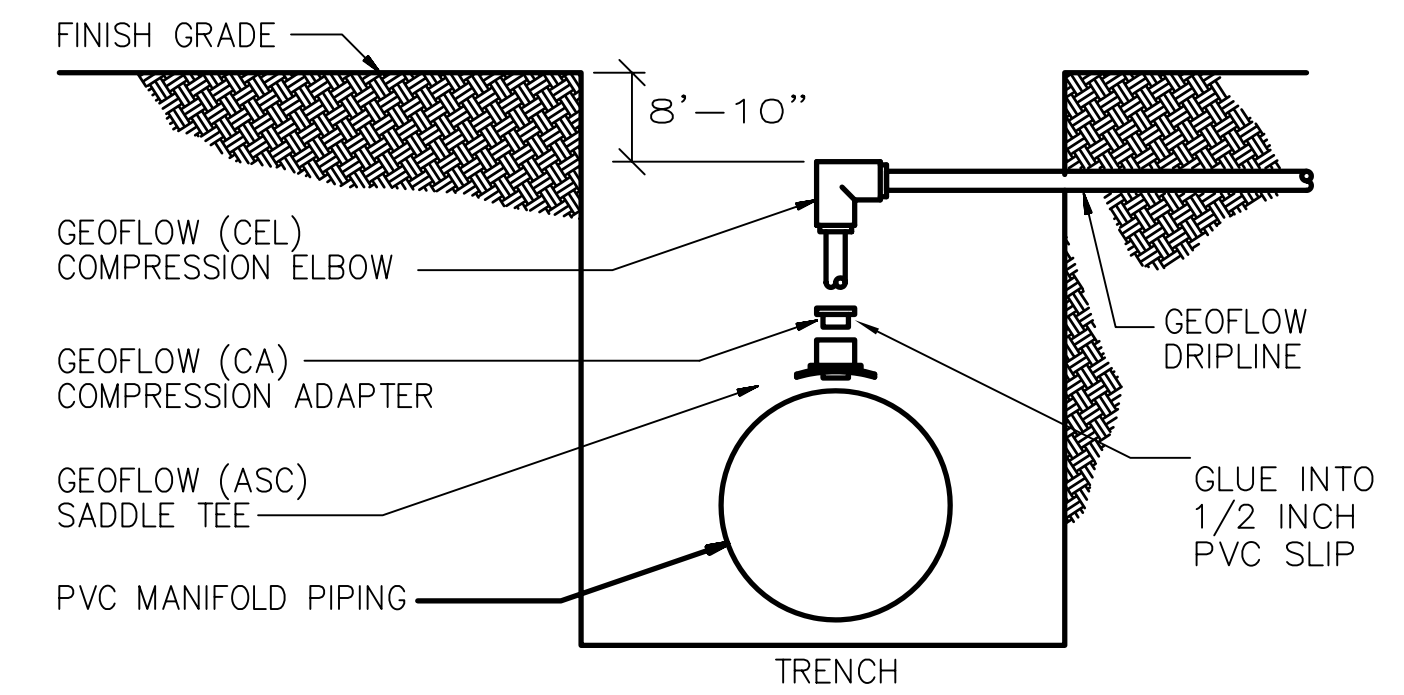

SADDLE TEE MANIFOLD (STEP #3)

- NOTES:
1. GEOFLOW IRRIGATION TUBING TO BE INSTALLED PRIOR TO 6" PVC MANIFOLD HEADER PIPES. (NOT SHOWN)
 2. INSTALL 6" HEADER PIPES AND GEOFLOW SADDLE TEE, COMPRESSION ADAPTER AND RISER INTO PRE-DRILLED HOLES (IN 6" PVC) AS SHOWN IN STEP #2.
 3. ATTACH GEOFLOW TUBING TO RISER USING GEOFLOW COMPRESSION ELBOW AS SHOWN IN STEP #3.

Revisions			
Key	Drawn By	Apprvd. By	Date
1			
2			
3			
4			

Field Book No.
0016

Drawn By D.H./B.J.	Apprvd. By B.B.
-----------------------	--------------------

Date
FEBRUARY 2009

Project No.
41-264

Sheet title


ABSORPTION
BED LAYOUT

Sheet No

C-7
7 OF 14

ENGINEER OF RECORD
BETH BRANT
REGISTRATION NUMBER
FL LIC. NO. 57972

Polyengineering, Inc. - G:\CLEANSTUFF-29-999\41264\CrestView WWTF Operating Permit\WP\PHASE I\41264-C1-C5 ORIG-LAYOUT.dwg [C8] Last Printed: March 13, 2009 - 10:04am By: Alderman

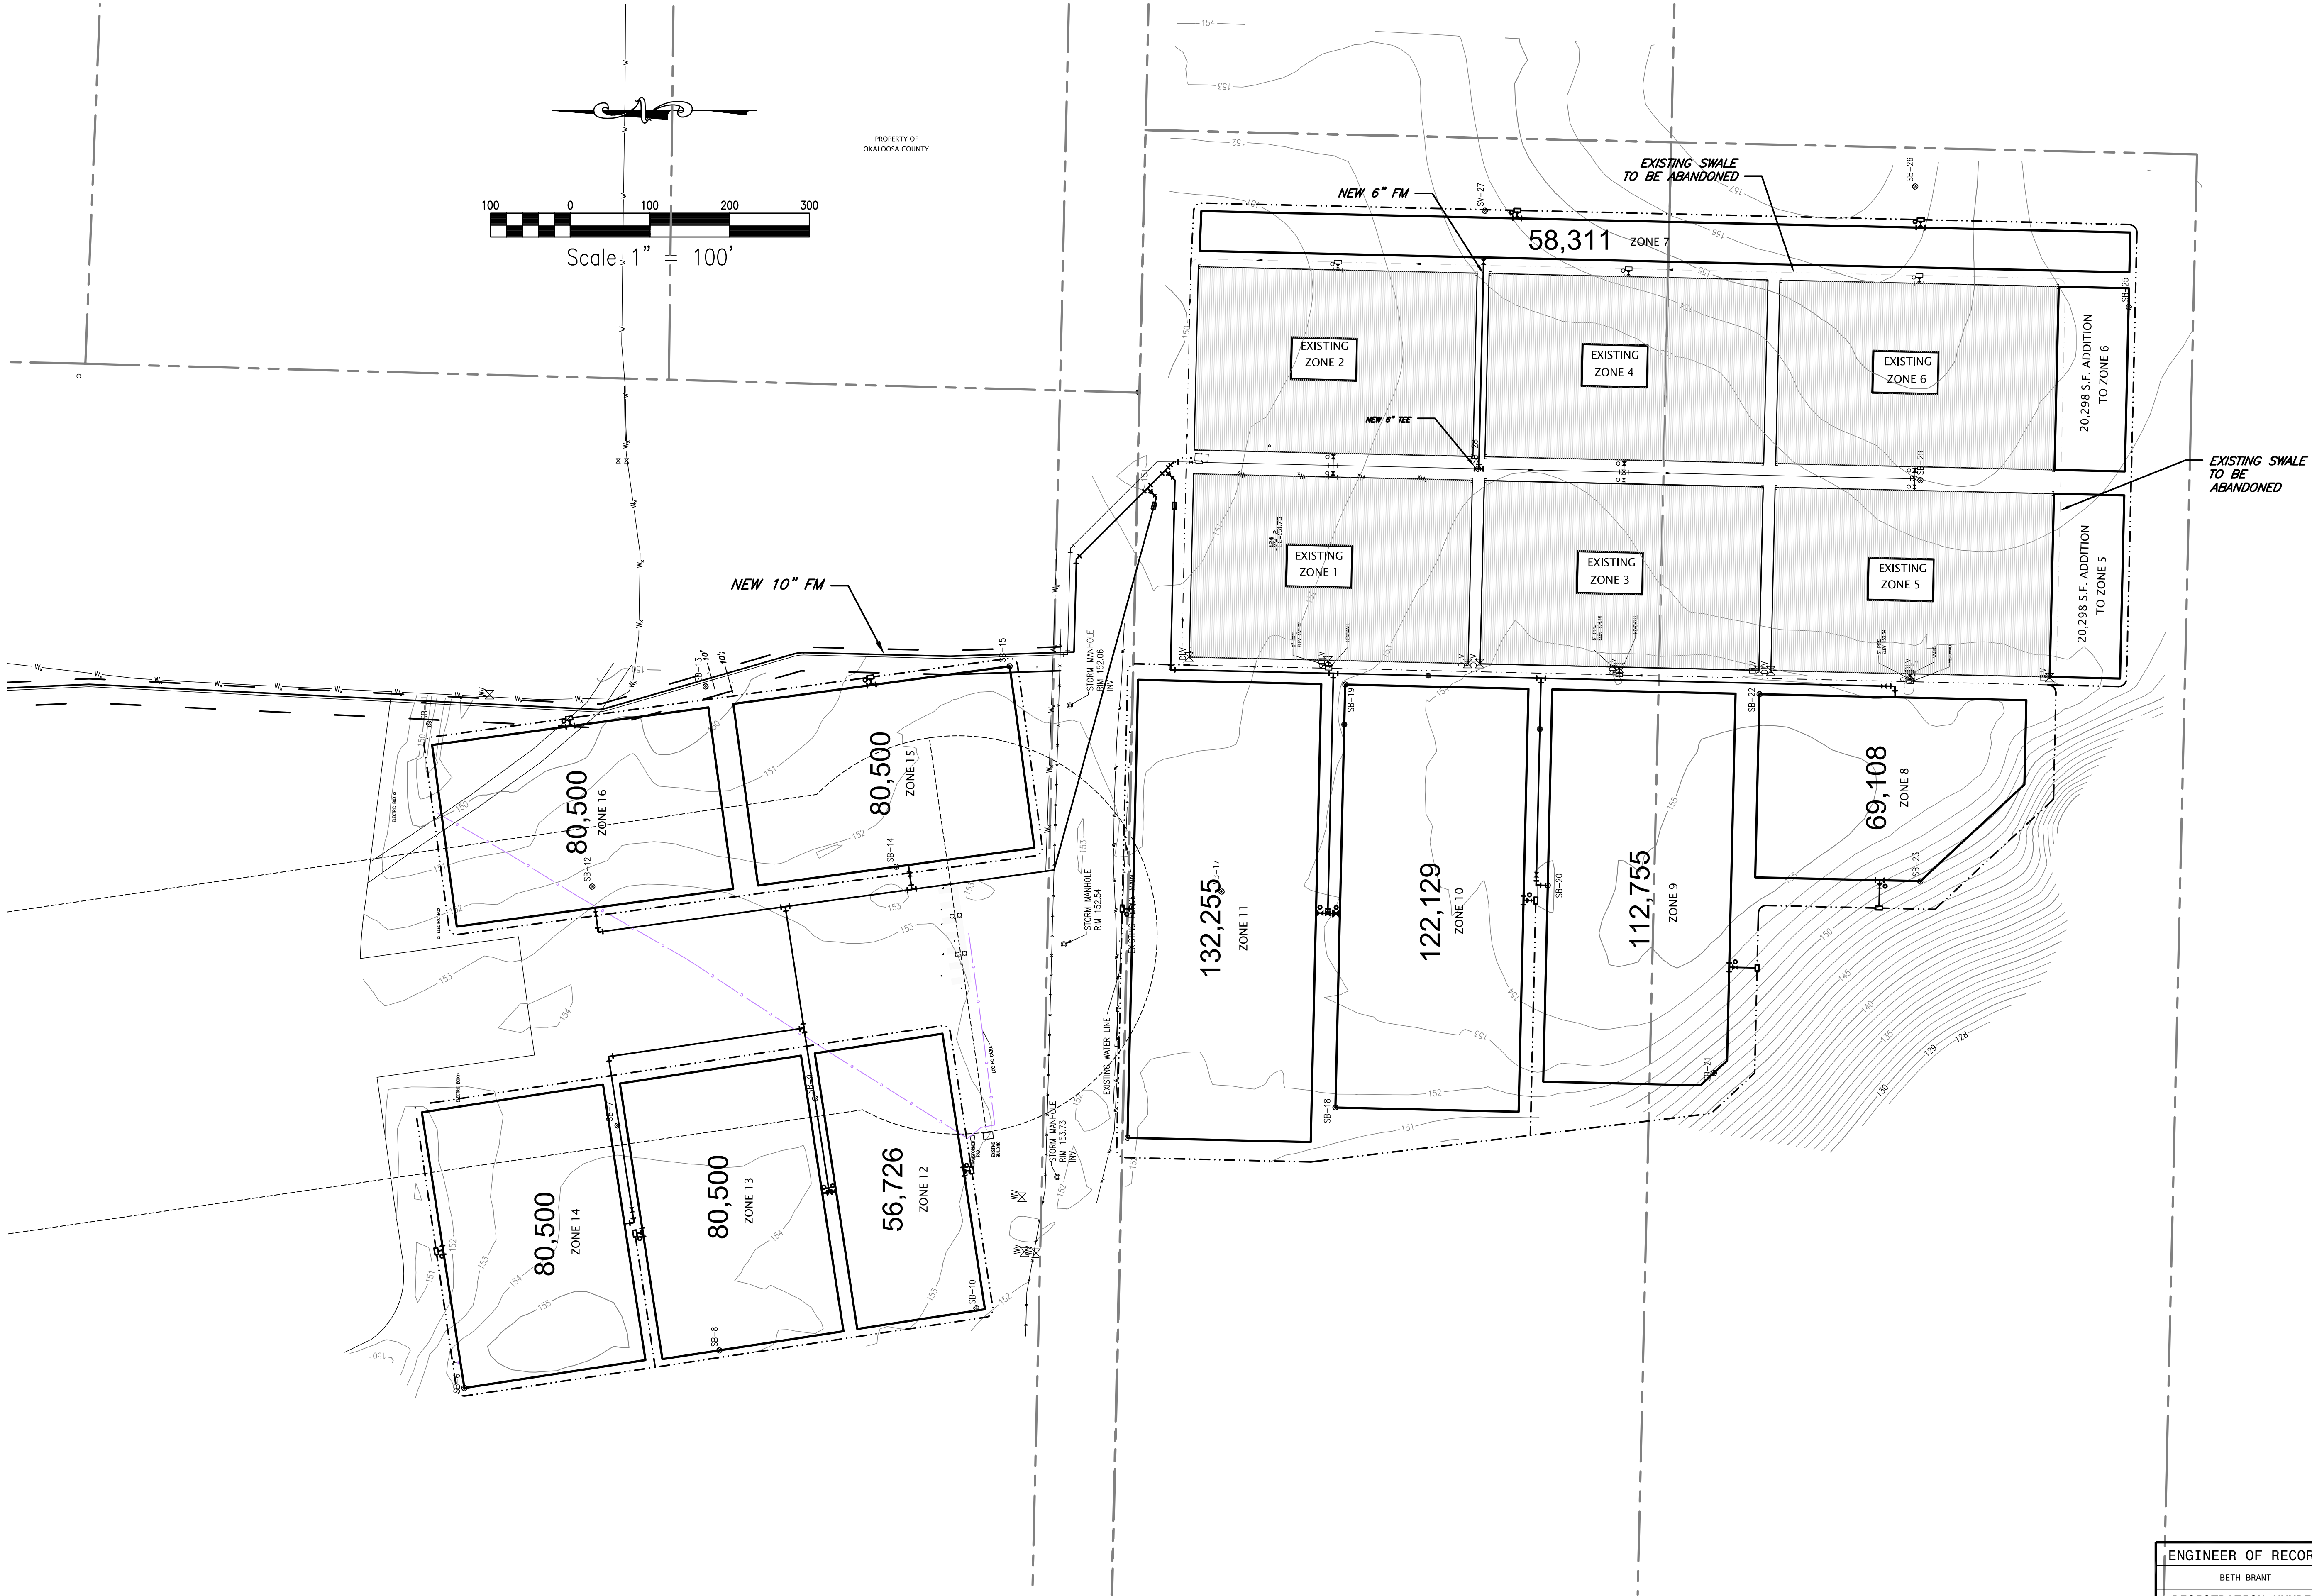

ENGINEER OF RECORD	
BETH BRANT	
REGISTRATION NUMBER	
FL LIC. NO. 57972	

Cert. of Auth. No.
CA-1818

These drawings are copy-
righted and the property
of Polyengineering. Any
use, partial or full repro-
duction is prohibited
except by written Agree-
ment with Polyengineering

BOB SIKES PARK
WWTF EFFLUENT DISPOSAL
EXPANSION
PHASE II
OKALOOSA COUNTY WATER AND SEWER SYSTEM
OKALOOSA COUNTY, FLORIDA

POLYENGINEERING, INC.
ARCHITECTURE, ENGINEERING, SOLUTIONS

Post Office Box 841
102 SUNSET LANE
SHALIMAR, FLORIDA 32579
850-609-1100
WWW.POLYENGINEERING.COM

Revisions			
Key	Drawn By	Apprvd. By	Date
1			
2			
3			
4			

Field Book No.

Drawn By
DH

Apprvd. By
BB

Date
FEBRUARY 2009

 

Project No.
41-264

Sheet title
ABSORPTION BED
OVERALL LAYOUT

Sheet No

C-8
8 OF 14

Polyengineering, Inc. - C:\CLEANSTUFF-29-999\41264 CrestView WWTF Operating Permit\WP\PHASE I\41264-C1-C5 ORIG-LAYOUT.dwg [C9] Last Printed: March 13, 2009 - 10:04am By: Alderman

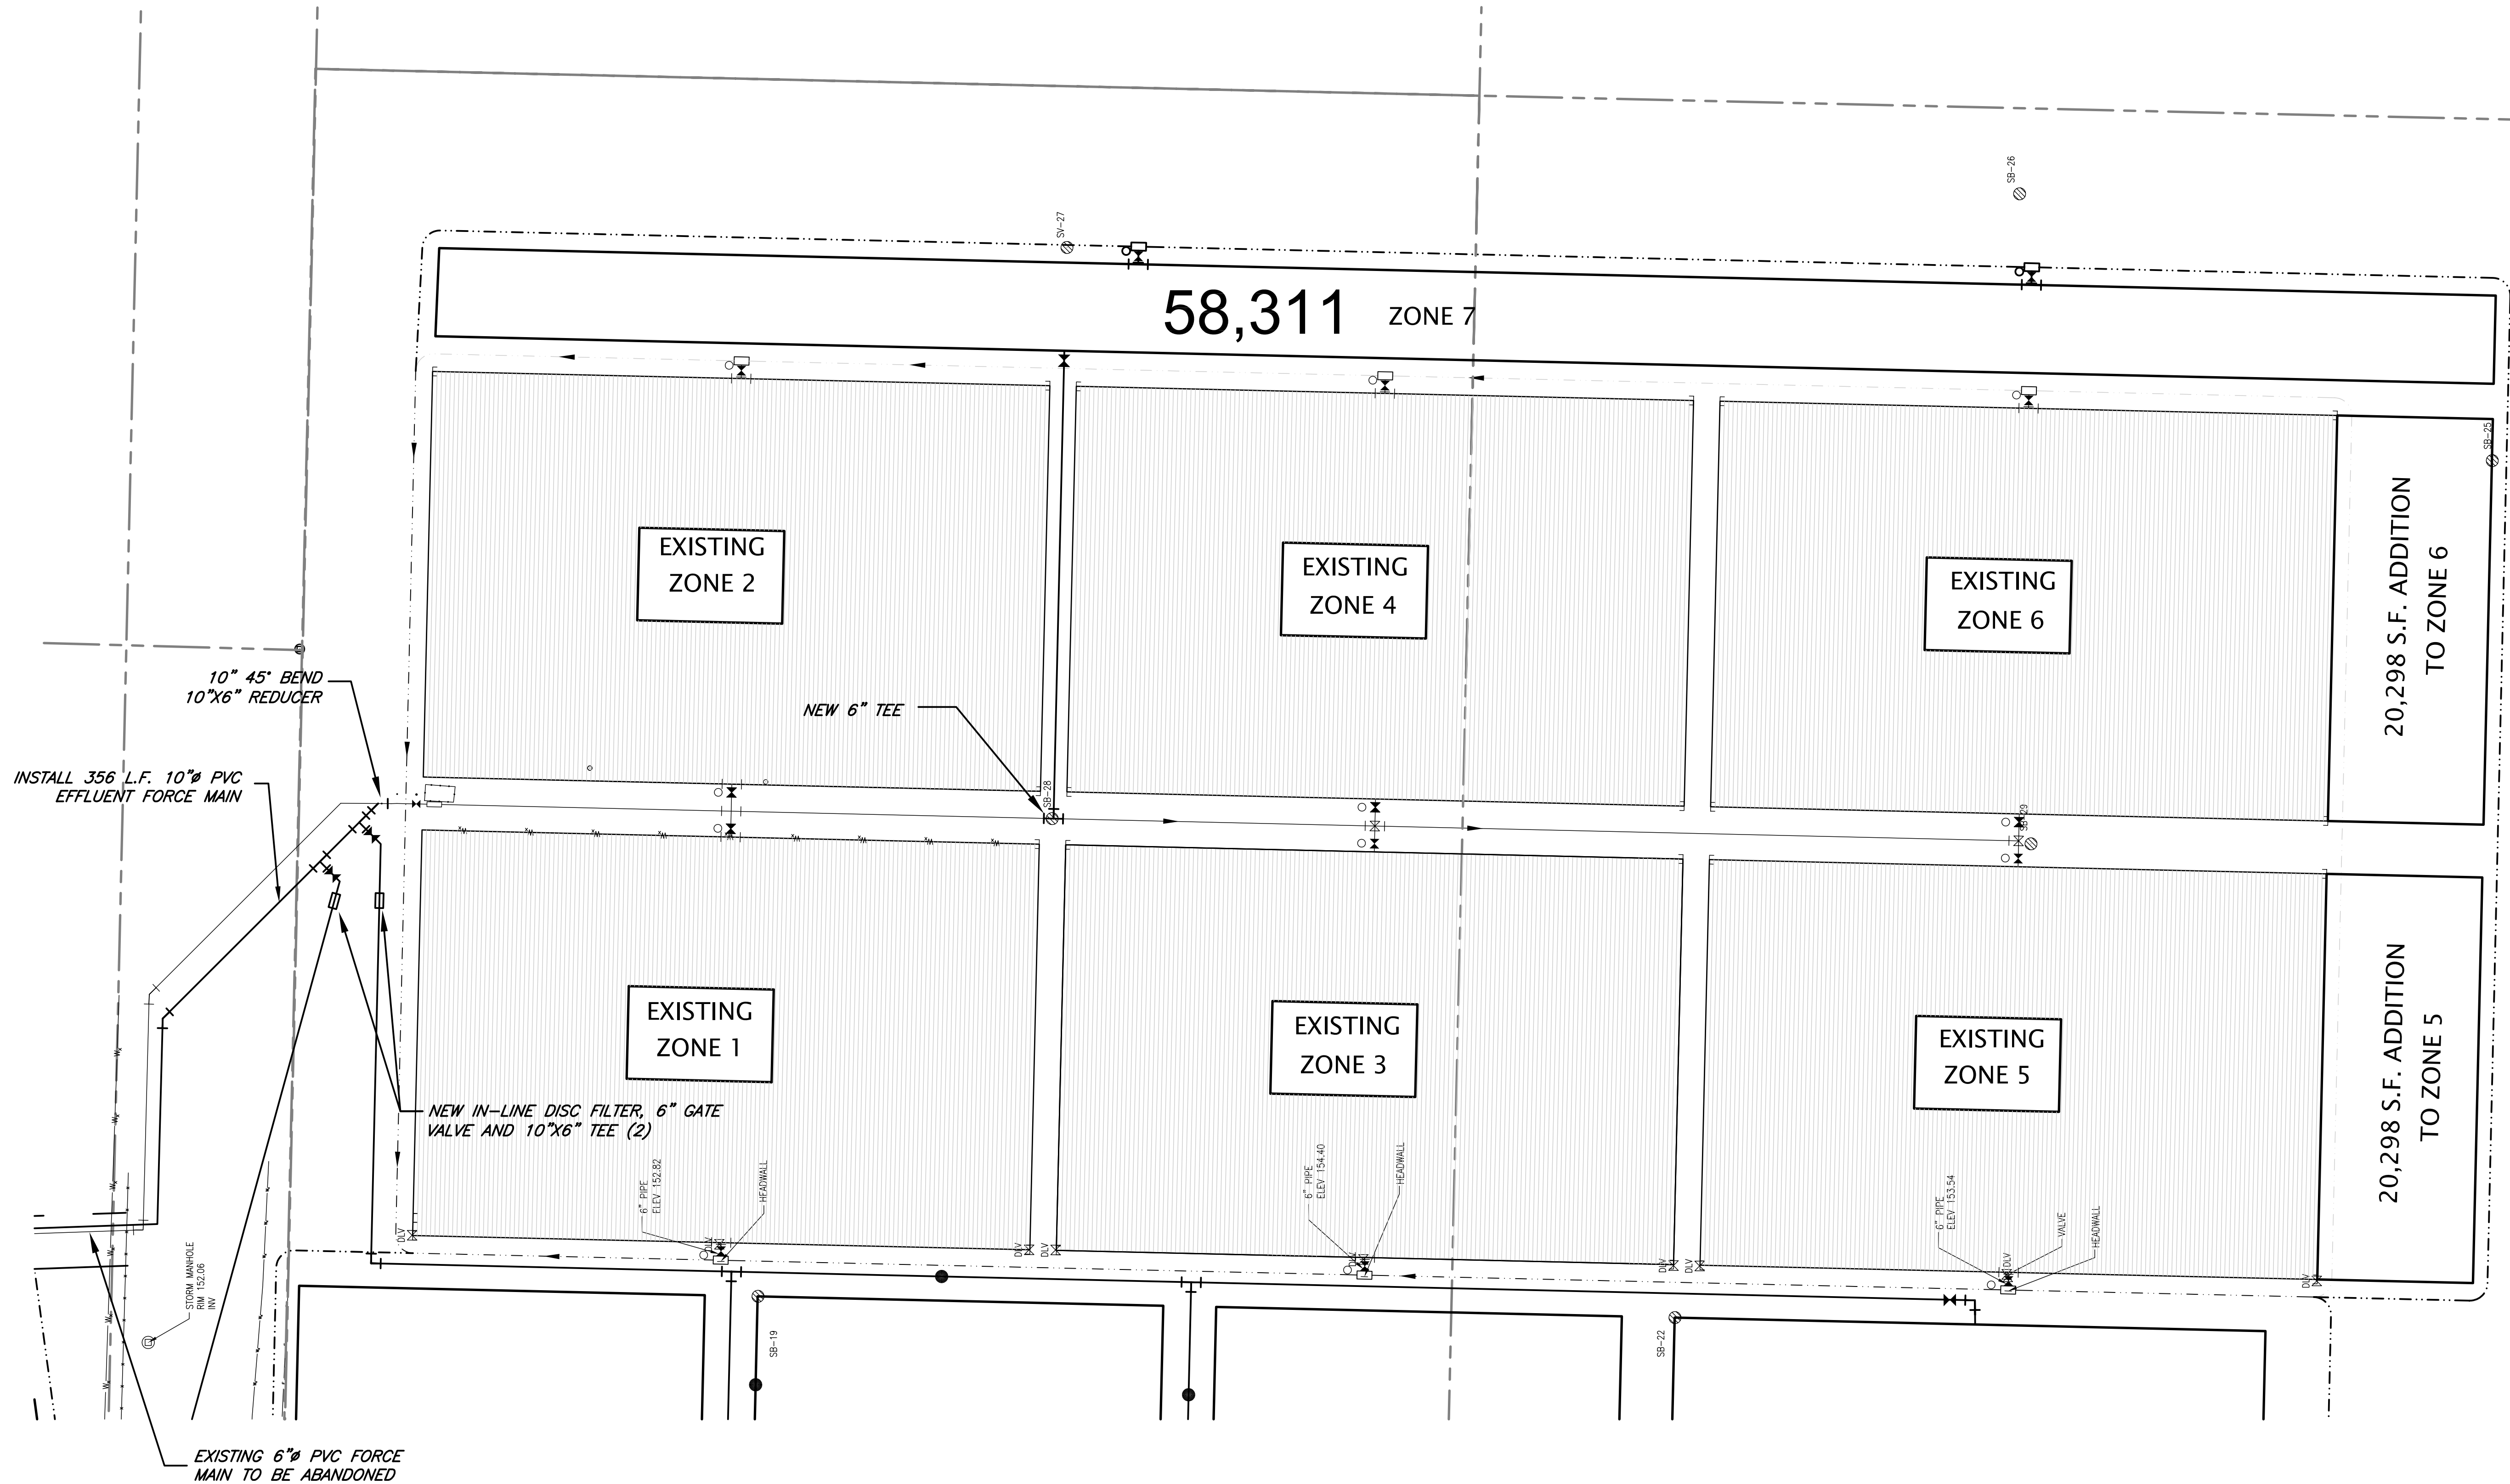

Scale 1" = 50'


ENGINEER OF RECORD	
BETH BRANT	
REGISTRATION NUMBER	
FL LIC. NO. 57972	

Cert. of Auth. No.
CA-1818

These drawings are copy-
righted and the property
of Polyengineering. Any
use, partial or full repro-
duction is prohibited
except by written Agree-
ment with Polyengineering

BOB SIKES PARK
WWTF EFFLUENT DISPOSAL
EXPANSION
PHASE II
OKALOOSA COUNTY WATER AND SEWER SYSTEM
OKALOOSA COUNTY, FLORIDA

POLYENGINEERING, INC.
ARCHITECTURE, ENGINEERING, SOLUTIONS
Post Office Box 841
102 Sunset Lane
Shalimar, Florida 32579
850-609-1100
WWW.POLYENGINEERING.COM

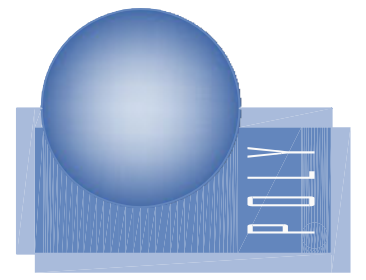

Revisions			
Key	Rev	By	Date
1			
2			
3			
4			

Field Book No.

Drawn By
DH

Apprvd. By
BB



Date
FEBRUARY 2009

Project No.
41-264

Sheet title
ABSORPTION BEDS

Sheet No

C-9
9 OF 14

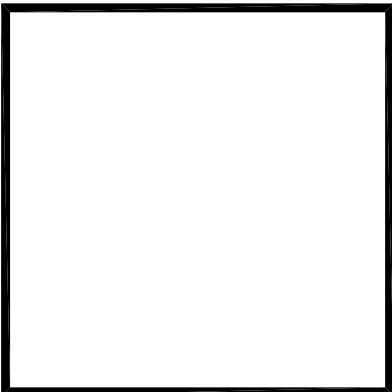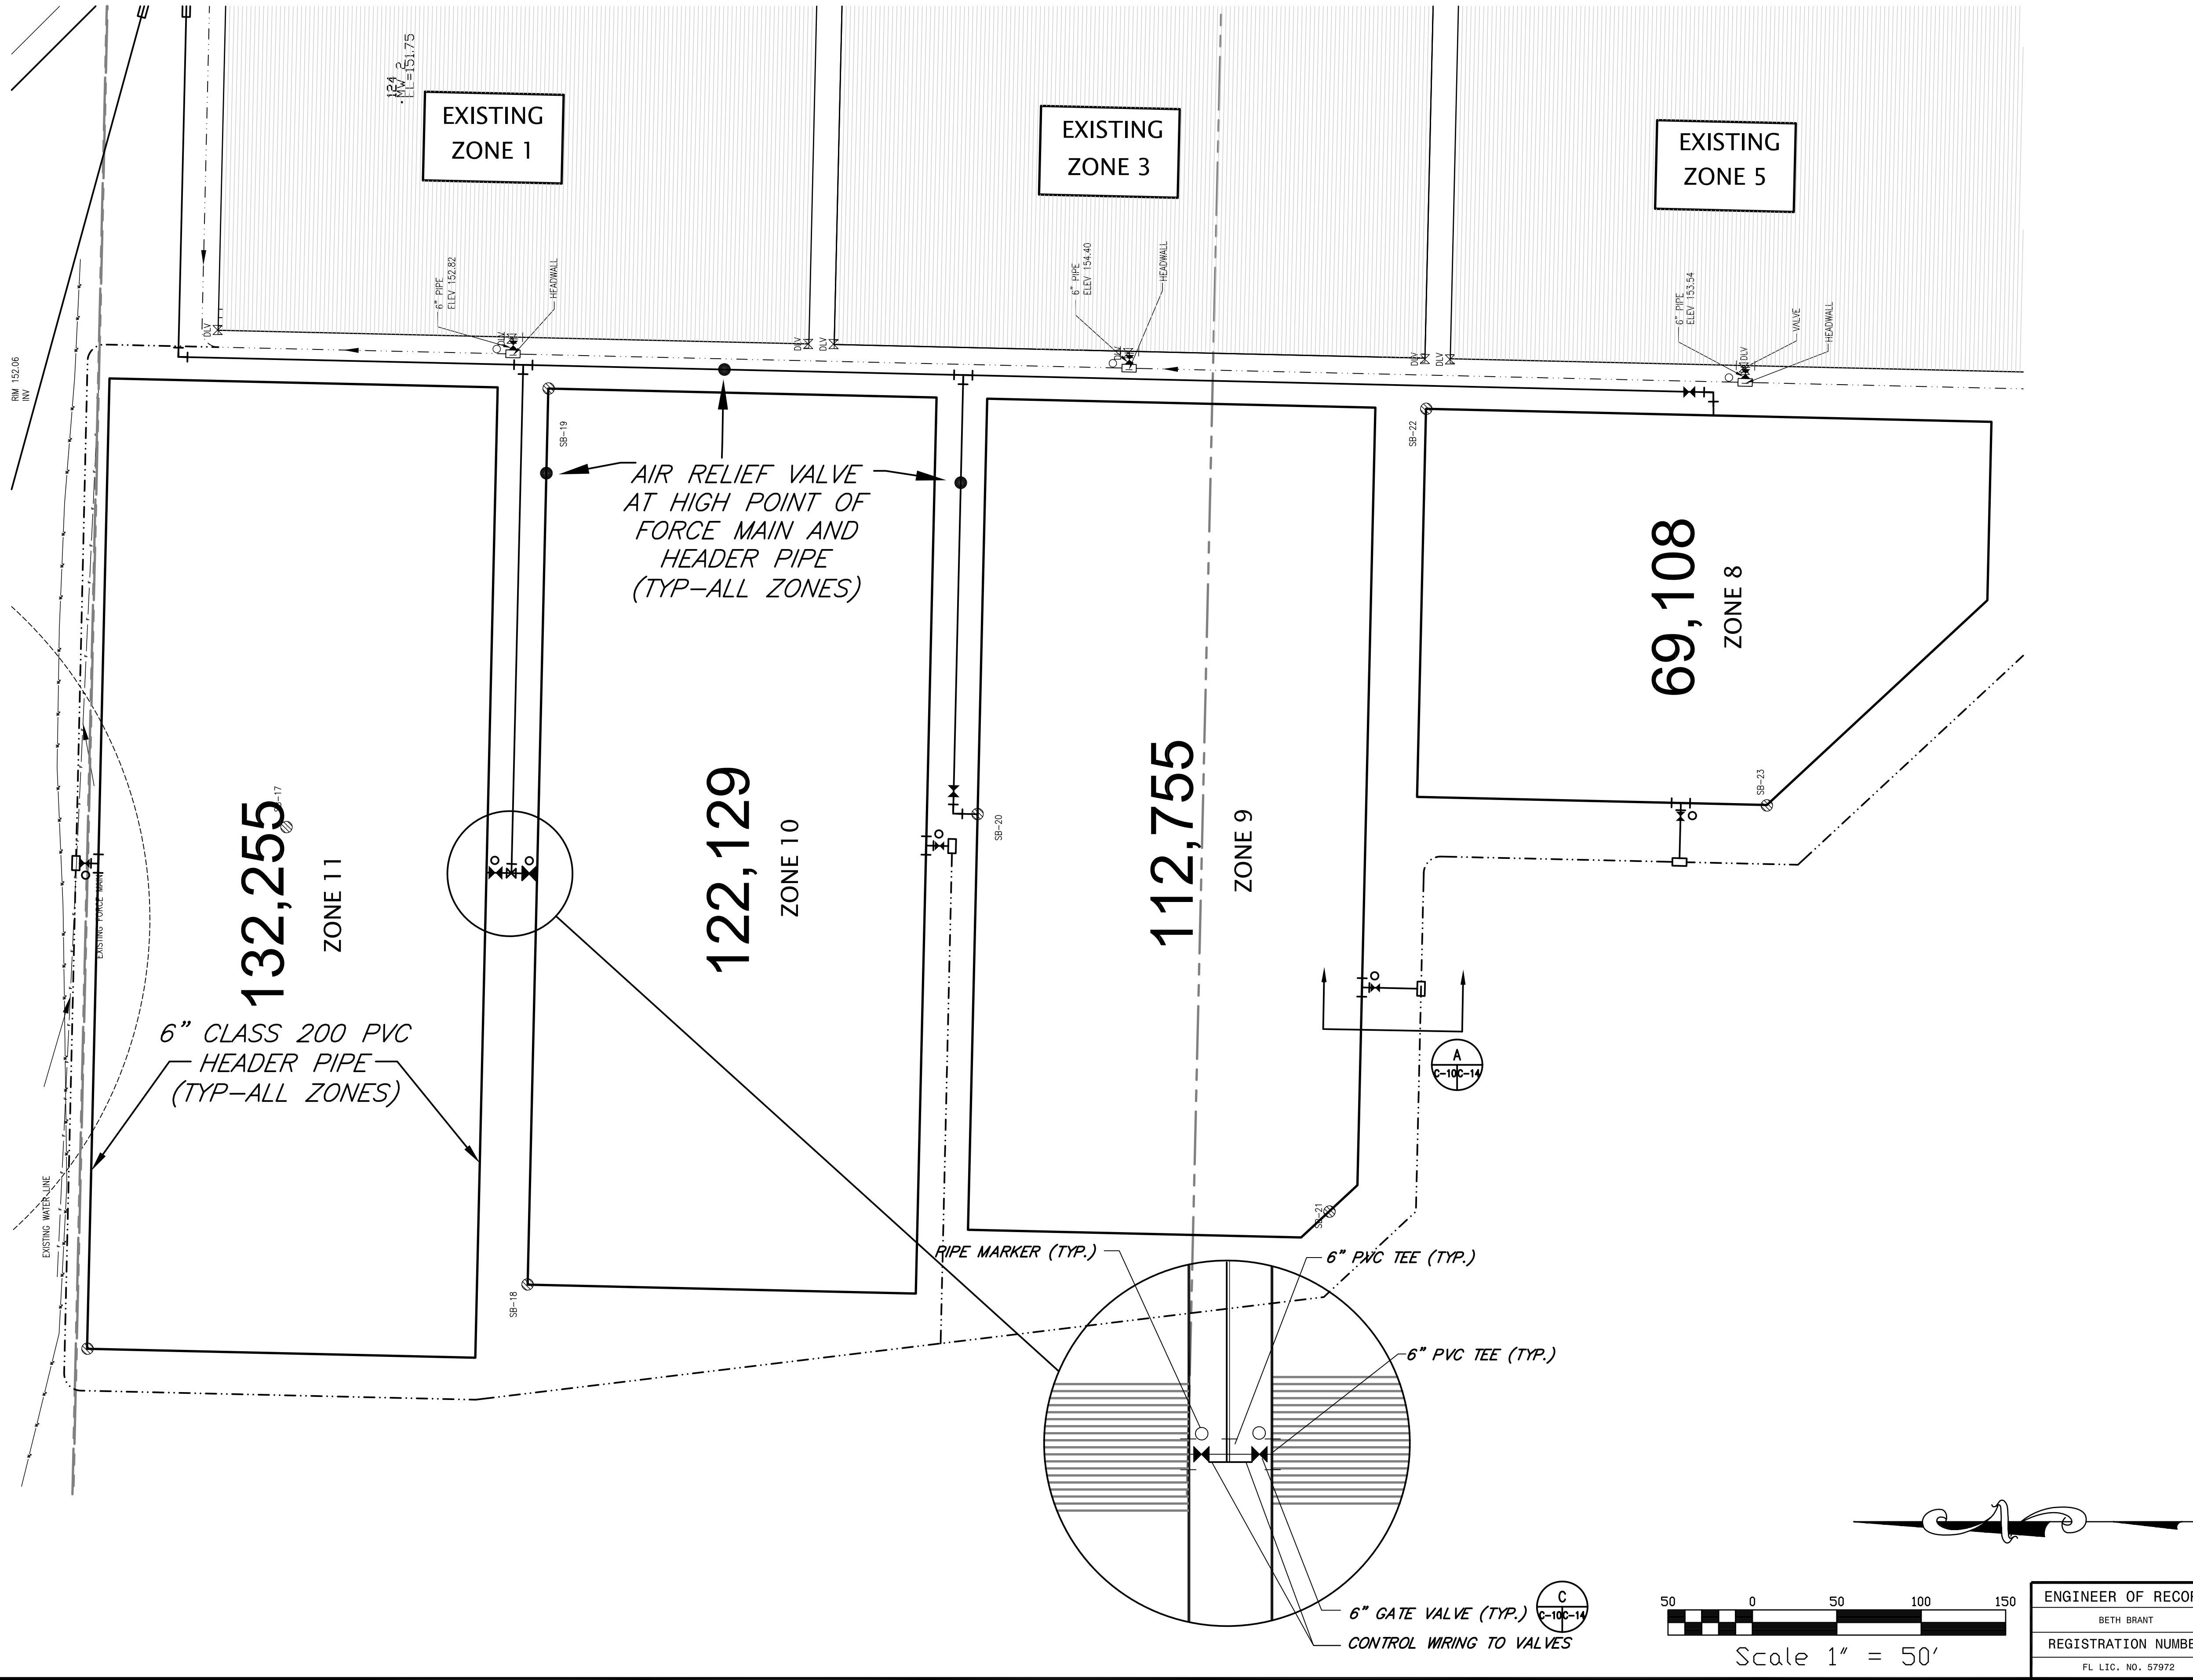

Cert. of Auth. No.
CA-1818

These drawings are copy-
righted and the property
of Polyengineering. Any
use, partial or full repro-
duction is prohibited
except by written Agree-
ment with Polyengineering

BOB SIKES PARK
WWTF EFFLUENT DISPOSAL
EXPANSION
PHASE II
OKALOOSA COUNTY WATER AND SEWER SYSTEM
OKALOOSA COUNTY, FLORIDA

POLYENGINEERING, INC.
ARCHITECTURE, ENGINEERING, SOLUTIONS

Post Office Box 841
102 SUNSET LANE
SHALIMAR, FLORIDA 32579
850-609-1100
WWW.POLYENGINEERING.COM

Revisions			
Key	Revised By	Apprvd. By	Date
1			
2			
3			
4			

Field Book No.

Drawn By
DH

Apprvd. By
BB

Date
FEBRUARY 2009

Project No.
41-264

Sheet title
ABSORPTION BEDS

Sheet No
C-10
10 OF 14


Polyengineering, Inc. - G:\CLEANSTUFF-29-999\41264 Crestview WWTF Operating Permit\WP\PHASE I\41264-C1-C5 ORIG-LAYOUT.dwg [C1] Last Printed: March 13, 2009 - 10:05am By: Alderman



Cert. of Auth. No.
CA-1818

These drawings are copy-
righted and the property
of Polyengineering. Any
use, partial or full repro-
duction is prohibited
except by written Agree-
ment with Polyengineering

BOB SIKES PARK
WWTF EFFLUENT DISPOSAL
EXPANSION
PHASE II
OKALOOSA COUNTY WATER AND SEWER SYSTEM
OKALOOSA COUNTY, FLORIDA

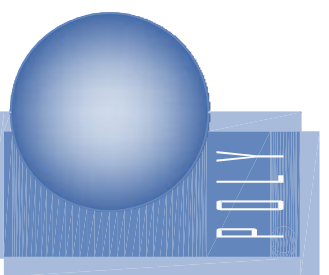

POLYENGINEERING, INC.
ARCHITECTURE, ENGINEERING, SOLUTIONS

Post Office Box 841
102 SUNSET LANE
SHALIMAR, FLORIDA 32579
850-609-1100
WWW.POLYENGINEERING.COM

Revisions				
Key	Revised By	Apprvd. By	Date	
1				
2				
3				
4				

Field Book No.

Drawn By
DH

Apprvd. By
BB

Date
FEBRUARY 2009

Project No.
41-264



Sheet title
ABSORPTION BEDS

Sheet No


C-11
11 OF 14

ENGINEER OF RECORD
BETH BRANT
REGISTRATION NUMBER
FL LIC. NO. 57972

Polyengineering, Inc. - C:\CLEANSTUFF-29-999\41264 CrestView WWTF Operating Permit\WP\PHASE I\41264-C1-C5 ORIG-LAYOUT.dwg [C12] Last Printed: March 13, 2009 - 10:06am By: Alderman

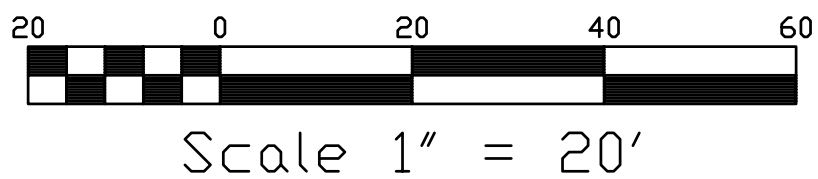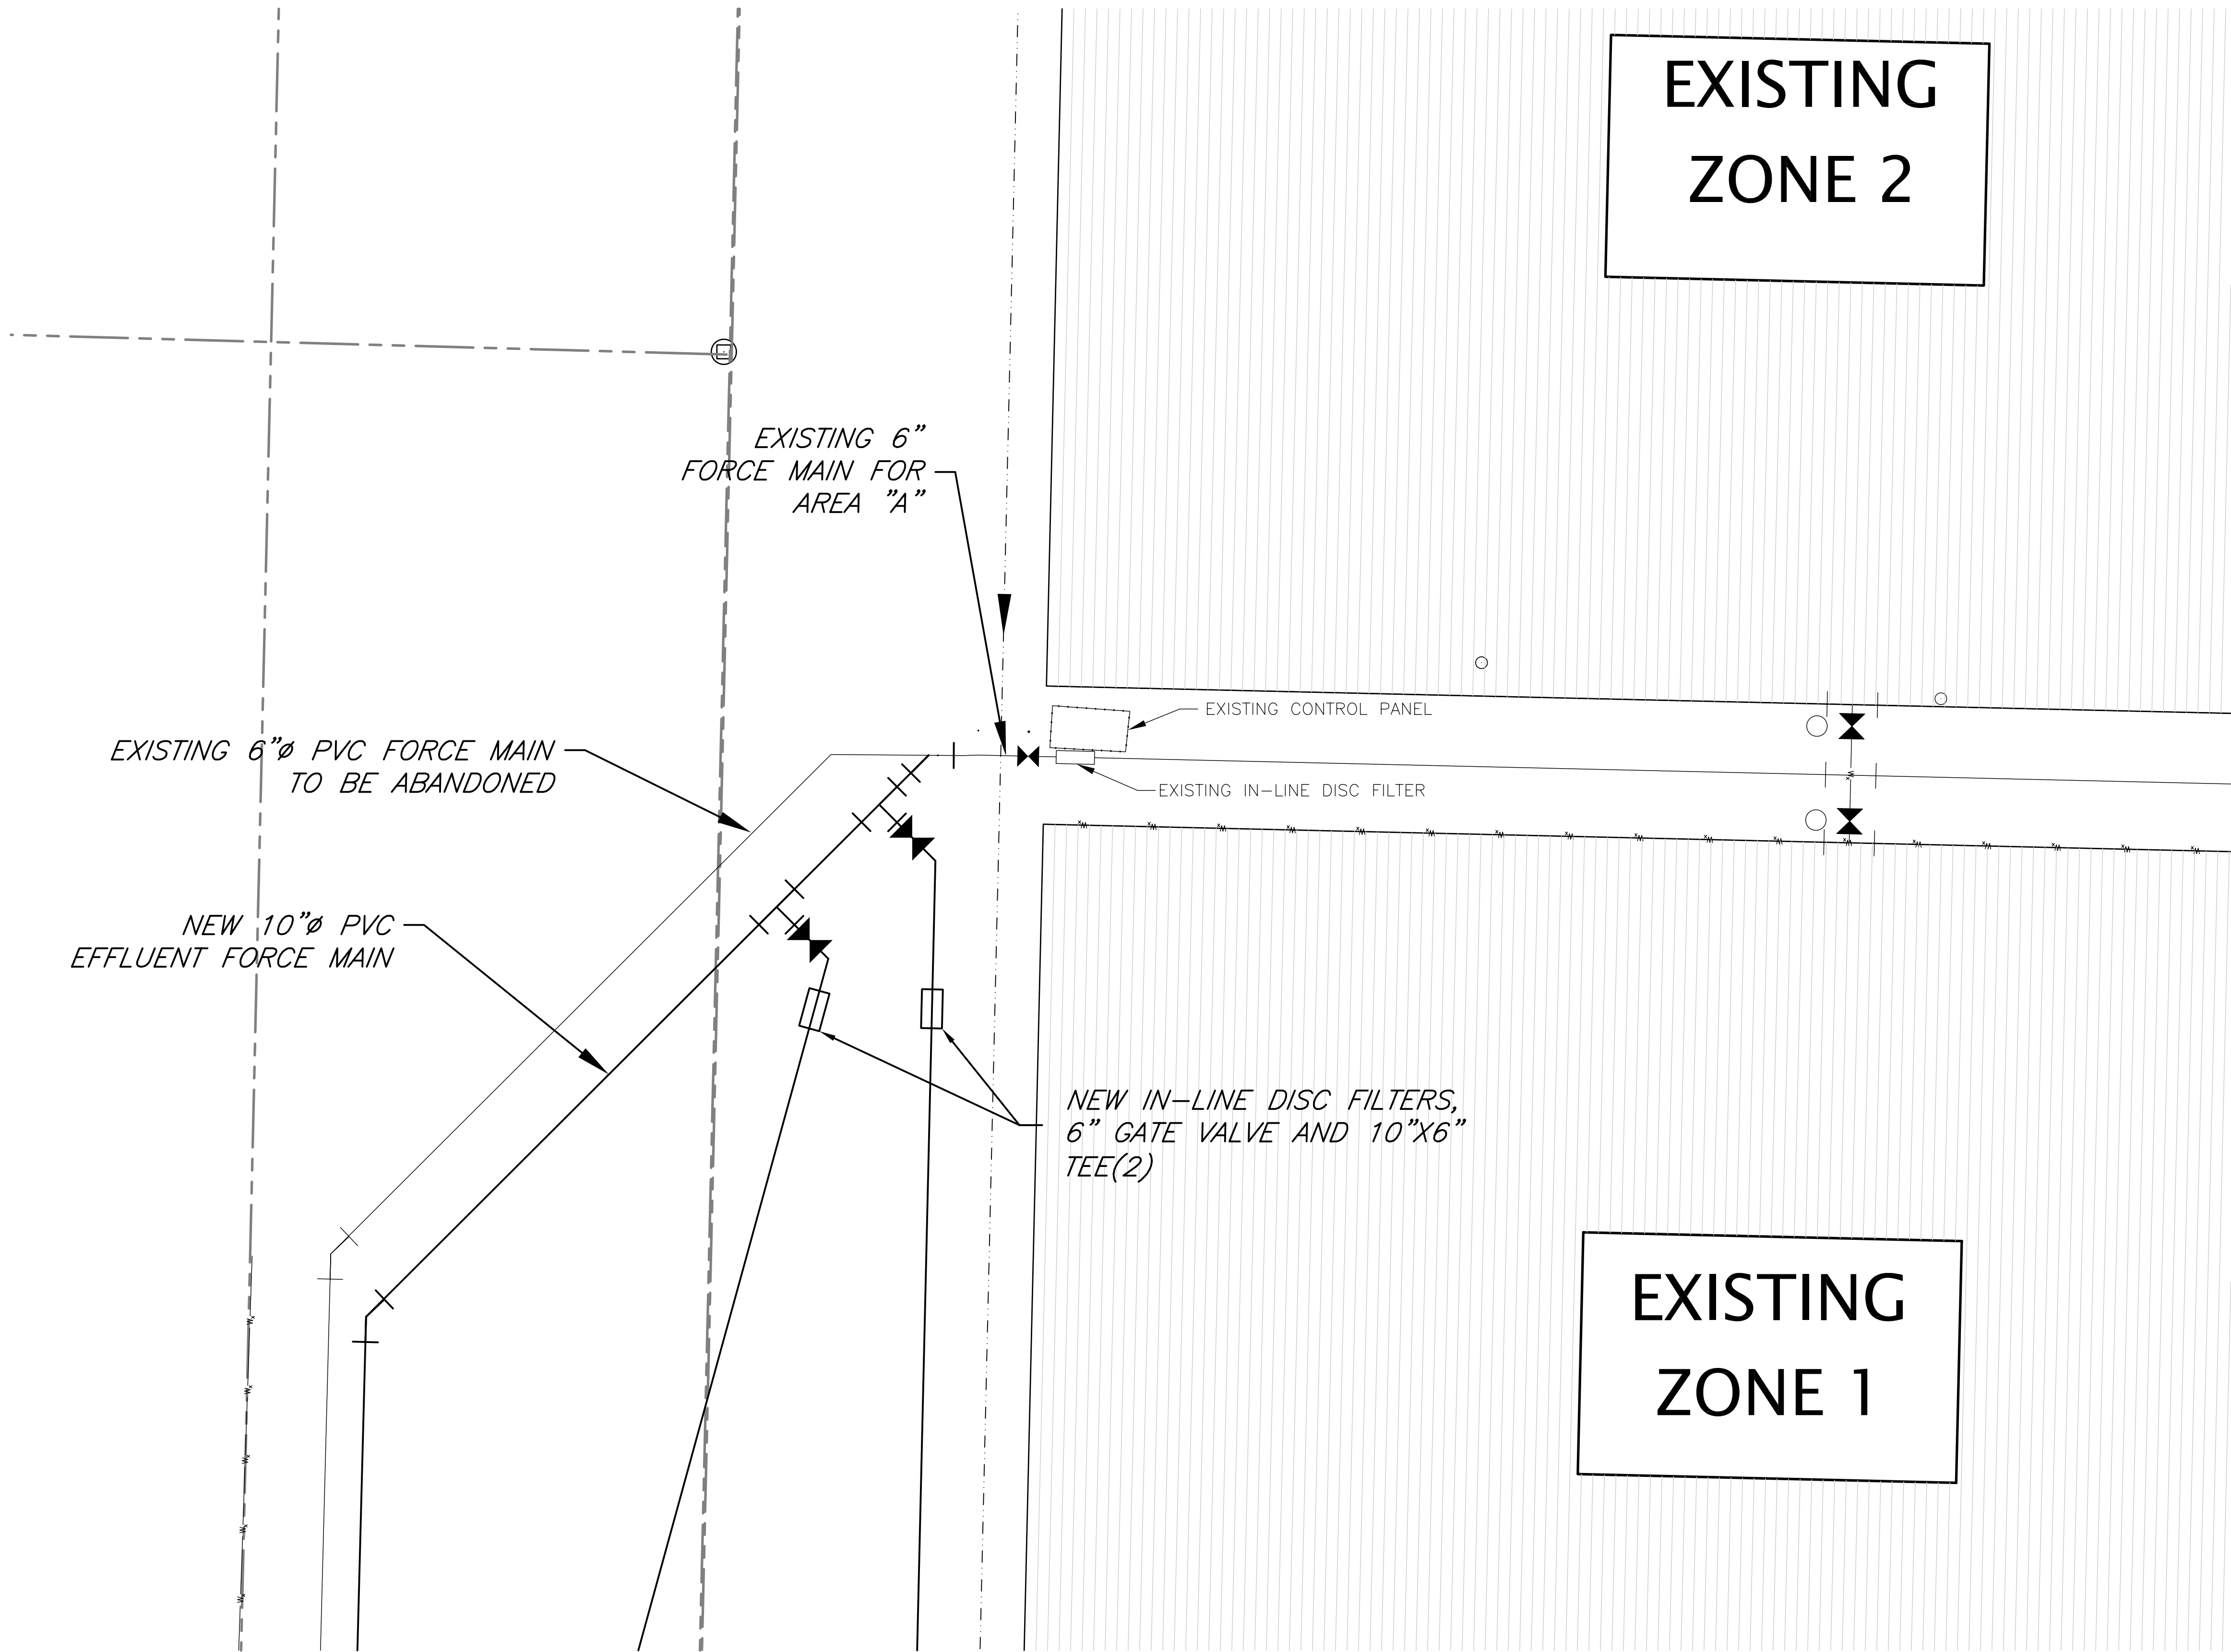

ENGINEER OF RECORD
BETH BRANT
REGISTRATION NUMBER
FL LIC. NO. 57972

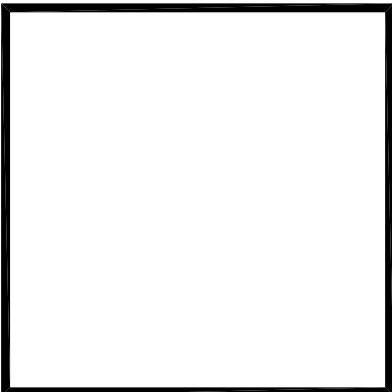

Cert. of Auth. No.
CA-1818

These drawings are copy-
righted and the property
of Polyengineering. Any
use, partial or full repro-
duction is prohibited
except by written Agree-
ment with Polyengineering

BOB SIKES PARK
WWTF EFFLUENT DISPOSAL
EXPANSION
PHASE II
OKALOOSA COUNTY WATER AND SEWER SYSTEM
OKALOOSA COUNTY, FLORIDA

POLYENGINEERING, INC.
ARCHITECTURE, ENGINEERING, SOLUTIONS

Post Office Box 841
102 SUNSET LANE
SHALIMAR, FLORIDA 32579
850-609-1100
WWW.POLYENGINEERING.COM

Revisions			
Key	Drawn By	Apprvd. By	Date
1			
2			
3			
4			

Field Book No.

Drawn By
DH

Apprvd. By
BB

Date
FEBRUARY 2009

Project No.
41-264

Sheet title
NEW IN-LINE
DISC FILTERS

Sheet No

C-12
12 OF 14

[illegible]

10' VEHICLE ACCESS AREA

10'

230 L.F. DRIP ABSORPTION FIELD "1"

5'

10' VEHICLE ACCESS AREA

5'

230 L.F. DRIP ABSORPTION FIELD "2"

10'

10' VEHICLE ACCESS AREA

SEE O&M MANUALS FOR DETAILED CONFIGURATION

Figure 1: Typical layout of a 20' wide absorption area. The diagram shows a cross-section of a landscape with various zones and dimensions. From left to right: a 10'-0" VEHICLE ACCESS AREA; a 2'-0" zone; a 3'-0" zone; a 10'-0" central zone; another 3'-0" zone; and a final 2'-0" zone leading to the EDGE OF ABSORPTION AREA. The ground surface is marked with 'x's representing drip irrigation tubes. A hatched area below the surface is labeled 'SLOPE ALL SWALES @ 0.05% MIN.' with a 6" depth indicated. A 10" TYP. depth is also shown. A north arrow is in the bottom right corner.

Diagram illustrating the plan view of a 10' wide absorption area. The area is divided into sections with dimensions: 2'-0" (left), 3'-0" (middle), 3'-0" (middle), 2'-0" (right), and 10'-0" (right). The total width is 20'-0". The area is labeled "EDGE OF ABSORPTION AREA" and "VEHICLE ACCESS AREA". A "DRIP TUBE" is shown on the left, connected to a "6" Ø HEADER" with a "10" TYP." dimension. The slope is indicated as "SLOPE ALL SWALES @ 0.05% MIN." and a "6" dimension is shown at the bottom right.

Diagram illustrating the cross-section of a drainage system. The total width is 20'-0". The left side is a 10'-0" VEHICLE ACCESS AREA. The right side is a 10'-0" EDGE OF ABSORPTION AREA. The central section is divided into segments: 2'-0", 3'-0", 10'-0", 3'-0", and 2'-0". The bottom of the central section is labeled SLOPE ALL SWALES @0.05% MIN. The bottom of the right side is labeled 10" TYP. and 6" Ø HEADER. A DRIP TUBE is shown on the right side.

[illegible]

Cert. of Auth. No.
CA-1818

These drawings are copyrighted and the property of Polyengineering. Any use, partial or full reproduction is prohibited except by written Agreement with Polyengineering

**BOB SIKES PARK
WWTF EFFLUENT DISPOSAL
EXPANSION
PHASE II**

POLYENGINEERING, INC.
ARCHITECTURE, ENGINEERING, SOLUTIONS

POST OFFICE BOX 841
102 SUNSET LANE
SHALIMAR, FLORIDA 32579
850-609-1100
WWW.POLYENGINEERING.COM

Revisions			
Key	Drawn By	Apprvd. By	Date
1			
2			
3			
4			

Field Book No.

Drawn By DH	Apprvd. By BB
----------------	------------------

Date
FEBRUARY 2009

Project No.
41-264

Sheet title


ABSORPTION BED
DETAILS

Sheet No


C-13
13 OF 14

ENGINEER OF RECORD
BETH BRANT
REGISTRATION NUMBER
FL LIC. NO. 57972


Polyengineering, Inc. - C:\CLEANSTUFF-29-999\41264 CrestView Permit\WP\PHASE I\41246 ABSORPTION BED DETAILS.dwg [Layout] (2) Last Printed: March 13, 2009 - 10:08am By: Alderman

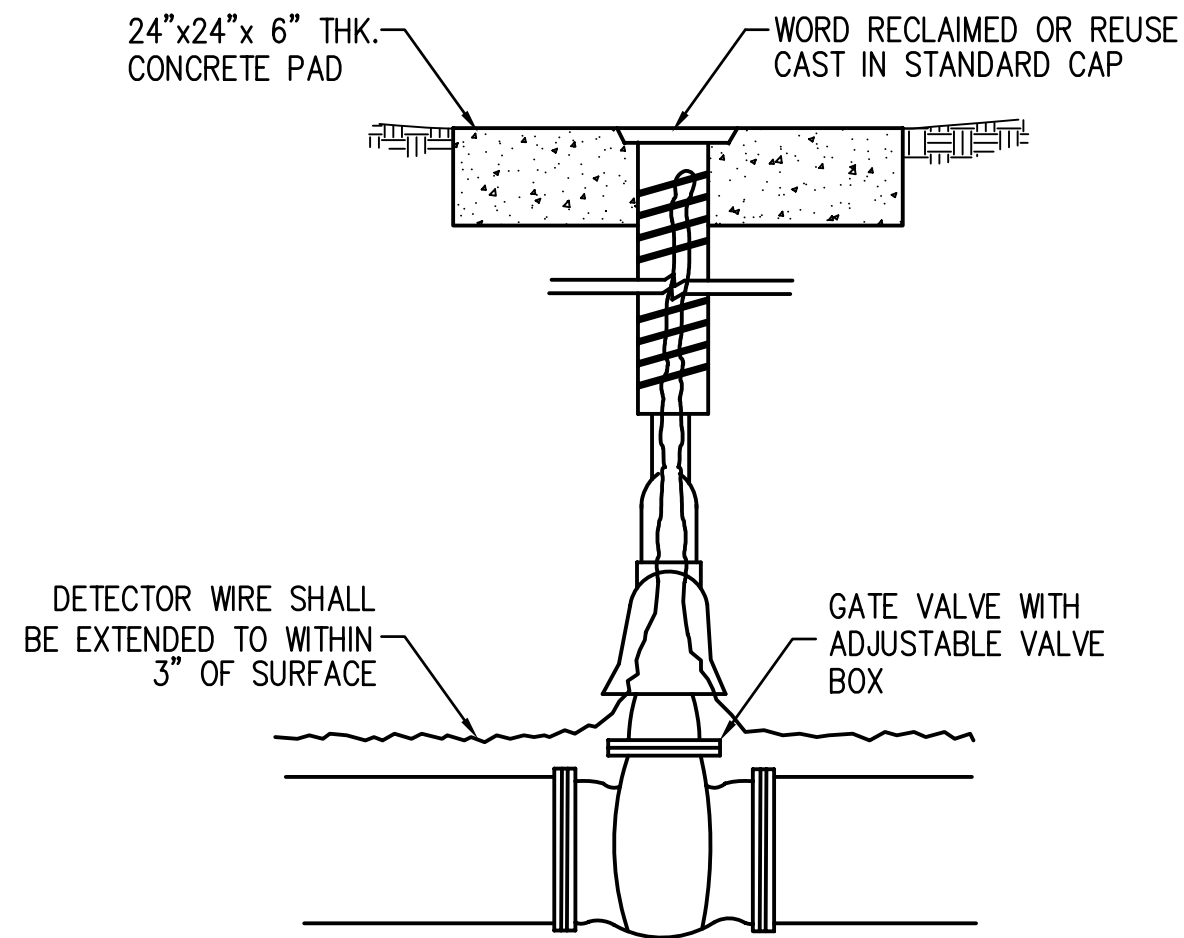

GATE VALVE & BOX
NO SCALE

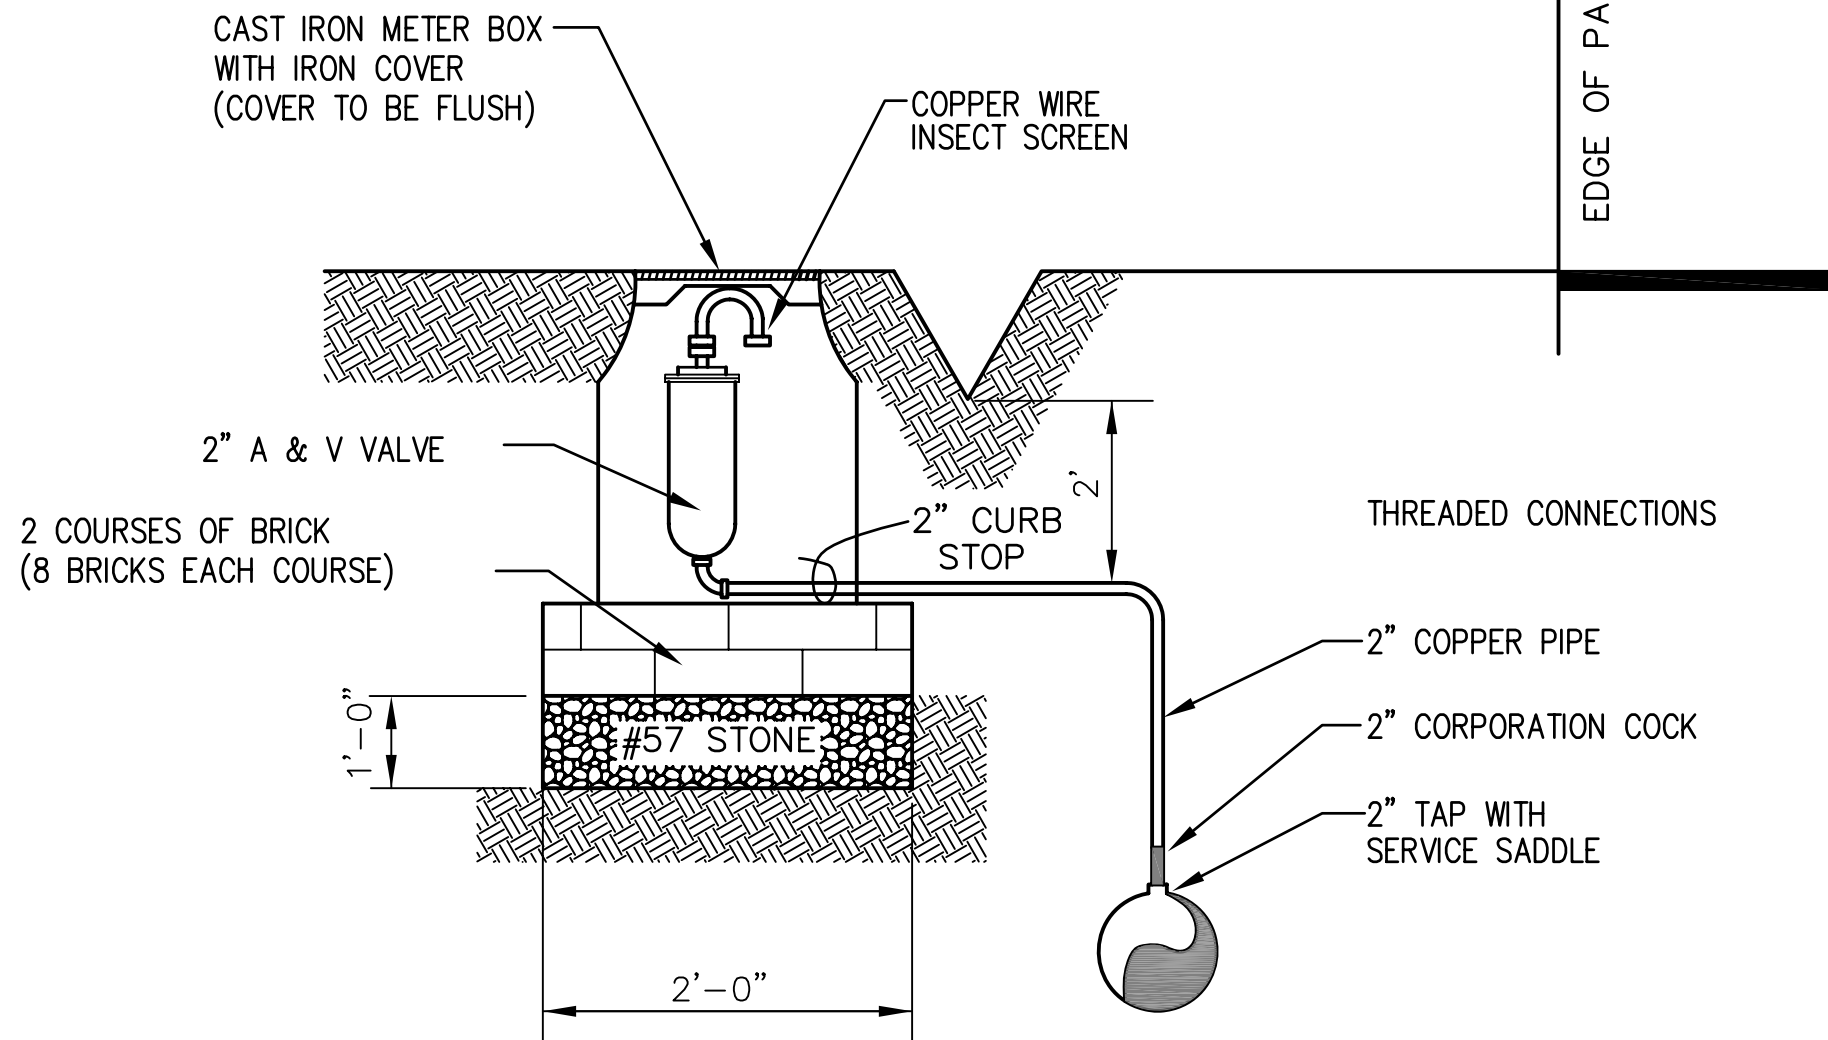


**TYPICAL AIR & VACUUM
RELEASE VALVE ASSEMBLY**
NO SCALE

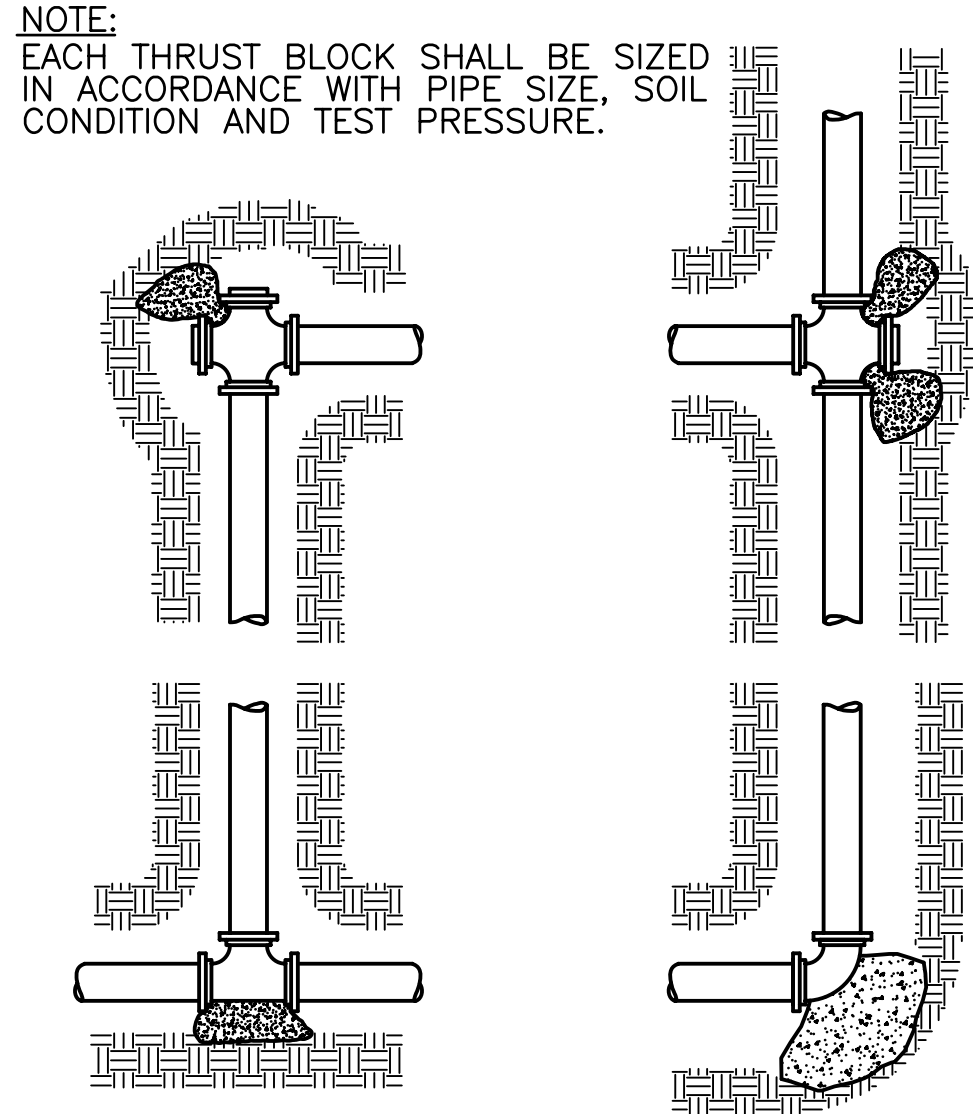


THRUST BLOCK DETAIL
NO SCALE

PIPE DIAMETER	MINIMUM THRUST BLOCK BEARING AREA
3"	2 SQ.FT.
6"	4.5 SQ.FT.

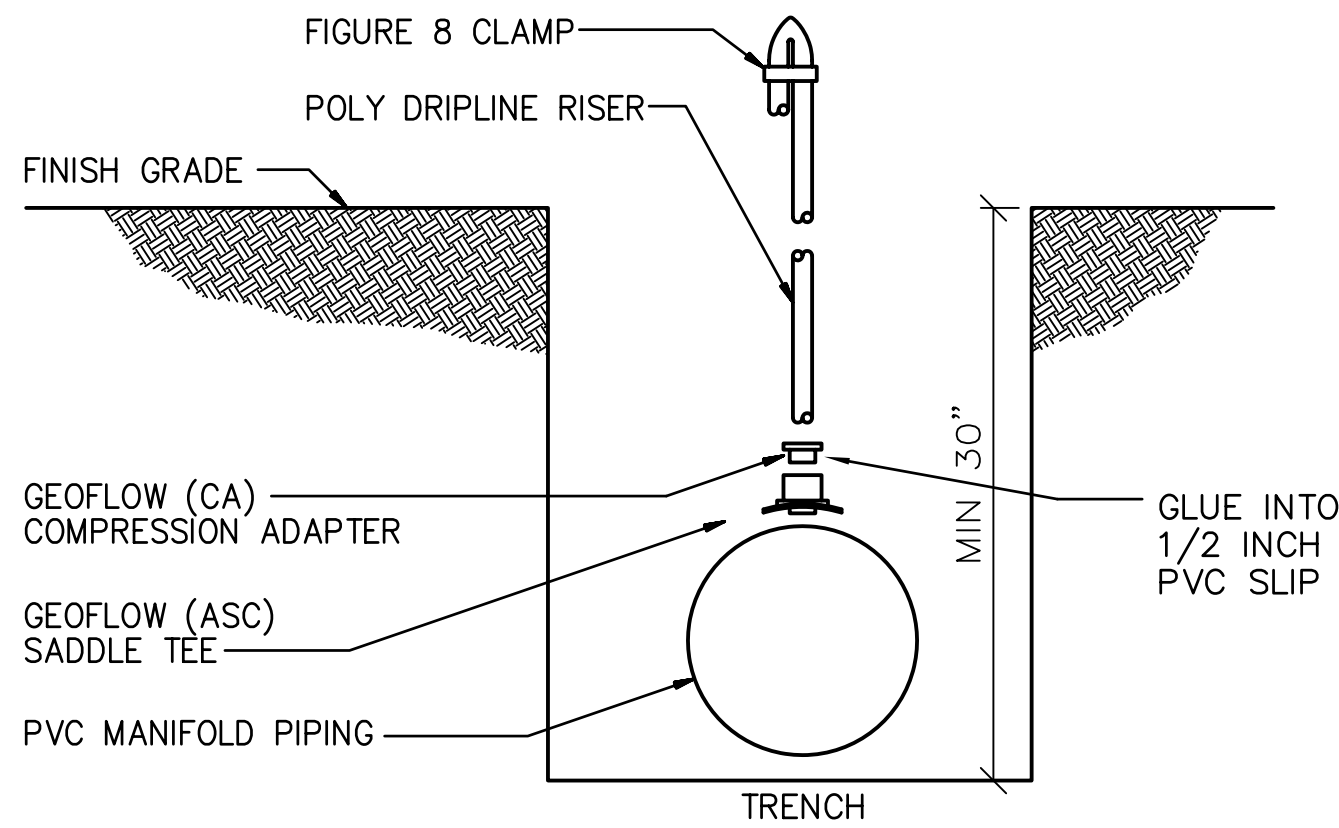

SADDLE TEE MANIFOLD (STEP #2)
NO SCALE

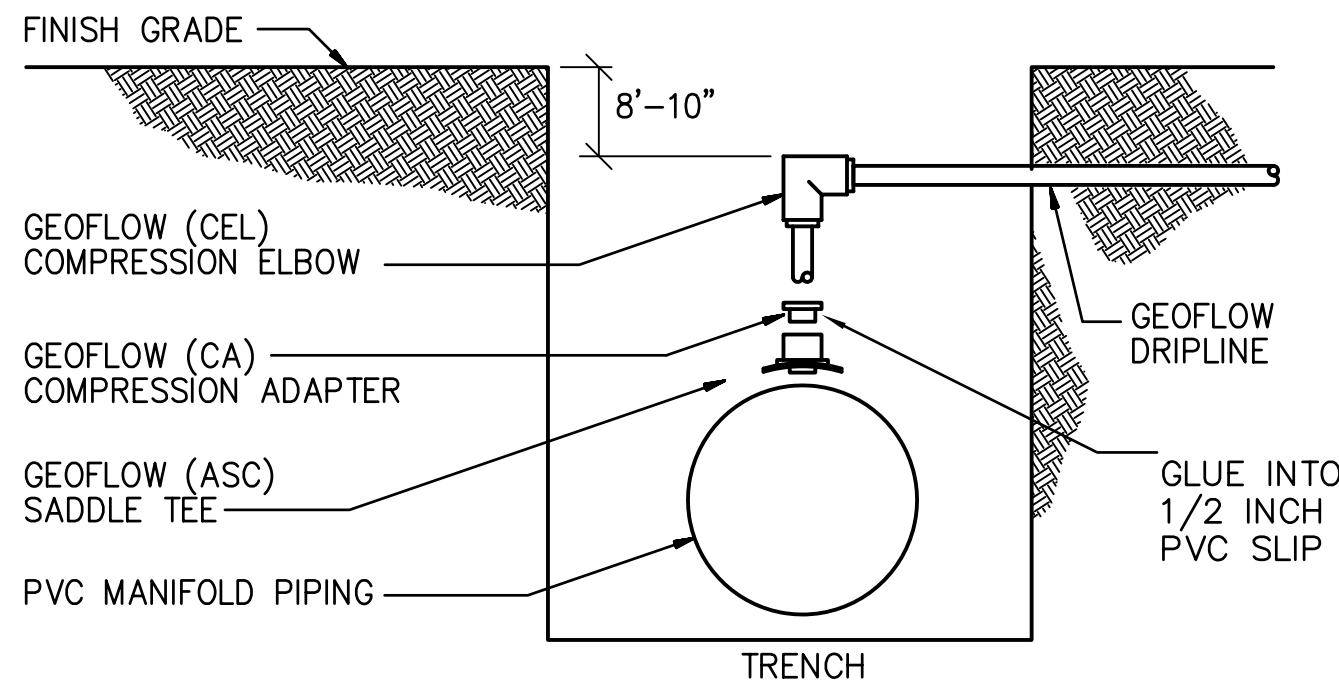


SADDLE TEE MANIFOLD (STEP #3)
NO SCALE

- NOTES:**
- GEOFLOW IRRIGATION TUBING TO BE INSTALLED PRIOR TO 6" PVC MANIFOLD HEADER PIPES. (NOT SHOWN)
 - INSTALL 6" HEADER PIPES AND GEOFLOW SADDLE TEE, COMPRESSION ADAPTER AND RISER INTO PRE-DRILLED HOLES (IN 6" PVC) AS SHOWN IN STEP #2.
 - ATTACH GEOFLOW TUBING TO RISER USING GEOFLOW COMPRESSION ELBOW AS SHOWN IN STEP #3.

ENGINEER OF RECORD
BETH BRANT
REGISTRATION NUMBER
FL LIC. NO. 57972

BOB SIKES PARK
WWTF EFFLUENT DISPOSAL
EXPANSION
PHASE II
OKALOOSA COUNTY WATER AND SEWER SYSTEM
OKALOOSA COUNTY, FLORIDA

POLYENGINEERING, INC.
ARCHITECTURE, ENGINEERING, SOLUTIONS
Post Office Box 841
102 SUNSET LANE
SHALIMAR, FLORIDA 32579
850-609-1100
WWW.POLYENGINEERING.COM

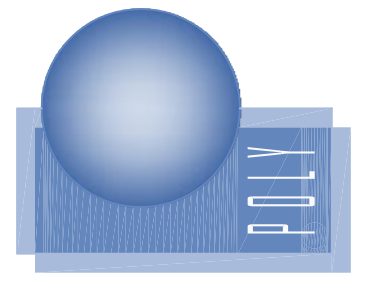

Key	Revisions	Drawn By	Apprvd. By	Date
1				
2				
3				
4				

Field Book No.

Drawn By
DH

Apprvd. By
BB

Date
FEBRUARY 2009


Project No.
41-264

Sheet title
ABSORPTION BED
DETAILS

Sheet No

C-14
14 OF 14

Polyengineering, Inc. - G:\CLEANSTUFF-29-999\41264 CrestView WWTF Operating Permit\WP\PHASE 1\ELECTRICAL\E-1.dwg [Layout1] Last Printed: March 13, 2009 - 10:09am By: Alderman

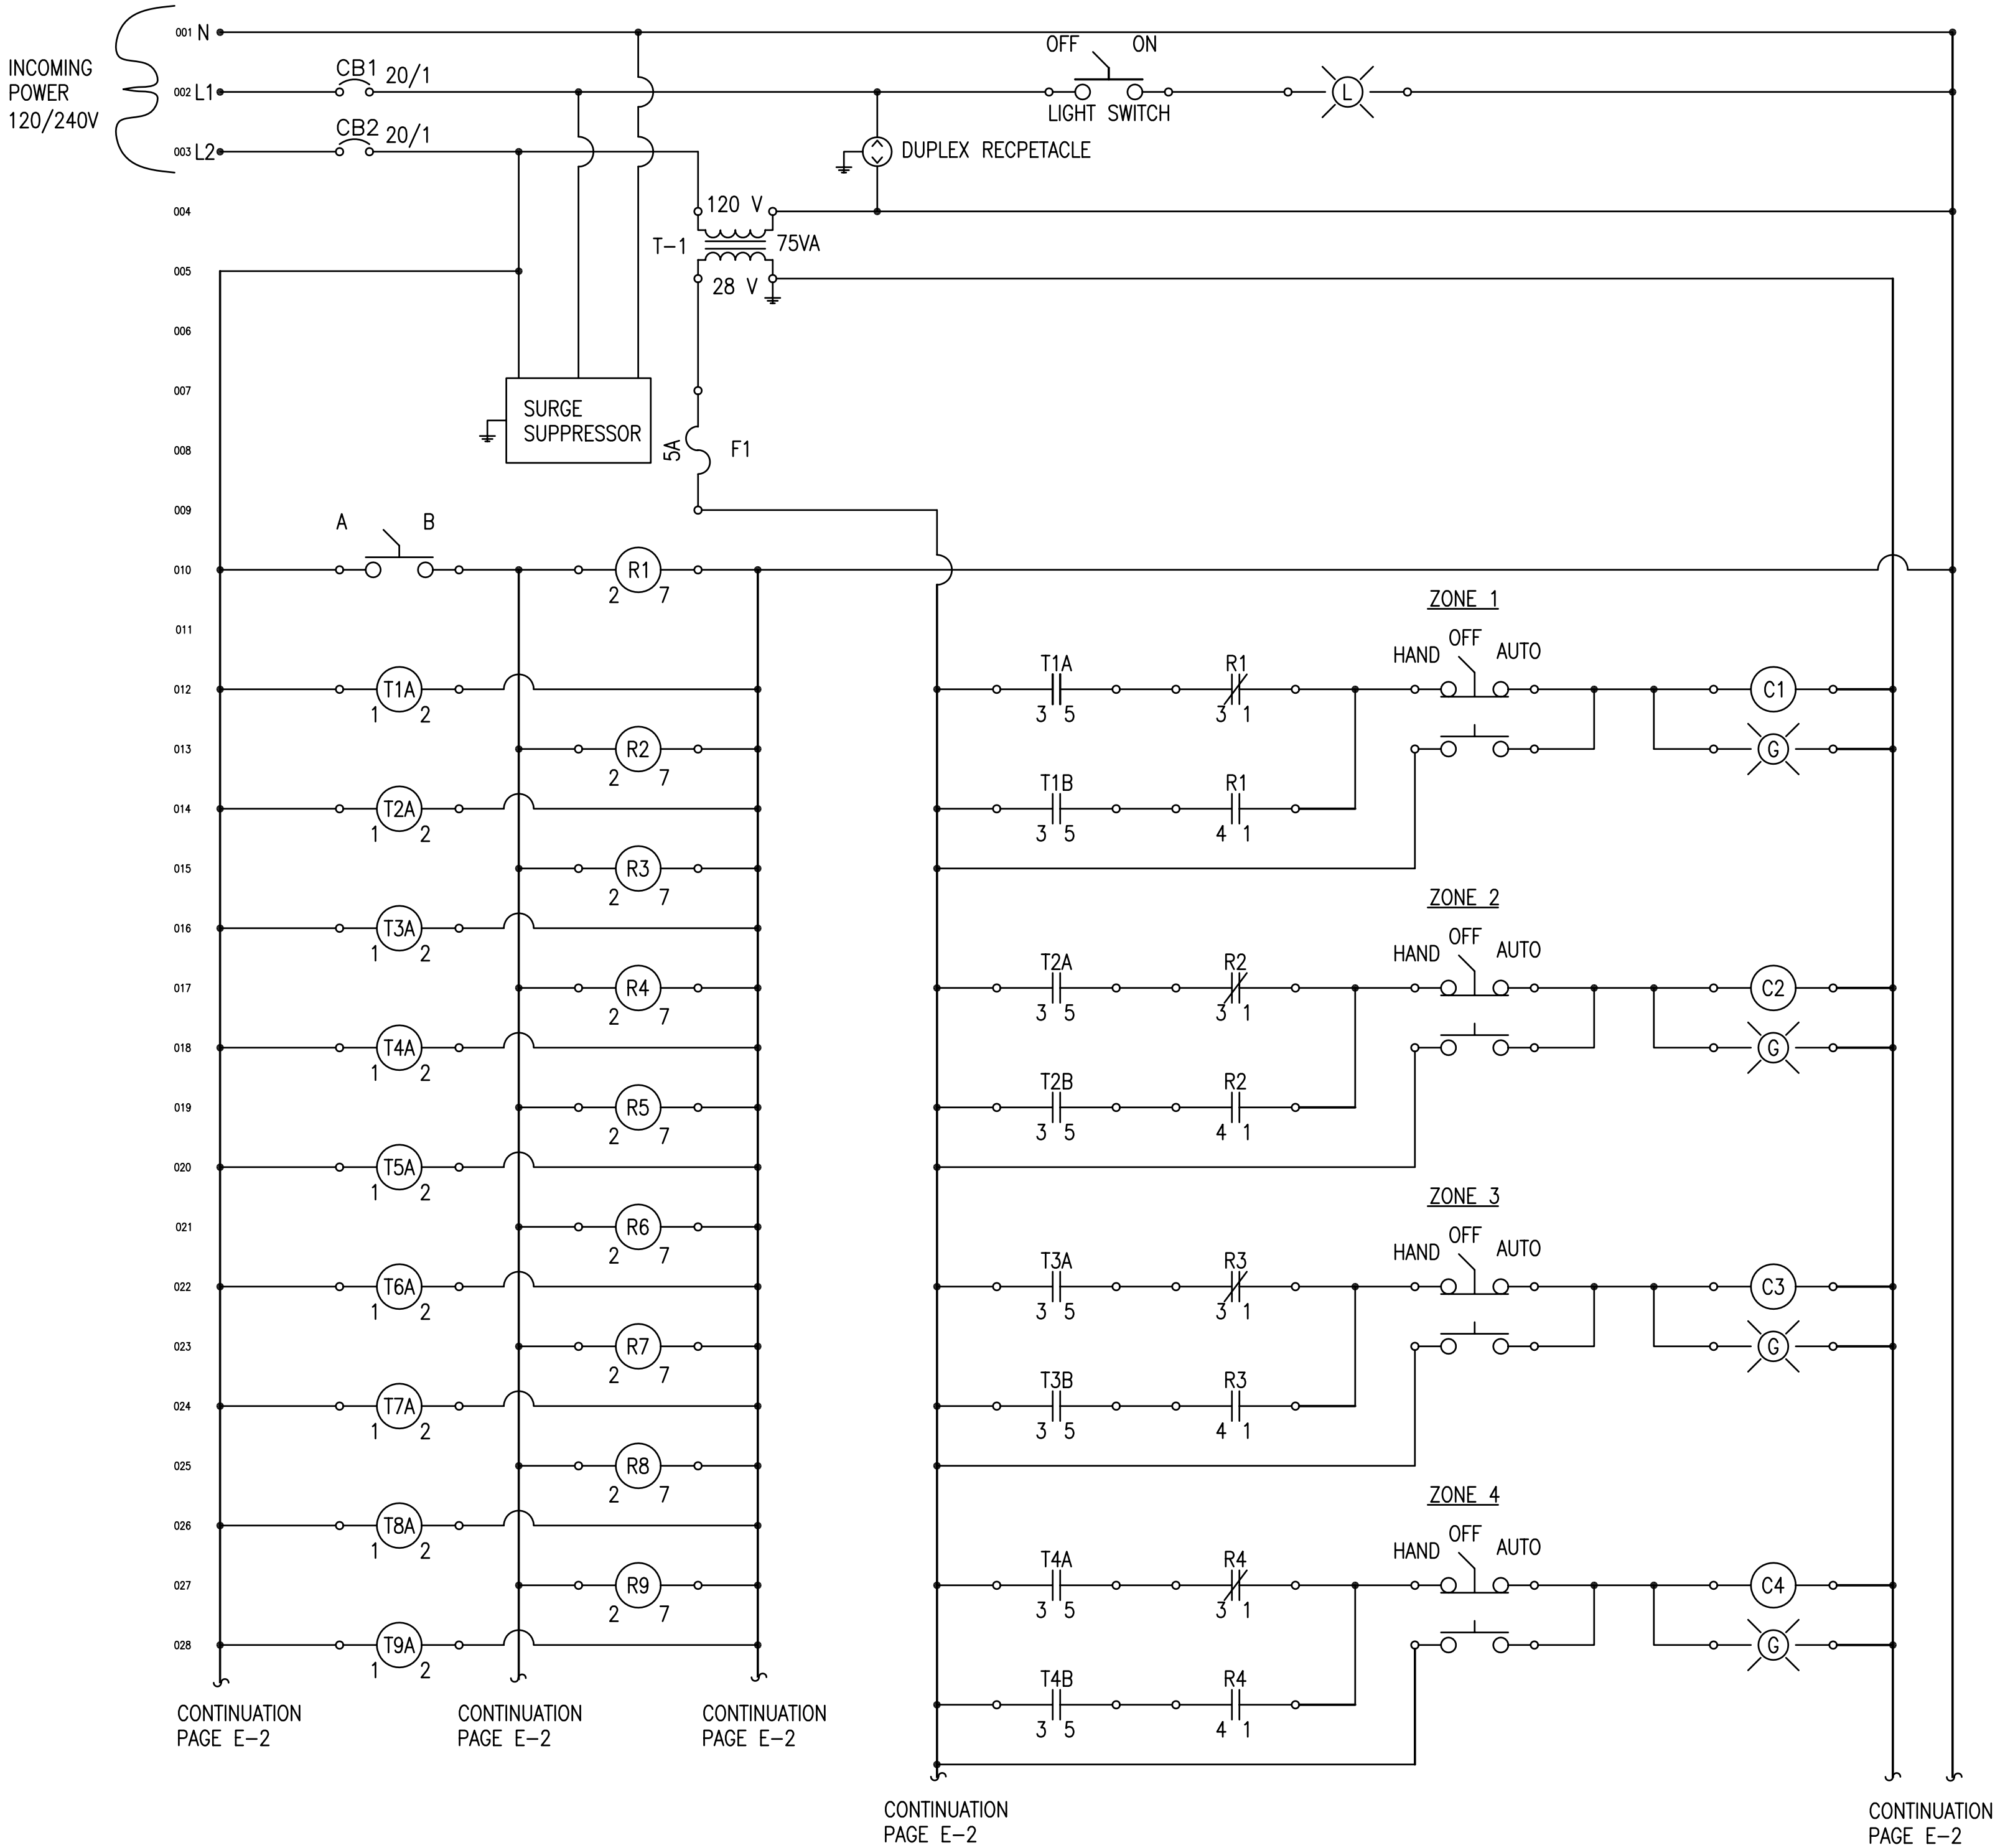

CONTROL DIAGRAM
SCALE: NONE

ELECTRICAL SYMBOL LEGEND:

- Controls:
- GENERAL PURPOSE RELAY, RELAY R1 INDICATED. CONTACT ARRANGEMENT AS REQUIRED.
 - TIME DELAY RELAY, RELAY T1 INDICATED. CONTACT ARRANGEMENT AS REQUIRED.
 - CONTACTOR COIL, CONTACTOR C1 INDICATED. CONTACT ARRANGEMENT AS REQUIRED.
 - NORMALLY CLOSED CONTACTS - COIL 'R1', CONTACT '1' INDICATED.
 - NORMALLY OPEN CONTACTS - COIL 'R1', CONTACT '1' INDICATED.
 - PILOT LIGHT - PUSH-TO-TEST TYPE, OIL TIGHT. LETTER INDICATES LENS COLOR: R=RED, G=GREEN, A=AMBER.
 - HAND-OFF-AUTO ROTARY SELECTOR SWITCH, OIL-TIGHT.
 - TWO-POSITION ROTARY SELECTOR SWITCH, OIL-TIGHT.
 - FUSE. 5A OVERCURRENT RATING INDICATED.
 - CONTROL POWER TRANSFORMER. 75 VA POWER RATING INDICATED. 120V PRIMARY VOLTAGE, 28V SECONDARY VOLTAGE INDICATED.
 - FIELD WIRING POINT OR TERMINAL BLOCK
 - CIRCUIT BREAKER, "CB1" INDICATED "20/1" DENOTES 20 AMP, SINGLE POLE.
 - SWITCH, SINGLE POLE TOGGLE
 - PRESSURE SWITCH, NORMALLY OPEN. SWITCH PS1 INDICATED.

ENGINEER OF RECORD
JOSEPH W. BOWMAN
REGISTRATION NUMBER
FL LIC. NO. 59881

Cert. of Auth. No.
CA-1818

These drawings are copy-
righted and the property
of Polyengineering. Any
use, partial or full repro-
duction is prohibited
except by written Agree-
ment with Polyengineering

BOB SIKES PARK
WWTF EFFLUENT DISPOSAL
EXPANSION
PHASE II
OKALOOSA COUNTY WATER AND SEWER SYSTEM
OKALOOSA COUNTY, FLORIDA

POLYENGINEERING, INC.
ARCHITECTURE, ENGINEERING, SOLUTIONS

Post Office Box 841
102 SUNSET LANE
SHALIMAR, FLORIDA 32579
850-609-1100
WWW.POLYENGINEERING.COM

Revisions			
Key	Drawn By	Appr'd. By	Date
1	CEB	JWB	
2			
3			
4			

Field Book No.

Drawn By
CEB

Appr'd. By
JWB



Date
FEBRUARY 2009

Project No.
41-264

Sheet title
CONTROL DIAGRAM

Sheet No.

E-1
1 OF 5

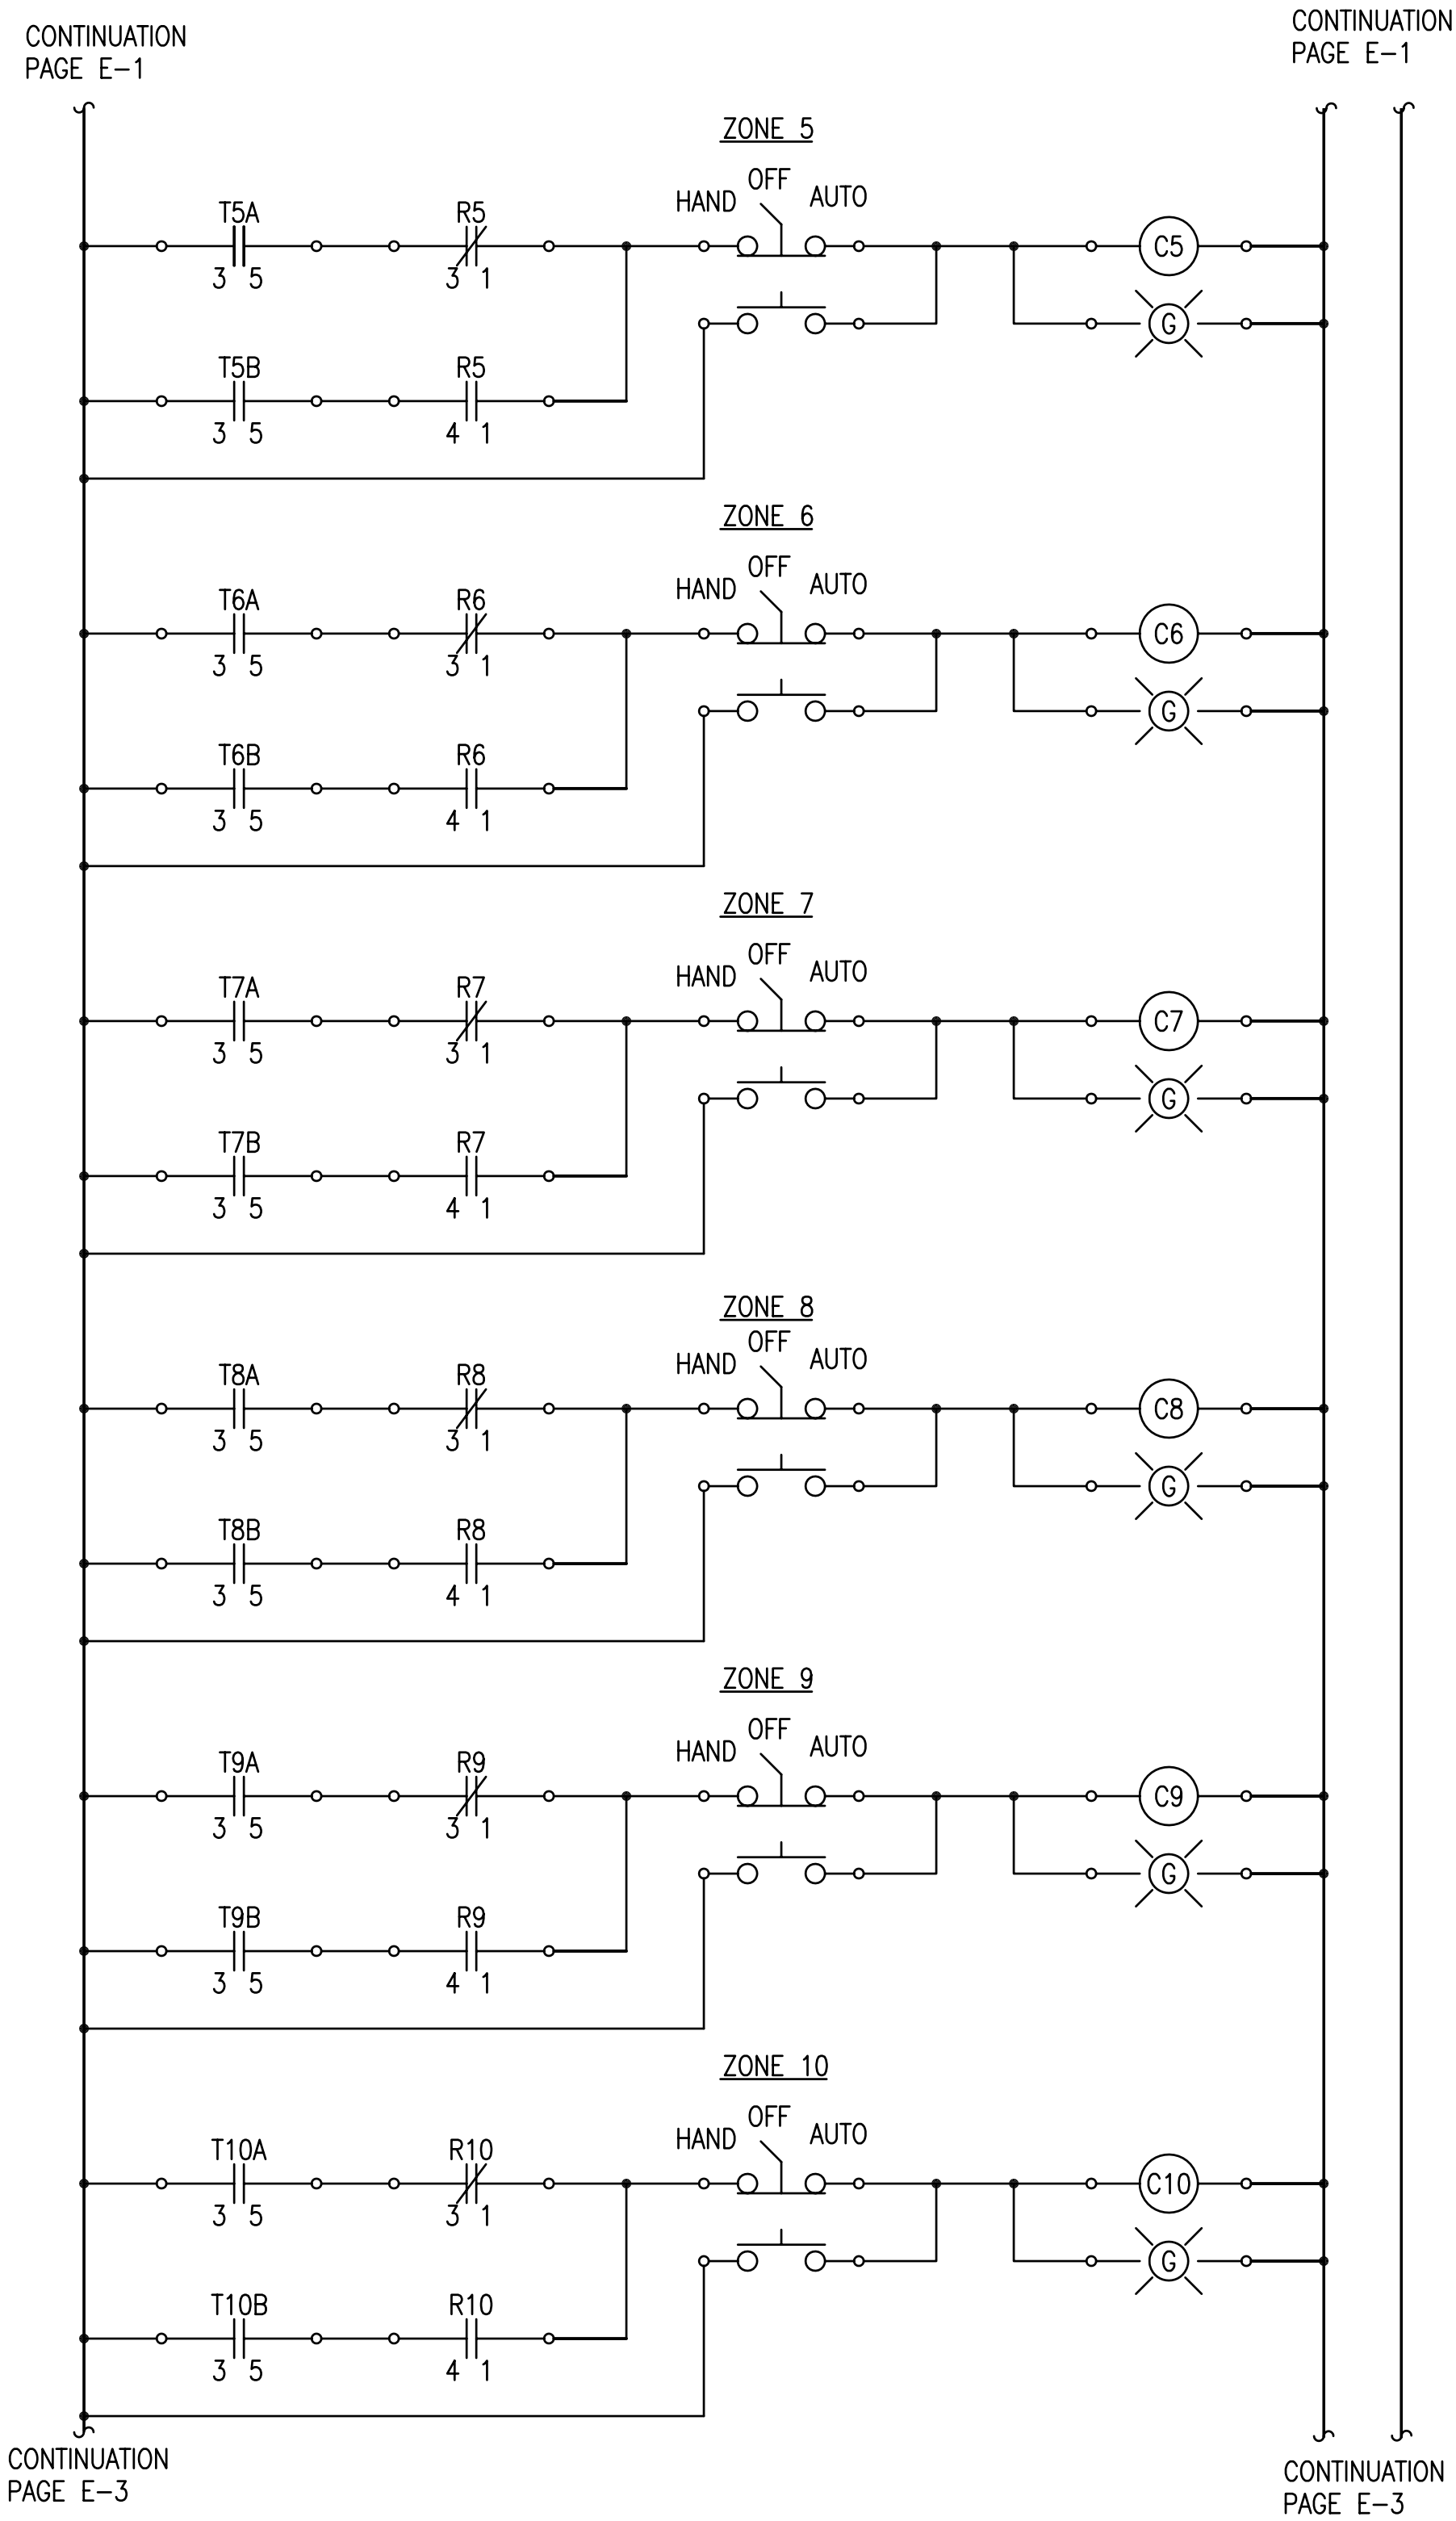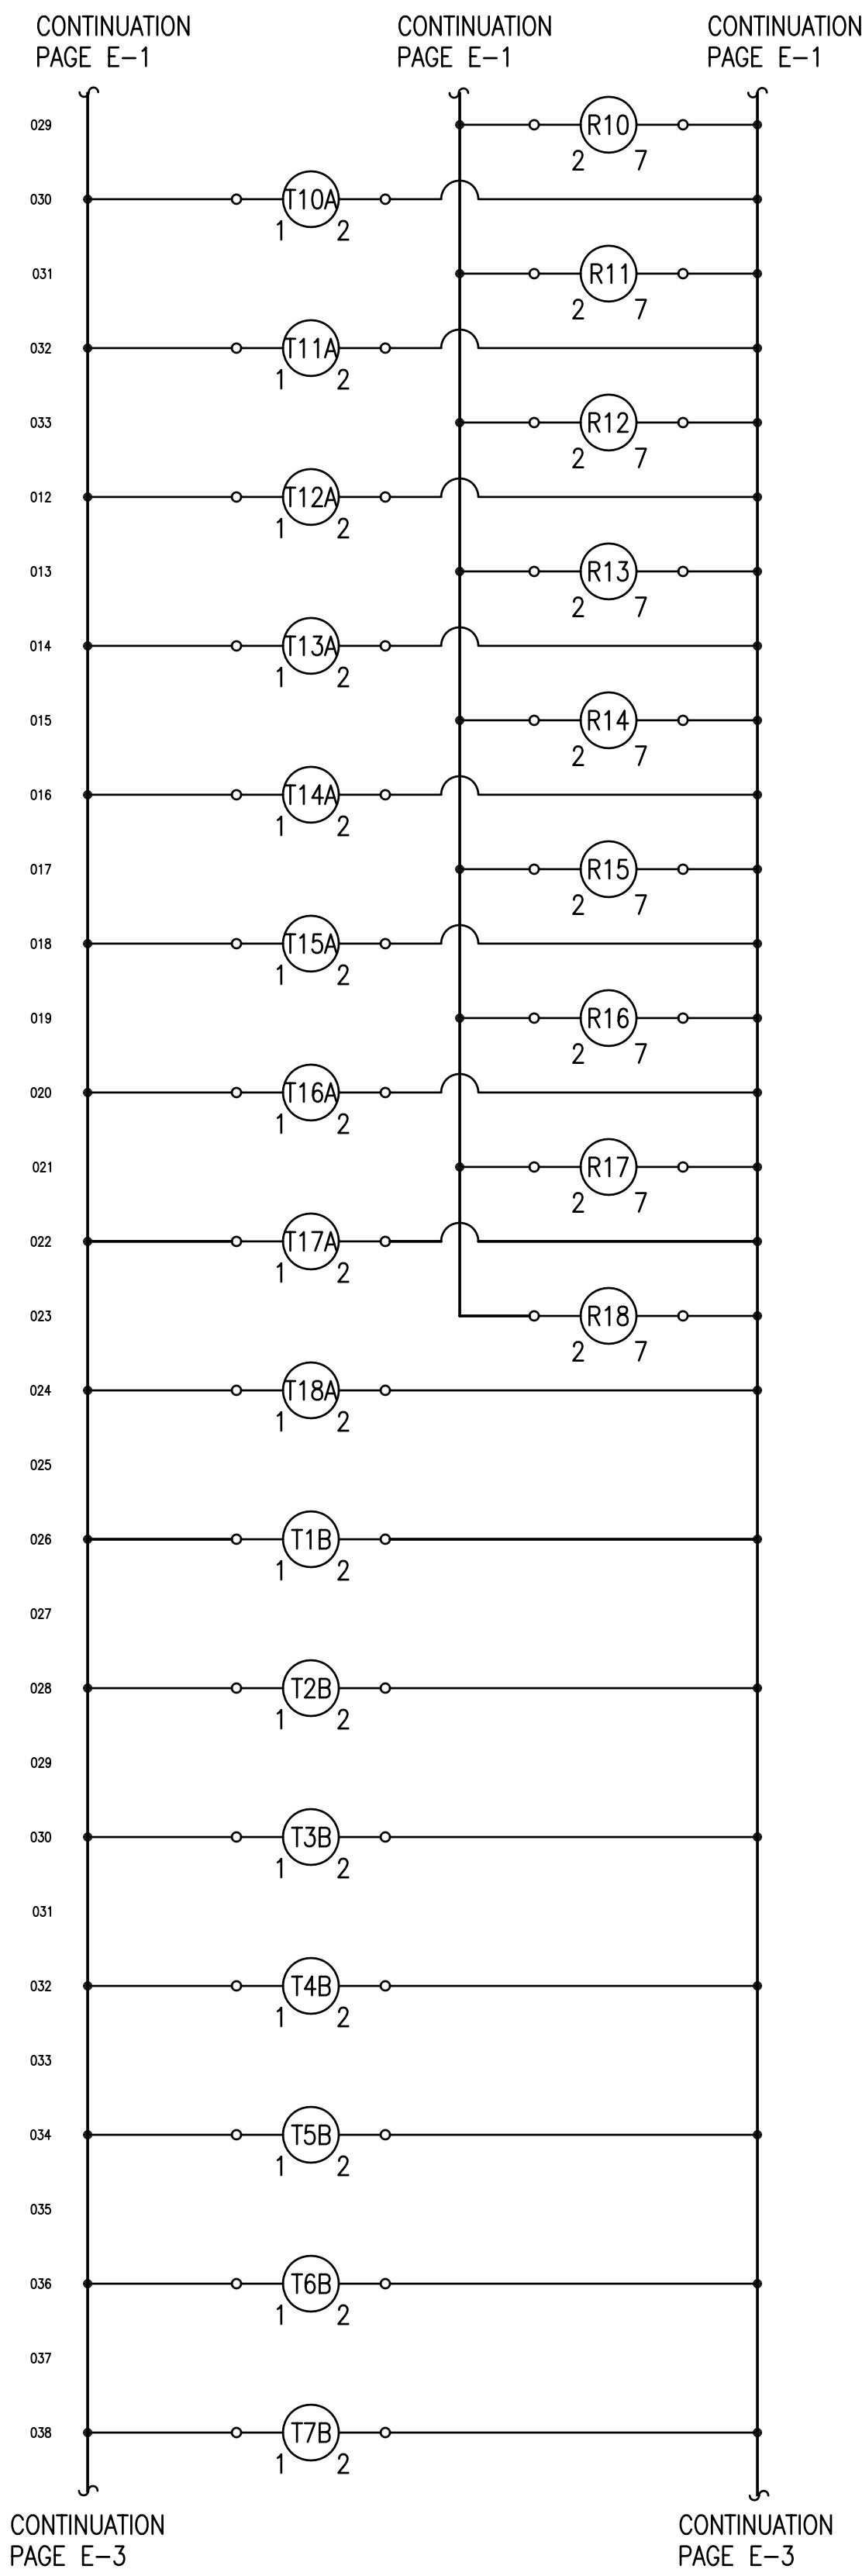

CONTROL DIAGRAM

SCALE: NONE

ENGINEER OF RECORD
JOSEPH W. BOWMAN
REGISTRATION NUMBER
FL LIC. NO. 59881

Cert. of Auth. No.
CA-1818

These drawings are copyrighted and the property of Polyengineering. Any use, partial or full reproduction is prohibited except by written Agreement with Polyengineering

**BOB SIKES PARK
WWTF EFFLUENT DISPOSAL
EXPANSION
PHASE II**

**OKALOOSA COUNTY WATER AND SEWER SYSTEM
OKALOOSA COUNTY, FLORIDA**

POLYENGINEERING, INC.

POLYENGINEERING, INC.

Post Office Box 841

JOE GENSE, OWNER
SHALIMAR, FLORIDA 32579
850-609-1100

WWW.POLYENGINEERING.COM

Revisions			
Key	Drawn By	Apprvd. By	Date
①			
②			
③			
④			

Field Book No.

Drawn By CEB	Apprvd. By JWB
-----------------	-------------------

Date
FEBRUARY 2009



Project No.
41-264

Sheet title
CONTROL DIAGRAM

F-2

E-2
2 OF 5

Polyengineering, Inc. - C:\CLEANSTUFF-29-999\41264 CrestView WWTF Operating Permit\WP\PHASE 1\ELECTRICAL\E-3.dwg [Layout1] Last Printed: March 13, 2009 - 10:10am By: Alderman

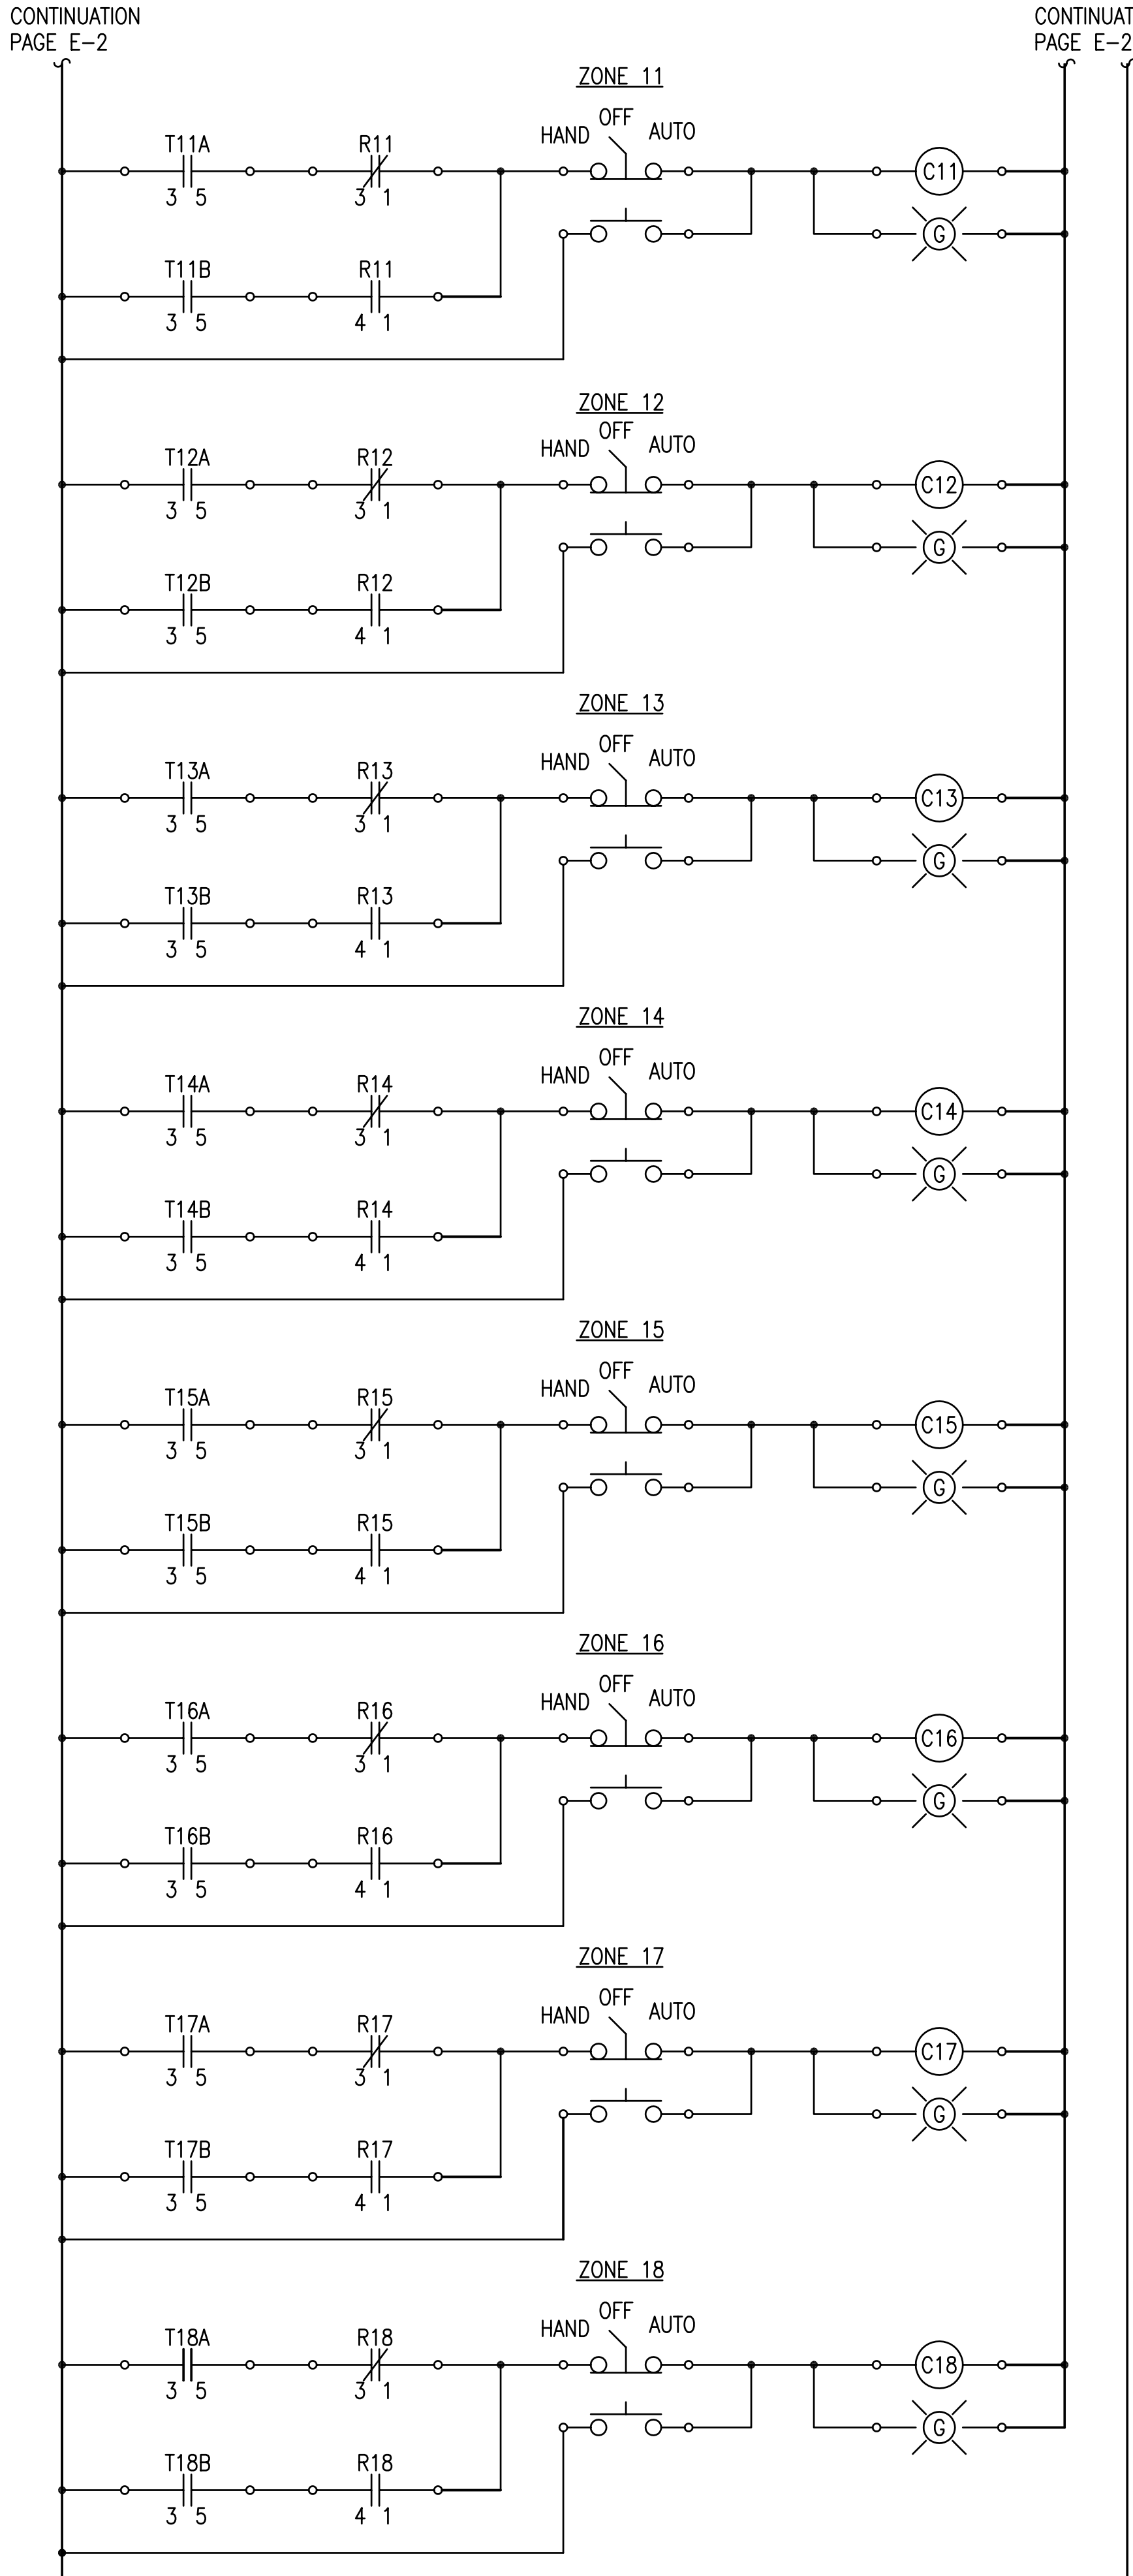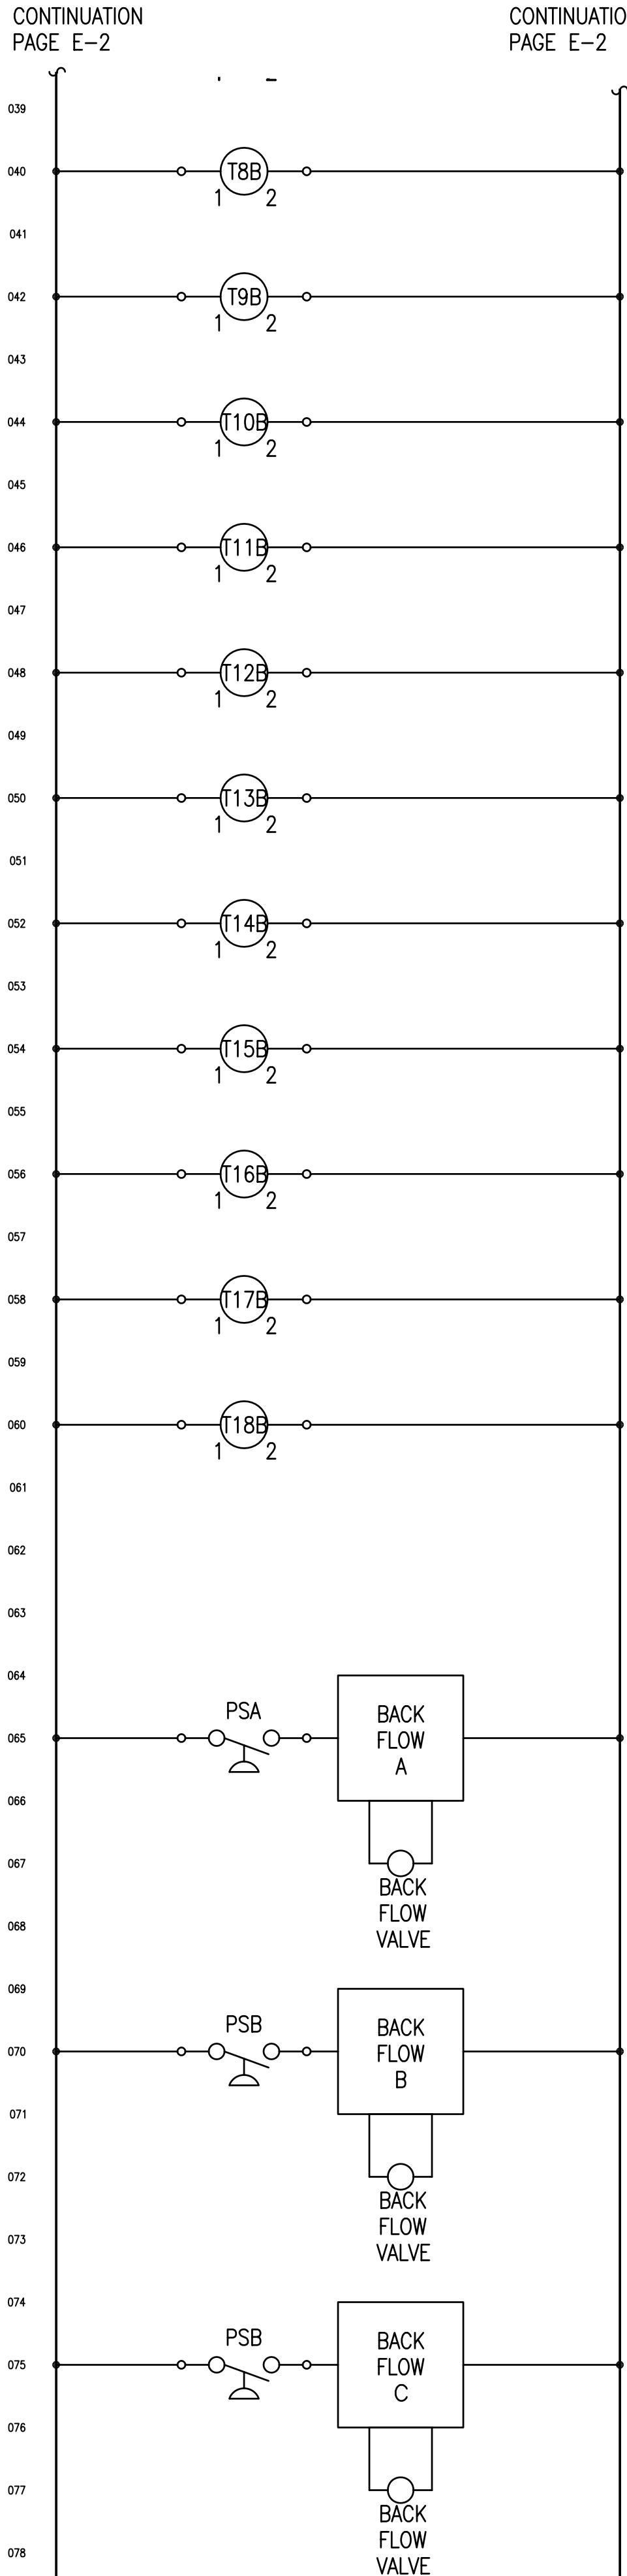

CONTROL DIAGRAM
SCALE: NONE

ENGINEER OF RECORD
JOSEPH W. BOWMAN
REGISTRATION NUMBER
FL LIC. NO. 59881

Cert. of Auth. No.
CA-1818

These drawings are copy-
righted and the property
of Polyengineering. Any
use, partial or full repro-
duction is prohibited
except by written Agree-
ment with Polyengineering

BOB SIKES PARK
WWTF EFFLUENT DISPOSAL
EXPANSION
PHASE II
OKALOOSA COUNTY WATER AND SEWER SYSTEM
OKALOOSA COUNTY, FLORIDA

POLYENGINEERING, INC.
ARCHITECTURE, ENGINEERING, SOLUTIONS
Post Office Box 841
102 SUNSET LANE
SHALIMAR, FLORIDA 32579
850-609-1100
WWW.POLYENGINEERING.COM

Revisions			
Key	Drawn By	Apprvd. By	Date
1	CEB	JWB	
2	CEB	JWB	
3	CEB	JWB	
4	CEB	JWB	

Field Book No.
.

Drawn By
CEB

Apprvd. By
JWB

Date
FEBRUARY 2009

Project No.
41-264


Sheet title
CONTROL DIAGRAM

Sheet No







E-3
3 OF 5

Polyengineering, Inc. - G:\CLEANSTUFF-29-999\41264 CrestView WWTF Operating Permit\WP\PHASE 1\ELECTRICAL\E-4.dwg [Layout1] Last Printed: March 13, 2009 - 10:11am By: Alderman

SIDE A


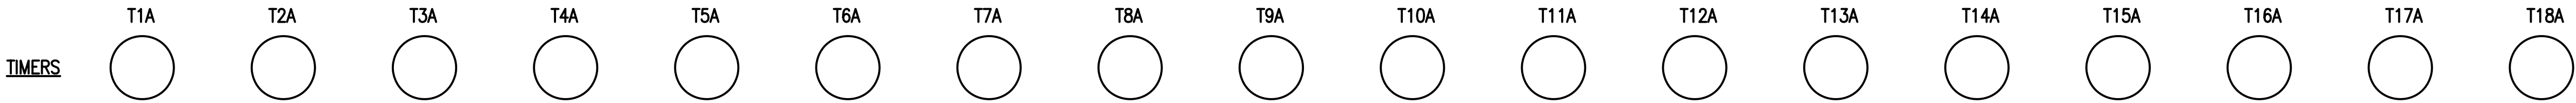


SIDE B

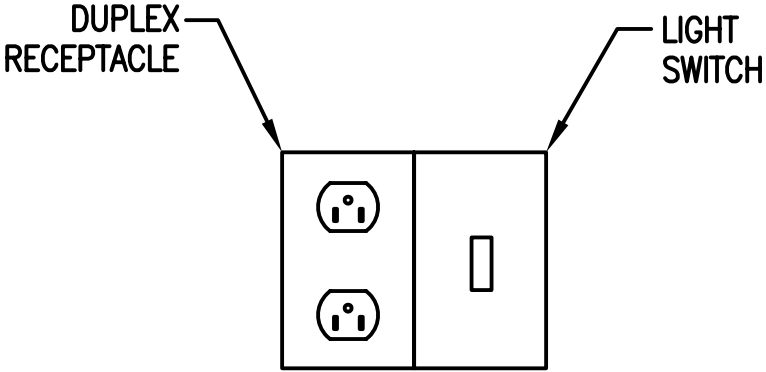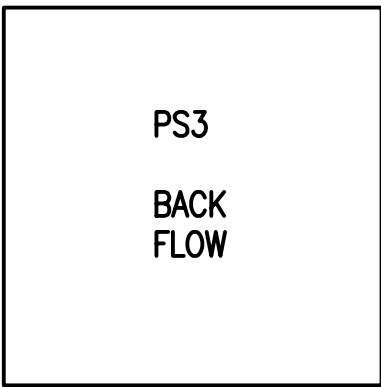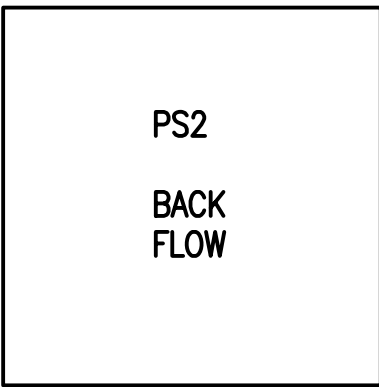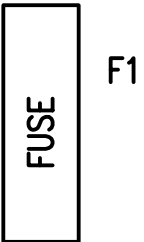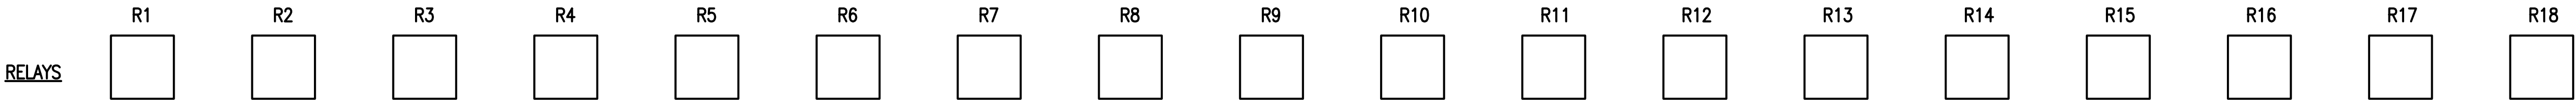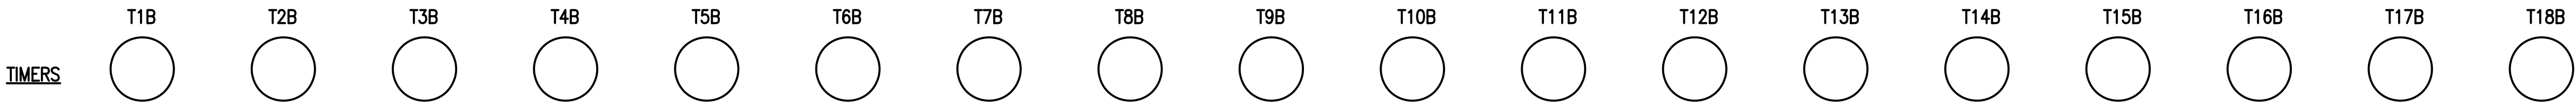


TERMINAL BLOCKS

CONTROL PANEL - INSIDE
SCALE: NONE

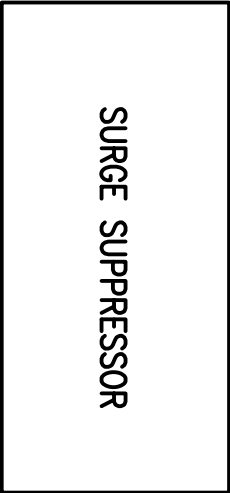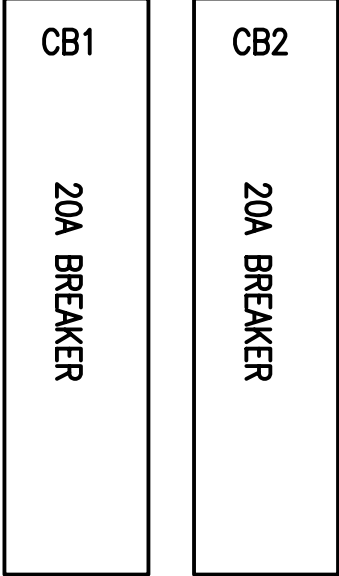

ENGINEER OF RECORD
JOSEPH W. BOWMAN
REGISTRATION NUMBER
FL LIC. NO. 59881

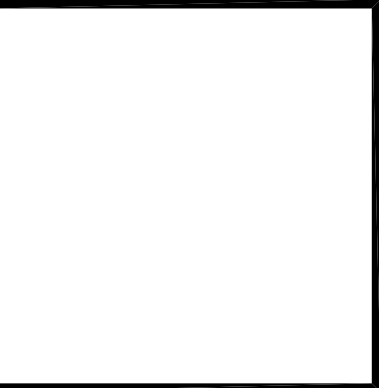

Cert. of Auth. No.
CA-1818

These drawings are copy-
righted and the property
of Polyengineering. Any
use, partial or full repro-
duction is prohibited
except by written Agree-
ment with Polyengineering

BOB SIKES PARK
WWTF EFFLUENT DISPOSAL
EXPANSION
PHASE II
OKALOOSA COUNTY WATER AND SEWER SYSTEM
OKALOOSA COUNTY, FLORIDA

POLYENGINEERING, INC.
ARCHITECTURE, ENGINEERING, SOLUTIONS

Post Office Box 841
102 Sunset Lane
Shalimar, Florida 32579
850-609-1100
WWW.POLYENGINEERING.COM

Revisions			
Key	Drawn By	Apprvd. By	Date
Δ			
Δ			
Δ			
Δ			

Field Book No.
.

Drawn By
CEB

Apprvd. By
JWB

Date
FEBRUARY 2009





































Project No.
41-264

Sheet title
CONTROL
PANEL
INSIDE

Sheet No

E-4
4 of 5

Polyengineering, Inc. - G:\CLEANSTUFF-29-999\41264 CrestView WWTF Operating Permit\WP\PHASE 1\ELECTRICAL\E-5.dwg [Layout1] Last Printed: March 13, 2009 - 10:12am By: Alderman

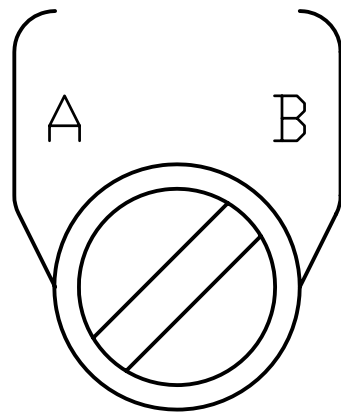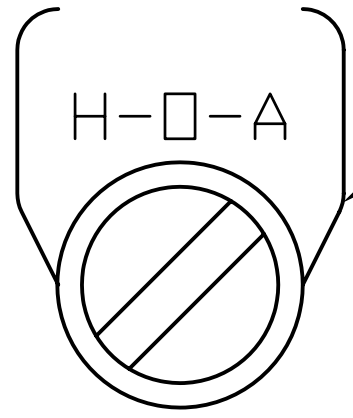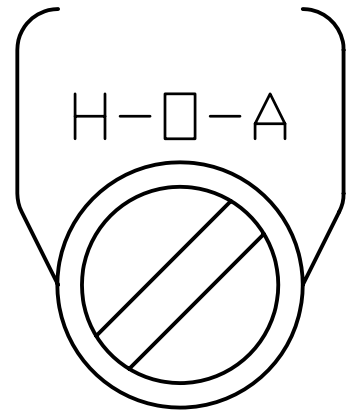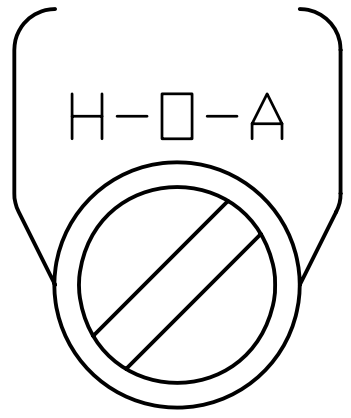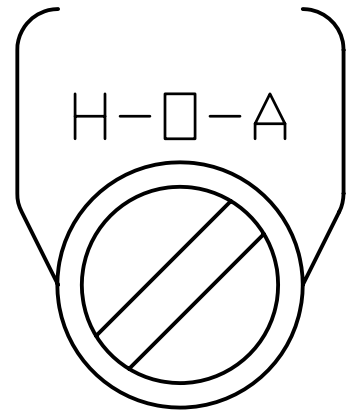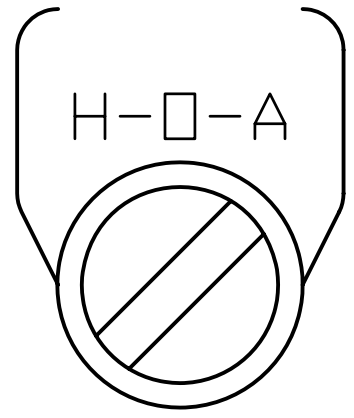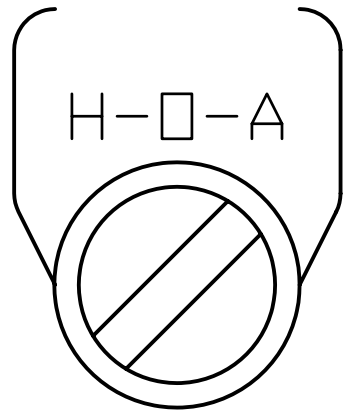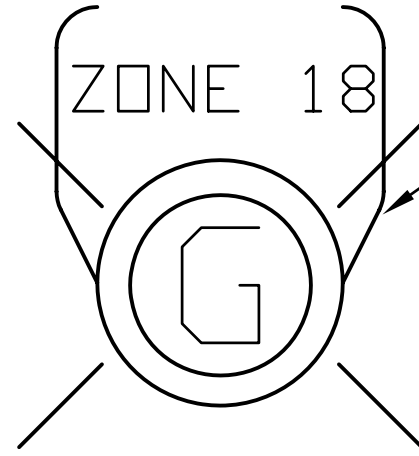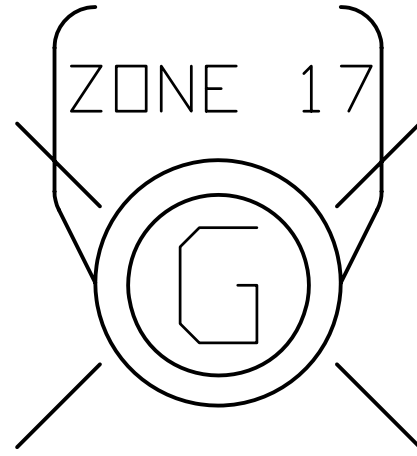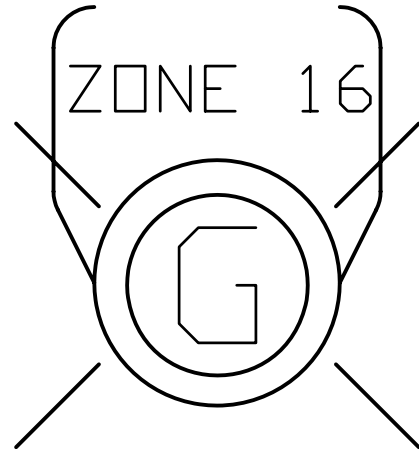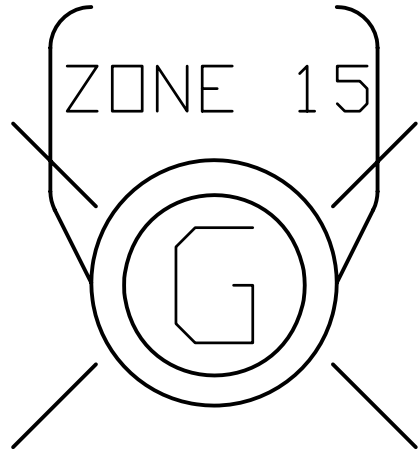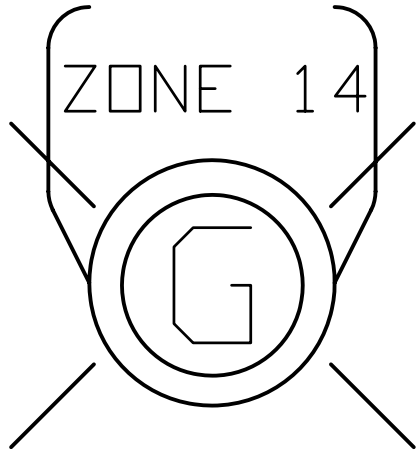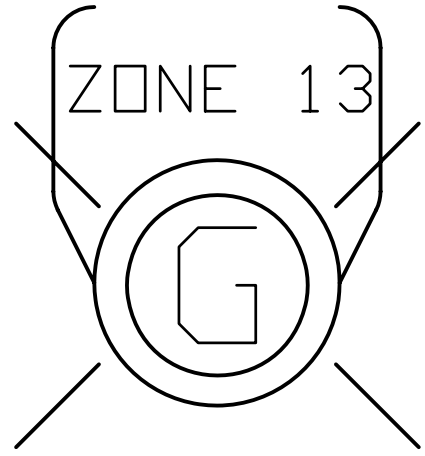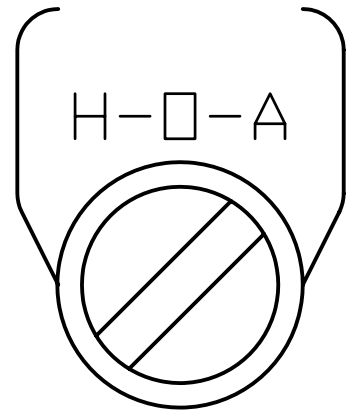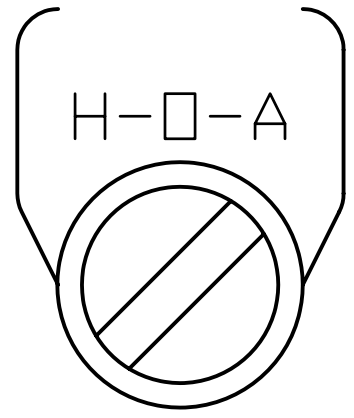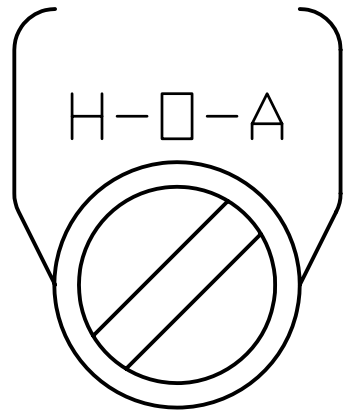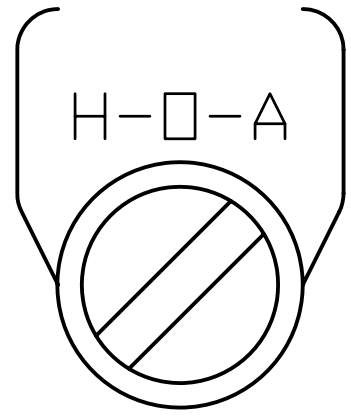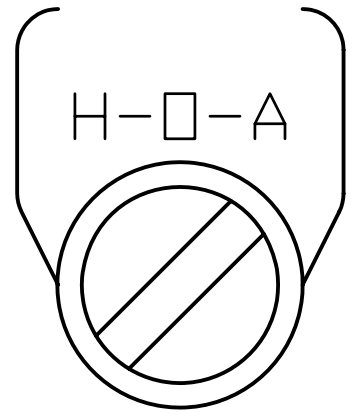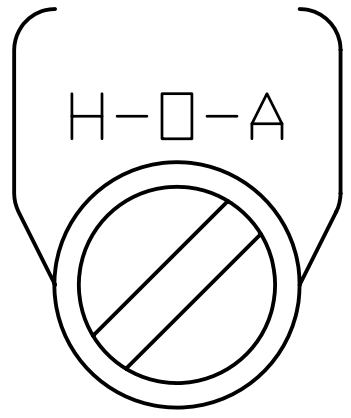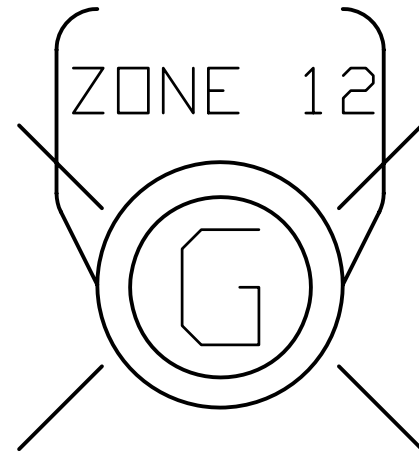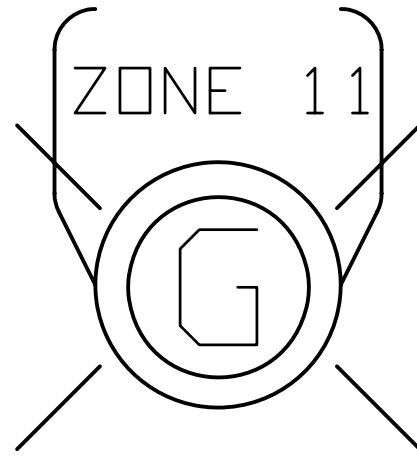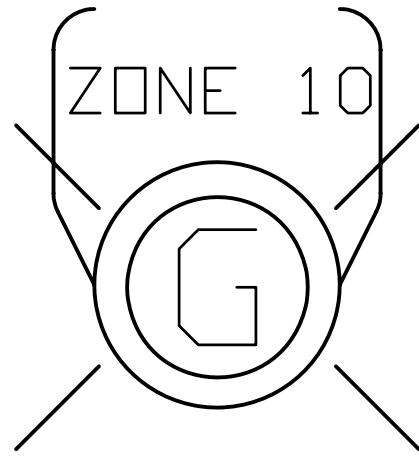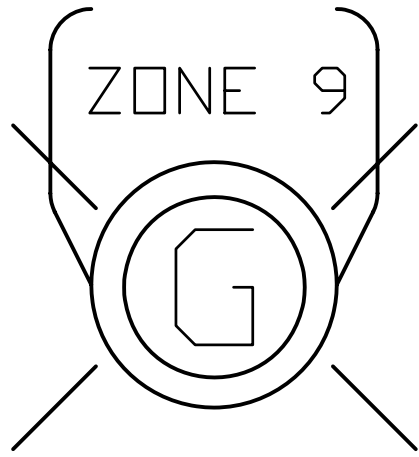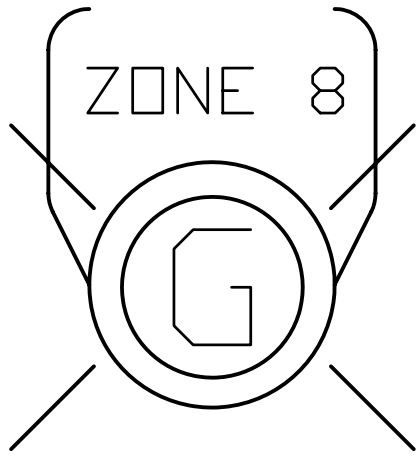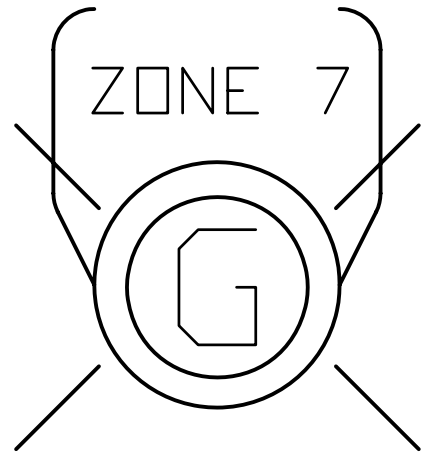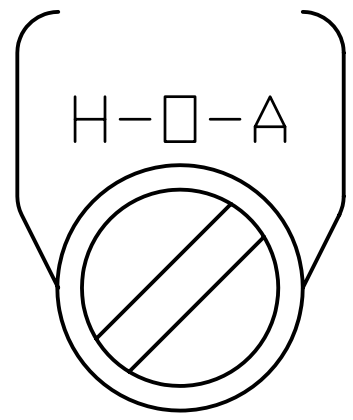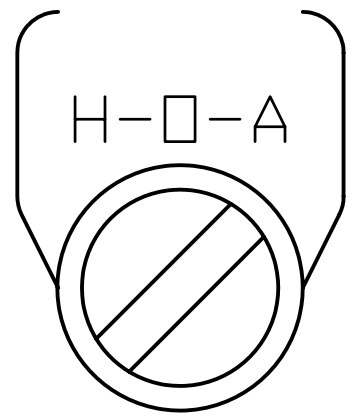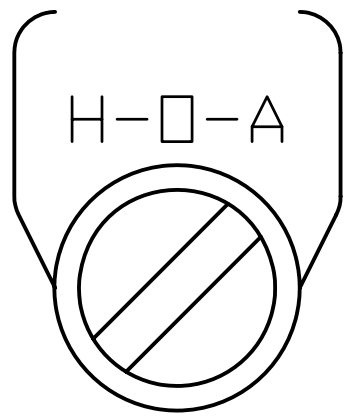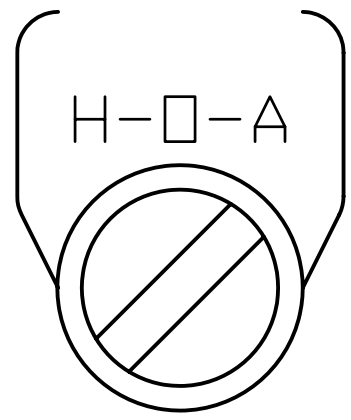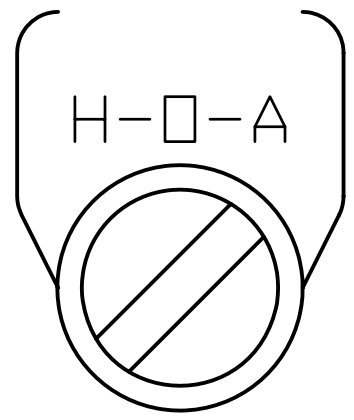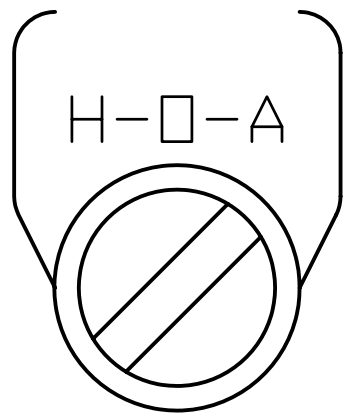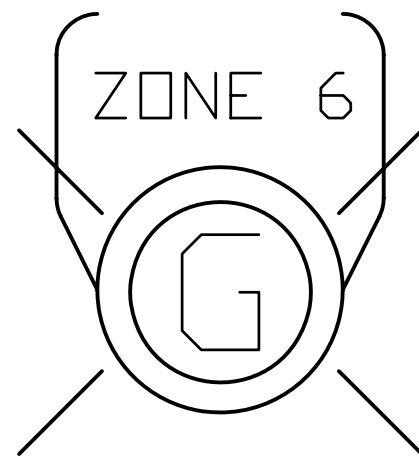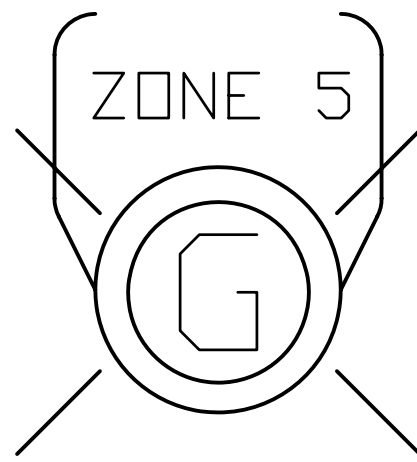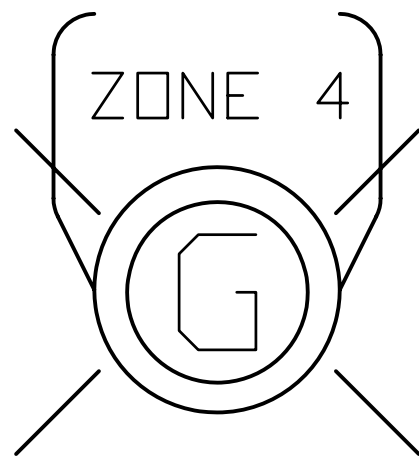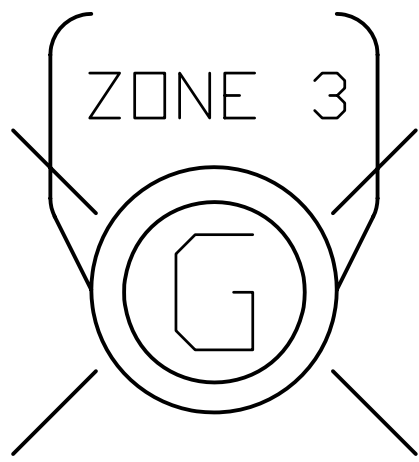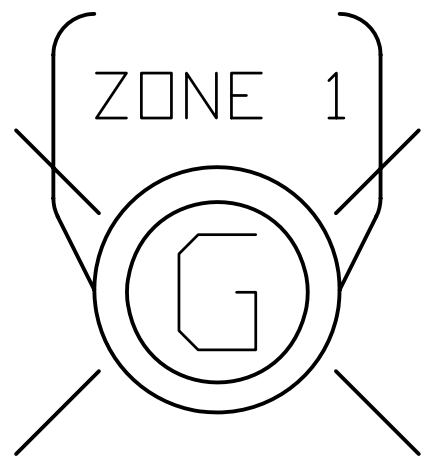


CONTROL PANEL - FRONT
SCALE: NONE

PILOT LIGHT (TYPICAL)

HAND-OFF-AUTO ROTARY SELECTOR
SWITCH (TYPICAL)

ENGINEER OF RECORD
JOSEPH W. BOWMAN
REGISTRATION NUMBER
FL LIC. NO. 59881

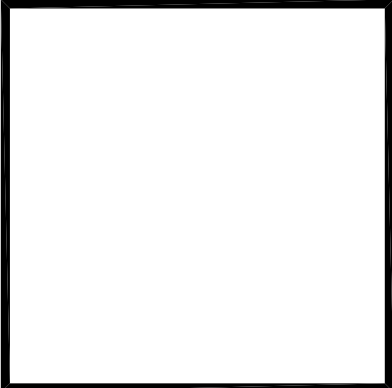

Cert. of Auth. No.
CA-1818

These drawings are copy-
righted and the property
of Polyengineering. Any
use, partial or full repro-
duction is prohibited
except by written Agree-
ment with Polyengineering

BOB SIKES PARK
WWTF EFFLUENT DISPOSAL
EXPANSION
PHASE II
OKALOOSA COUNTY WATER AND SEWER SYSTEM
OKALOOSA COUNTY, FLORIDA

POLYENGINEERING, INC.
ARCHITECTURE, ENGINEERING, SOLUTIONS

Post Office Box 841
102 SUNSET LANE
SHALIMAR, FLORIDA 32579
850-609-1100
WWW.POLYENGINEERING.COM

Revisions			
Key	Drawn By	Apprvd. By	Date
1			
2			
3			
4			

Field Book No.
.

Drawn By
CEB

Apprvd. By
JWB

Date
FEBRUARY 2009

Project No.
41-264

Sheet title
CONTROL
PANEL
FRONT

Sheet No
E-5
5 of 5