
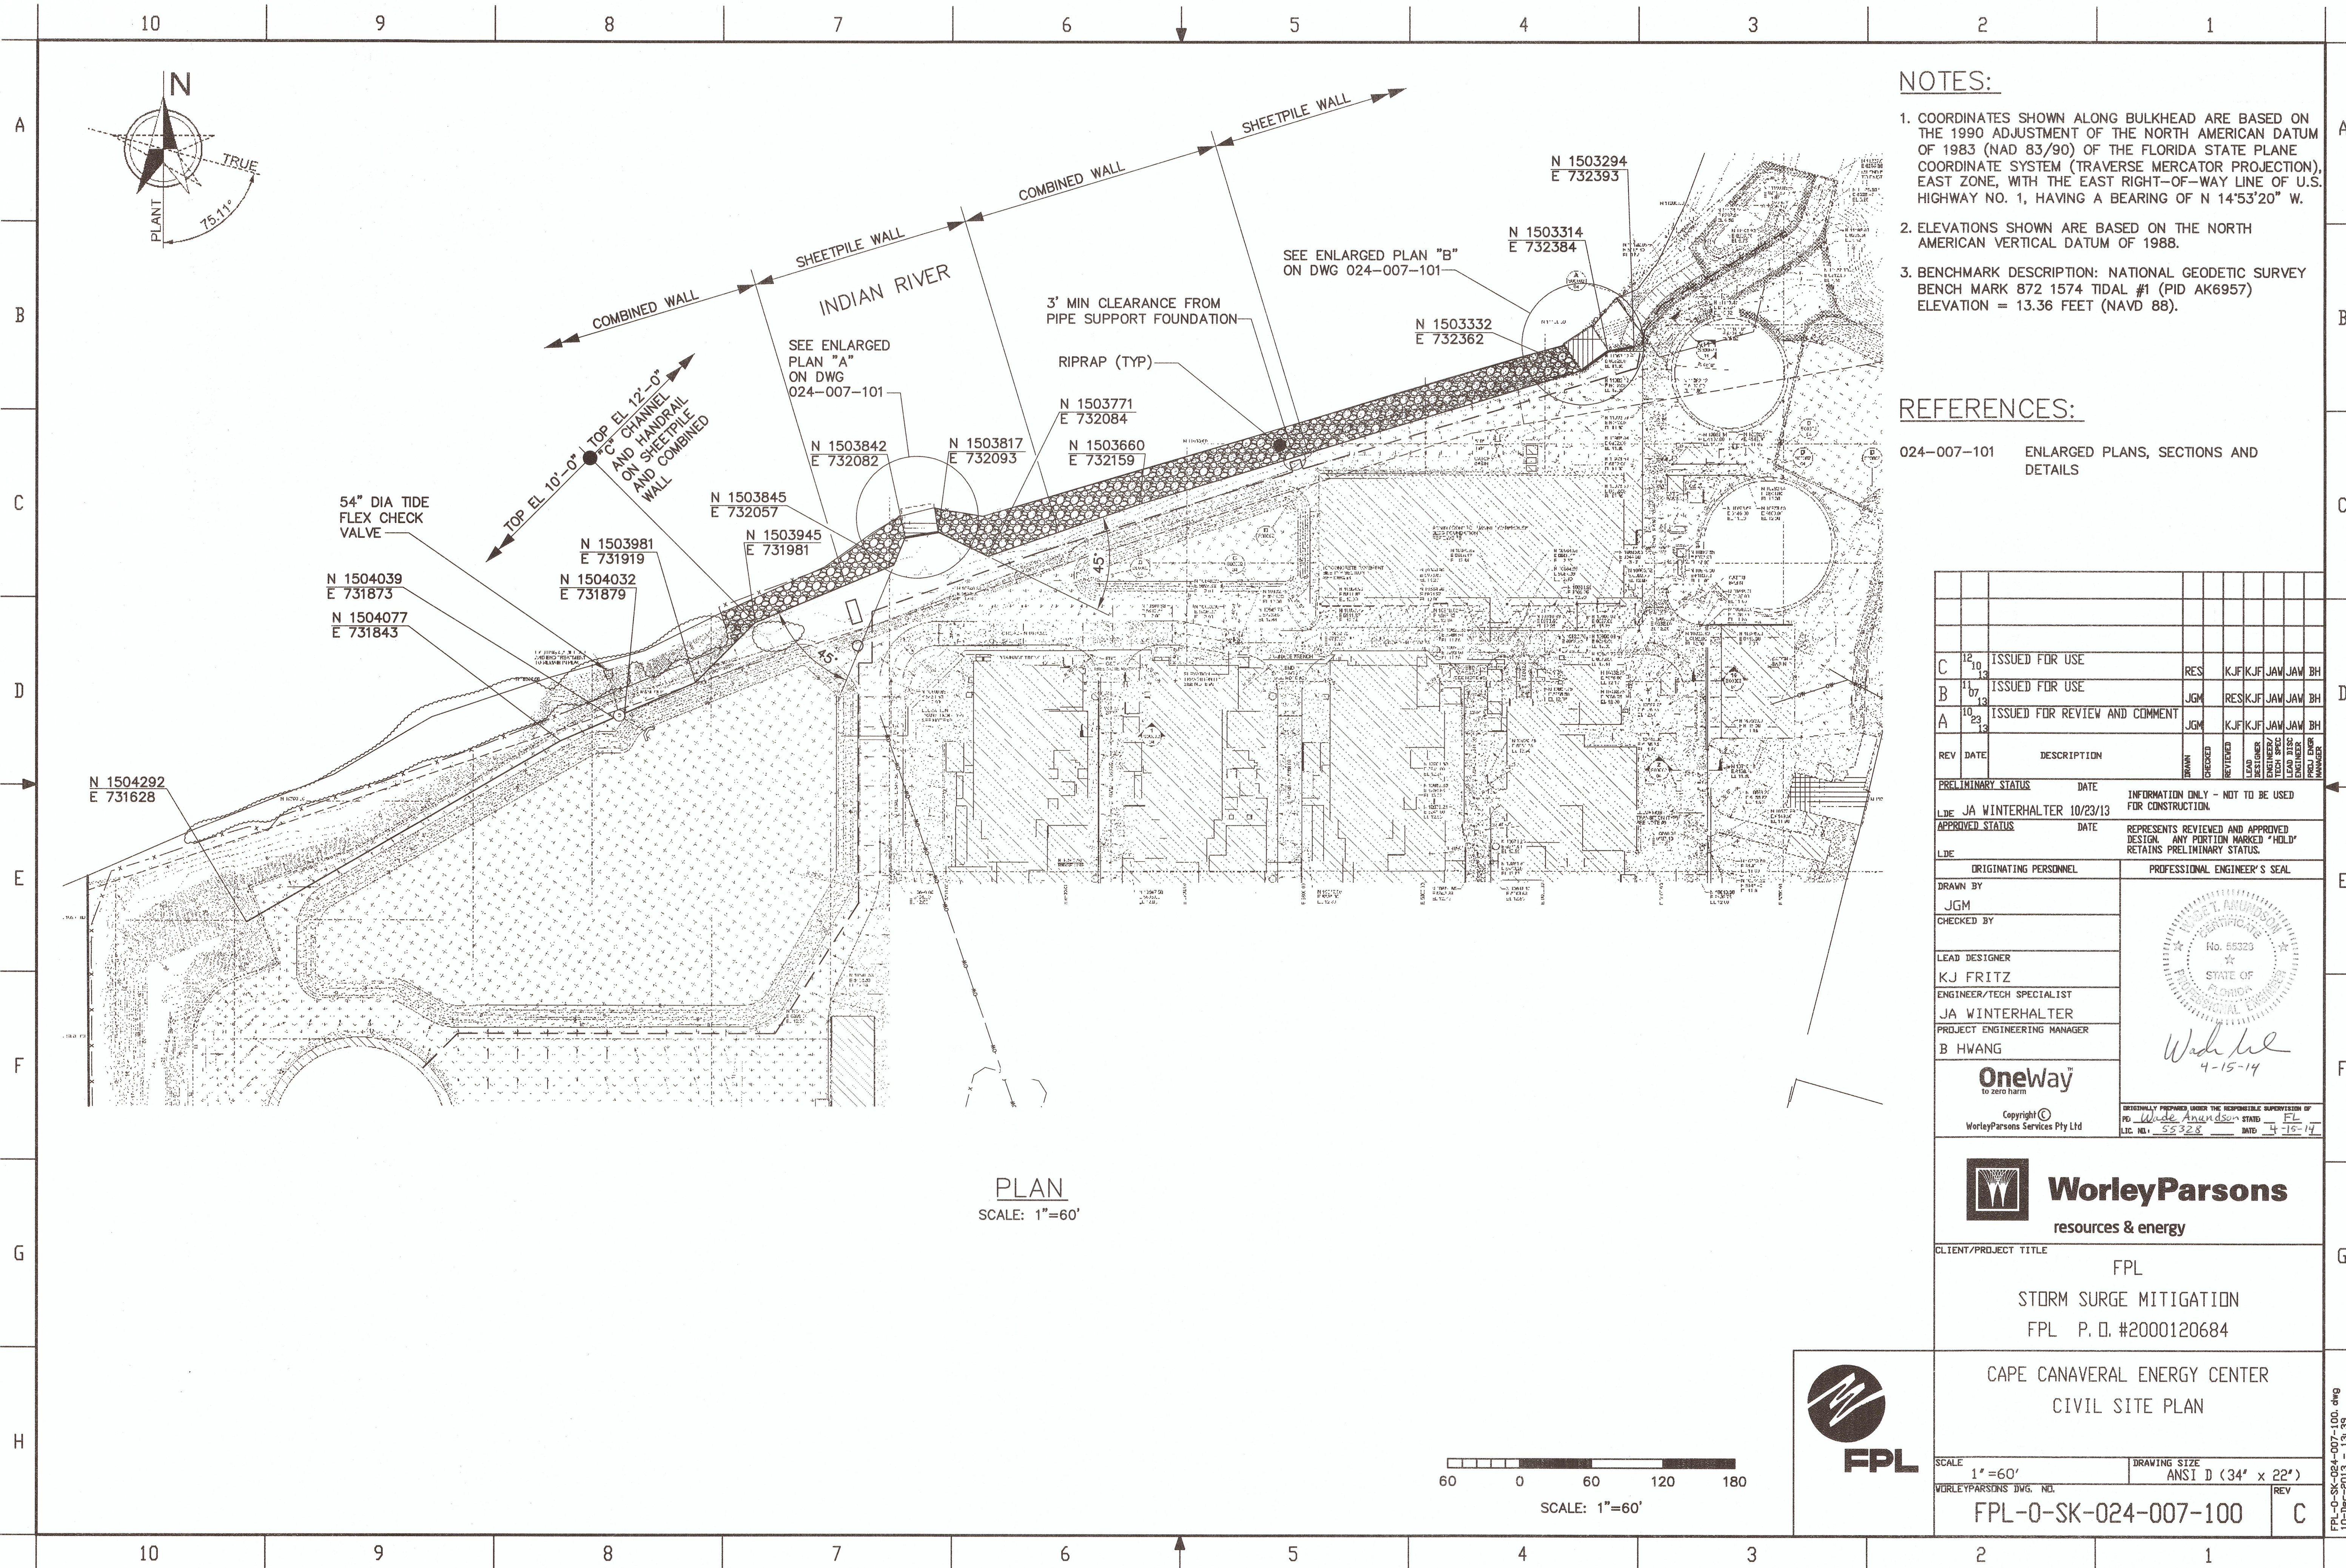


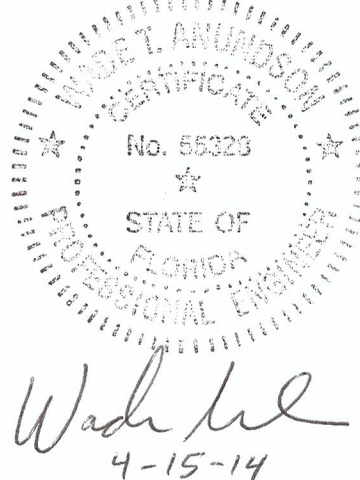


- NOTES:
- COORDINATES SHOWN ALONG BULKHEAD ARE BASED ON THE 1990 ADJUSTMENT OF THE NORTH AMERICAN DATUM OF 1983 (NAD 83/90) OF THE FLORIDA STATE PLANE COORDINATE SYSTEM (TRAVERSE MERCATOR PROJECTION), EAST ZONE, WITH THE EAST RIGHT-OF-WAY LINE OF U.S. HIGHWAY NO. 1, HAVING A BEARING OF N 14°53'20" W.
 - ELEVATIONS SHOWN ARE BASED ON THE NORTH AMERICAN VERTICAL DATUM OF 1988.
 - BENCHMARK DESCRIPTION: NATIONAL GEODETIC SURVEY BENCH MARK 872 1574 TIDAL #1 (PID AK6957) ELEVATION = 13.36 FEET (NAVD 88).

REFERENCES:

024-007-101 ENLARGED PLANS, SECTIONS AND DETAILS

C	12 10 13	ISSUED FOR USE	RES	KJF	KJF	JAW	JAW	BH	
B	11 07 13	ISSUED FOR USE	JGM	RES	KJF	JAW	JAW	BH	
A	10 23 13	ISSUED FOR REVIEW AND COMMENT	JGM	KJF	KJF	JAW	JAW	BH	
REV	DATE	DESCRIPTION	DRAWN	CHECKED	REVIEWED	LEAD DESIGNER	LEAD TECH SPECIALIST	LEAD ENGINEER	PRELIMINARY MANAGER
PRELIMINARY STATUS			DATE	INFORMATION ONLY - NOT TO BE USED FOR CONSTRUCTION					
LDE JA WINTERHALTER			10/23/13	REPRESENTS REVIEWED AND APPROVED DESIGN. ANY PORTION MARKED "HOLD" RETAINS PRELIMINARY STATUS.					
LDE			ORIGINATING PERSONNEL			PROFESSIONAL ENGINEER'S SEAL			
DRAWN BY									
JGM									
CHECKED BY									
LEAD DESIGNER									
KJ FRITZ									
ENGINEER/TECH SPECIALIST									
JA WINTERHALTER									
PROJECT ENGINEERING MANAGER									
B HWANG									
									
to zero harm									
Copyright ©			WorleyParsons Services Pty Ltd						
ORIGINALLY PREPARED UNDER THE RESPONSIBLE SUPERVISION OF			PD: Wade Anderson						
LIC. NO. 55328			STATE FL						
			DATE 4-15-14						

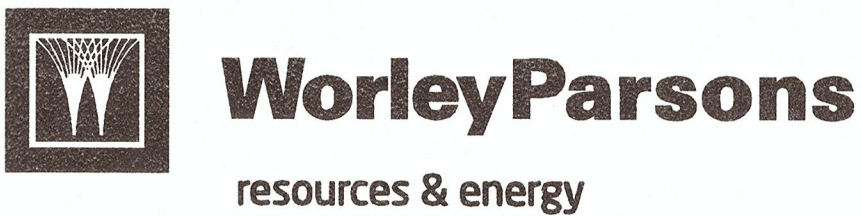

CLIENT/PROJECT TITLE

FPL

STORM SURGE MITIGATION

FPL P.D. #2000120684



CAPE CANAVERAL ENERGY CENTER	
CIVIL SITE PLAN	
SCALE	DRAWING SIZE
1"=60'	ANSI D (34" x 22")
WORLEYPARSONS' DWG. NO.	REV
FPL-O-SK-024-007-100	C

FPL-O-SK-024-007-100.dwg
10-Dec-2013 - 13:39