


SYMBOL LEGEND (FPL)	
BUILDINGS	TANK
ROADS	UTILITY POLE
SIDEWALK	LIGHT POLE
CULVERT, BRIDGE, & HEADWALL STRUCTURE	DOUBLE LIGHT POLE
RAILROAD	TRAFFIC LIGHT POLE
RAILS	TRANSMISSION POWER POLE
QUADRANT	ANTENNA
STREAM OR SHORE LINE	WASH-HOLE / C.B. = CATCH BASIN
LAKE OR POND	UTILITY OBJECT
WOODED AREA	FIRE HYDRANT (F.H.)
BRUSH AREA	POST
FENCE	SON
	CURRENT LAND USE BOUNDARY
	PAVEMENT
	CONCRETE
	WATER
	GRASS
	GRAVEL

SYMBOL LEGEND (GOLDER)	
CERTIFIED SITE BOUNDARY	

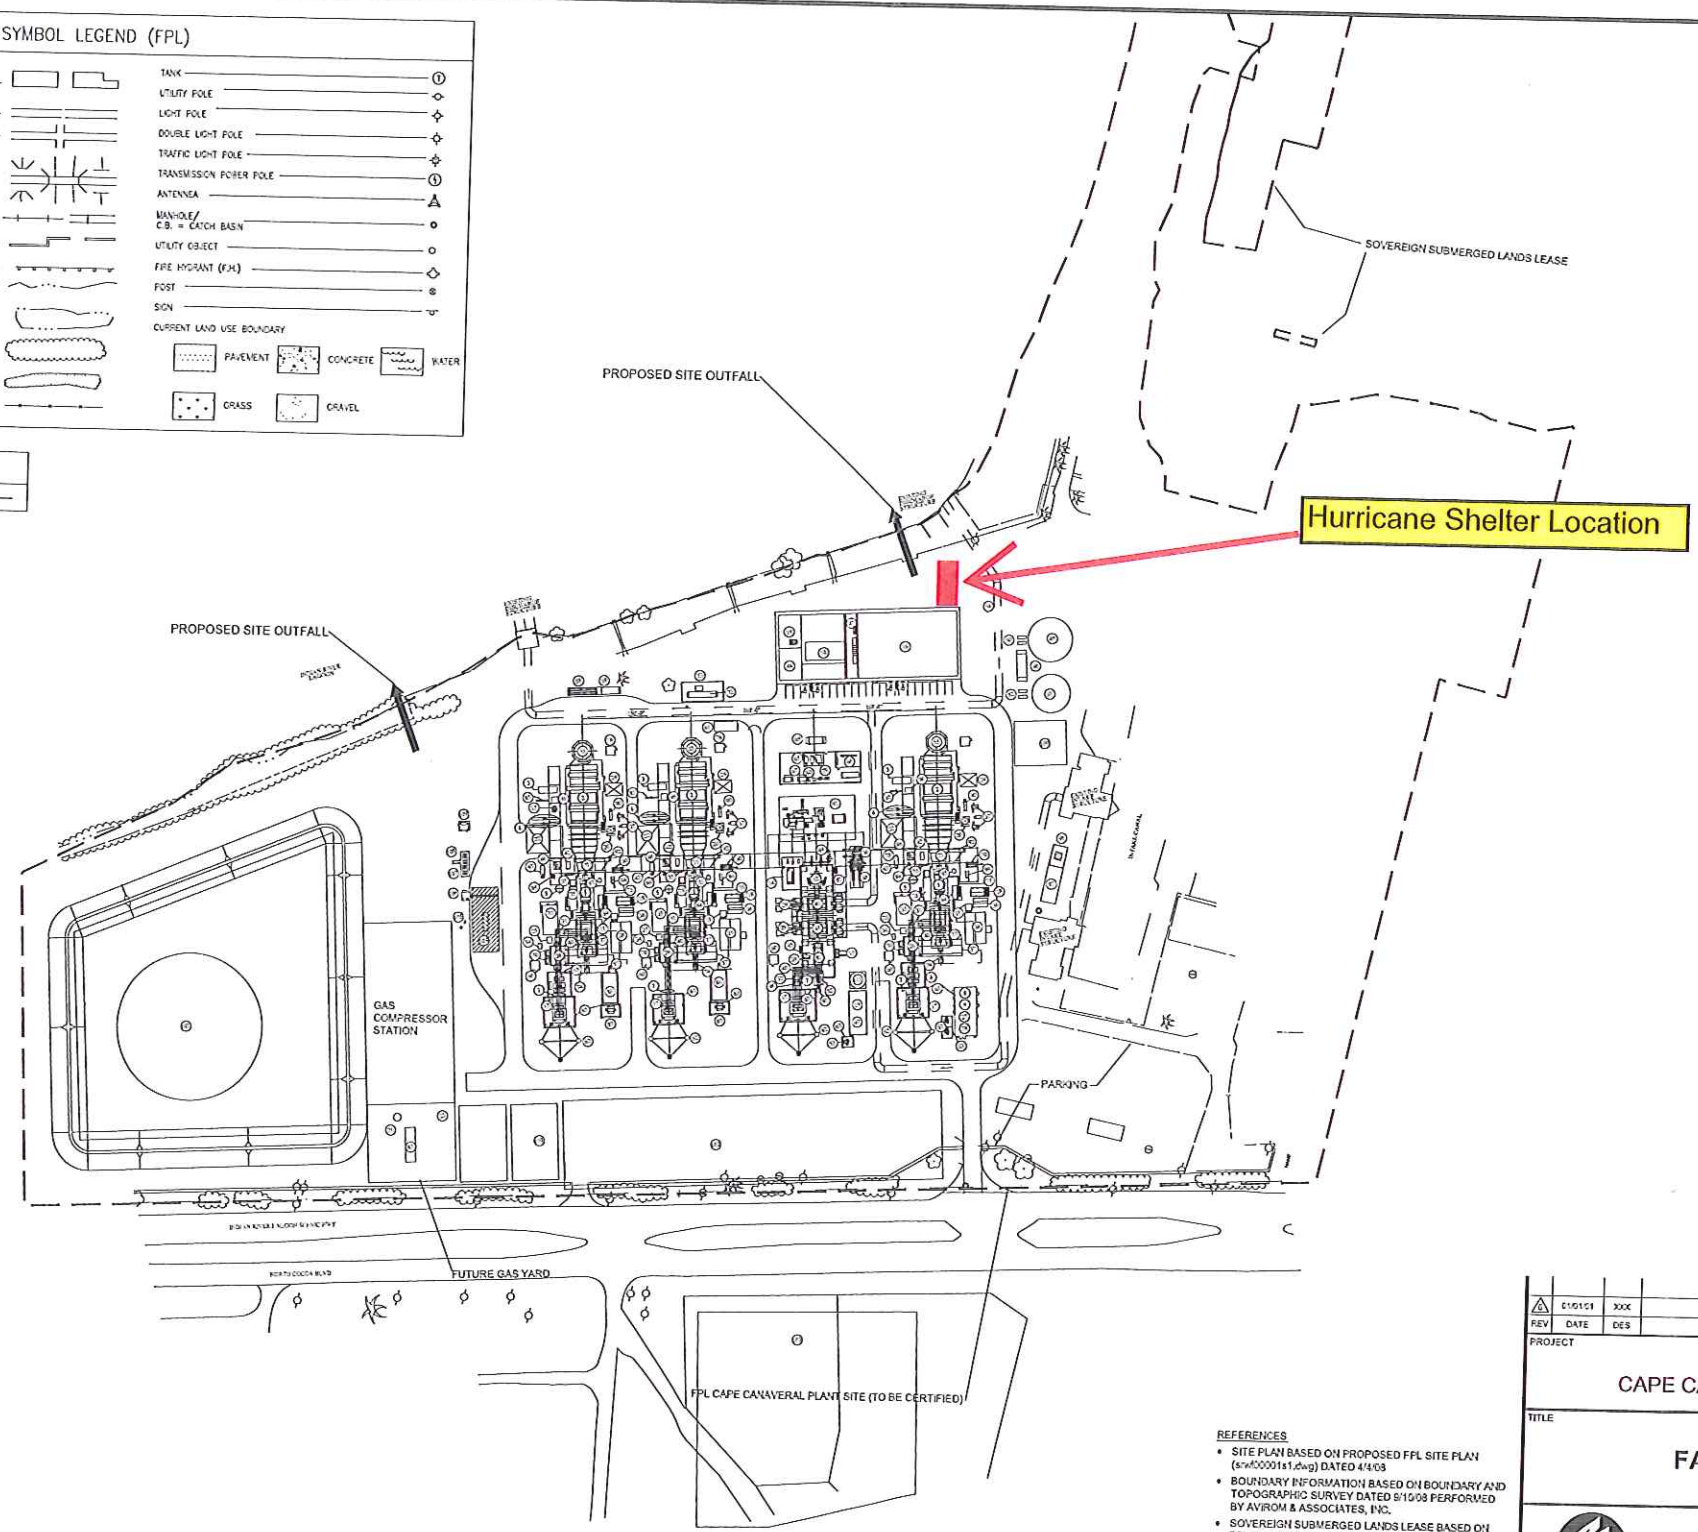


- LEGEND**
1. GAS TURBINE AND GENERATOR
 2. HXSO
 3. FUELER FEED WATER PUMP
 4. UNIT AUX TRANSFORMER
 5. COMBUSTION TURBINE TCA COOLER
 6. FUEL GAS PERFORMANCE HEATER
 7. ISOHASE BUS DUCT
 8. ELECTRICAL EQUIPMENT BUILDING
 9. BATTERY ROOM
 10. ADMINISTRATION BUILDING
 11. GT WASH WATER SUMP
 12. STEAM TURBINE
 13. HXSO BLOWDOWN TANK
 14. STEAM TURBINE OIL UNIT
 15. CONDENSATE PUMPS
 16. WAREHOUSE BUILDING
 17. GENERATOR STARTUP TRANSFORMER
 18. CT LIQUID FUEL ATOMIZING AIR MOUTH (LFAA)
 19. DCS EQUIPMENT
 20. AIG SKID
 21. FUEL GAS DRAINS TANK (FUTURE)
 22. MAINTENANCE LAYDOWN AREA
 23. FUEL GAS YARD (FUTURE)
 24. SCR REMOVAL AREA
 25. CT GENERATOR EXCITATION TRANSFORMER
 26. COMBUSTION TURBINE EXCITATION COMPARTMENT
 27. 480V SWITCHGEAR TRANSFORMER
 28. HXN SWITCHGEAR
 29. CONDENSER TUBE REMOVAL AREA
 30. CAUSTIC FEED TANK
 31. ELUOTIC FUEL OIL HEATER
 32. ST EXCITATION TRANSFORMER
 33. COMBUSTION TURBINE ELECTRICAL PACKAGE
 34. COMBUSTION TURBINE SUSP. FE & SA CUBICLE
 35. COMBUSTION TURBINE 2C COOLER
 36. GT COI FIRE PROTECTION SKID
 37. AMMONIA DILUTION AIR FANS
 38. GT LIFF OIL UNIT
 39. ST GENERATOR SEAL OIL UNIT
 40. NGR CUBICLE
 41. STEAM TURBINE CONDENSER
 42. GT WASH UNIT
 43. WASH WATER DRAINS TANK
 44. STEAM TURBINE AREA BLOWDOWN TANK
 45. STEAM JET AIR EJECTOR
 46. FUE PUMPS
 47. 4150/400 DRY TYPE TRANSFORMER/MCC/SWITCHGEAR
 48. COST OIL ROOM
 49. RAW WATER STORAGE TANK
 50. RAW WATER PUMPS
 51. DEMINERALIZED WATER STORAGE TANK
 52. DEMINERALIZED WATER PUMPS
 53. 4150/400 S114 TRANSFORMER
 54. CIRCULATING WATER LINES
 55. STACK
 56. ACW CLOSED CYCLE COOLING WATER PUMPS
 57. GT AIR INLET FILTER
 58. HYDROGEN BULK STORAGE
 59. COI STORAGE CYLINDERS
 60. DELUGE HOSES
 61. OIL/WATER SEPARATOR
 62. DEADEND STRUCTURE
 63. FIREWALL
 64. FUEL OIL INLET FILTER
 65. CYCLE CHEMICAL FEED EQUIPMENT
 66. CHEMICAL LAB SAMPLE PANEL
 67. AIR COOLER FISSILES
 68. ACW CLOSED CYCLE COOLING WATER HEAT EXCHANGERS
 69. EMERGENCY DIESEL GENERATOR
 70. EXCITATION PACKAGE COOLING UNIT
 71. CT ENCLOSURE VENT FAN
 72. AMMONIA TANK
 73. AMMONIA VAPORIZING SKID
 74. CT MOTOR REMOVAL
 75. CT TURBINE ENCLOSURE
 76. CENG
 77. CT SEAL OIL UNIT
 78. FUE RACK
 79. AIR DRYERS
 80. AIR RECEIVER
 81. STEAM TURBINE GENERATOR
 82. ST STATOR COOLING UNIT
 83. FUEL GAS METERING (FUTURE)
 84. FUEL GAS FILTER/SEPARATOR
 85. STARTUP GAS HEATER
 86. FUEL GAS COALFISCING FILTER
 87. EIPC UNIT
 88. COMBUSTION TURBINE SEC
 89. COMBUSTION TURBINE SEC TRANSFORMER
 90. DUCT BURNER MANAGEMENT SKID
 91. ST ROTOR REMOVAL AREA
 92. EXPANSION JONT REMOVAL
 93. COMBUSTION TURBINE PURGE AIR RECEIVER
 94. FUEL OIL MANAGEMENT SPOOL PIECE
 95. AUXILIARY BOILER
 96. HXSO BLOWDOWN SUMP
 97. CIRCULATING WATER CHEMICAL FEED
 98. STEAM TURBINE EXCITATION PACKAGE
 99. SULFURIC ACID STORAGE TANK
 100. DEMINERALIZER WATER TRAILER AREA
 101. EXISTING FUEL OIL TANK
 102. 1250V SWITCHYARD
 103. 230V SWITCHYARD
 104. FUEL OIL UNLOADING STATION
 105. FUEL OIL LEAK DETECTION
 106. FUEL OIL AREA SUMP
 107. FUEL OIL UNLOADING PUMPS
 108. FUEL OIL FORWARDING PUMPS
 109. FOAM SUPPRESSION SYSTEM
 110. EXISTING GAS YARD
 111. CIRCULATING WATER DISCHARGE CHEM FEED TANK


REFERENCES

- SITE PLAN BASED ON PROPOSED FPL SITE PLAN (s=0000181.dwg) DATED 4/1/03
- BOUNDARY INFORMATION BASED ON BOUNDARY AND TOPOGRAPHIC SURVEY DATED 5/10/03 PERFORMED BY AVROM & ASSOCIATES, INC.
- SOVEREIGN SUBMERGED LANDS LEASE BASED ON FPL DRAWING NA-CC042095 DATED 1993
- STORMWATER BASED ON BOYLE ENGINEERING CORP. POST DEVELOPMENT DETENTION AREA SITEV2, EXHIBIT, DATED 5/3/03


REV	DATE	DES	REV	DATE	DES	REV	DATE	DES	REV	DATE	DES
1	01/01/03	XXX									
REVISION DESCRIPTION											
PROJECT											
FPL CAPE CANAVERAL ENERGY CENTER											
TITLE											
FACILITY PLOT PLAN											
PROJECT No. 05347833			FILE No. 08387833A037			SCALE AS SHOWN			REV. 1		
DESIGN -			SCALE			AS SHOWN			REV. 1		
CADD NPL 12/15/08											
CHECK RCM 12/15/08											
REVIEW KFK 12/15/08											
FIGURE 4.2.0-1											

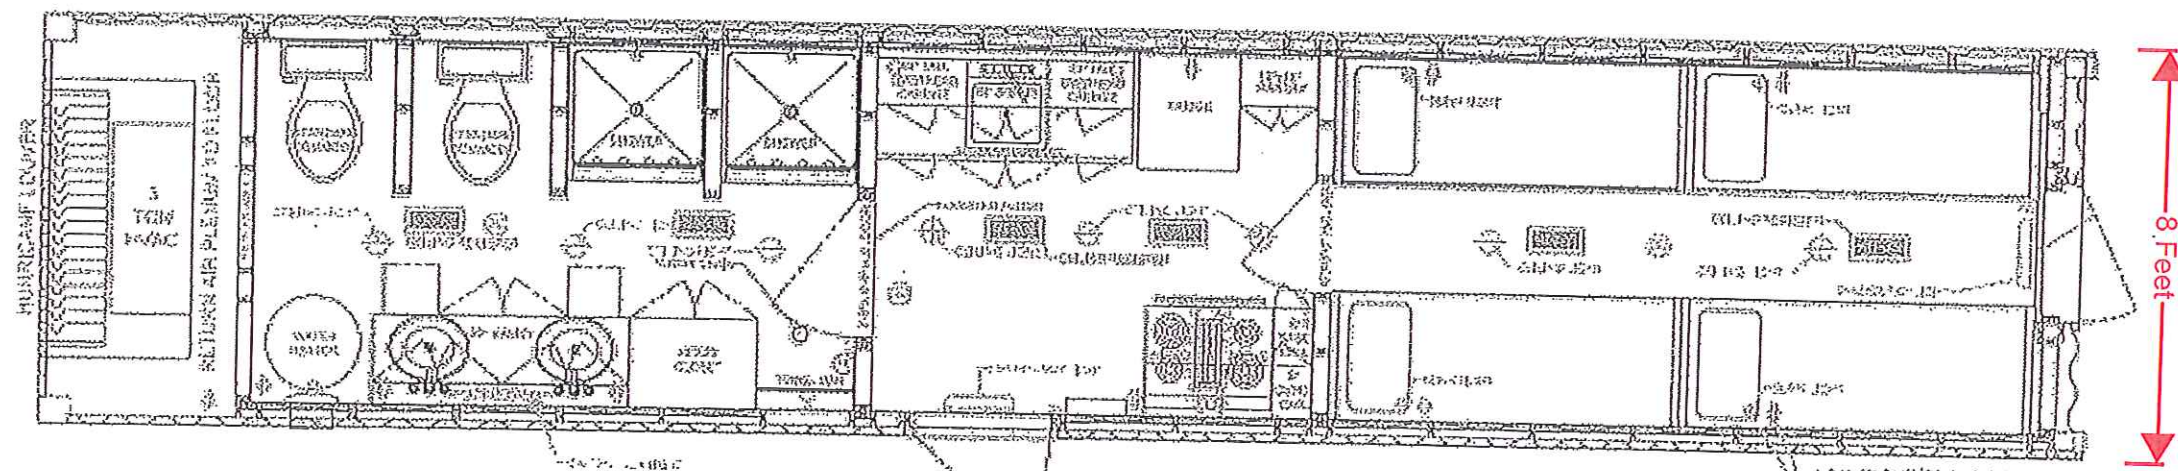

PLAN VIEW

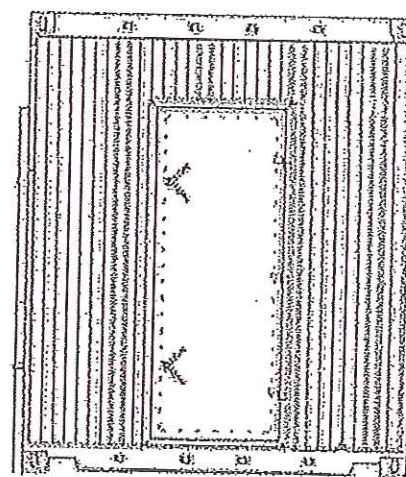

END VIEW

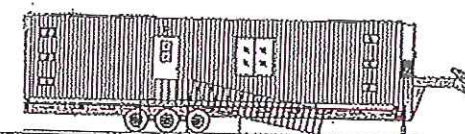

12 MAN HURRICANE SHELTER

SIZE	CLIENT	REV
B	F. P. & L. - PLANT CANAVERAL	-
NUMBER	TYPE	SHEET