



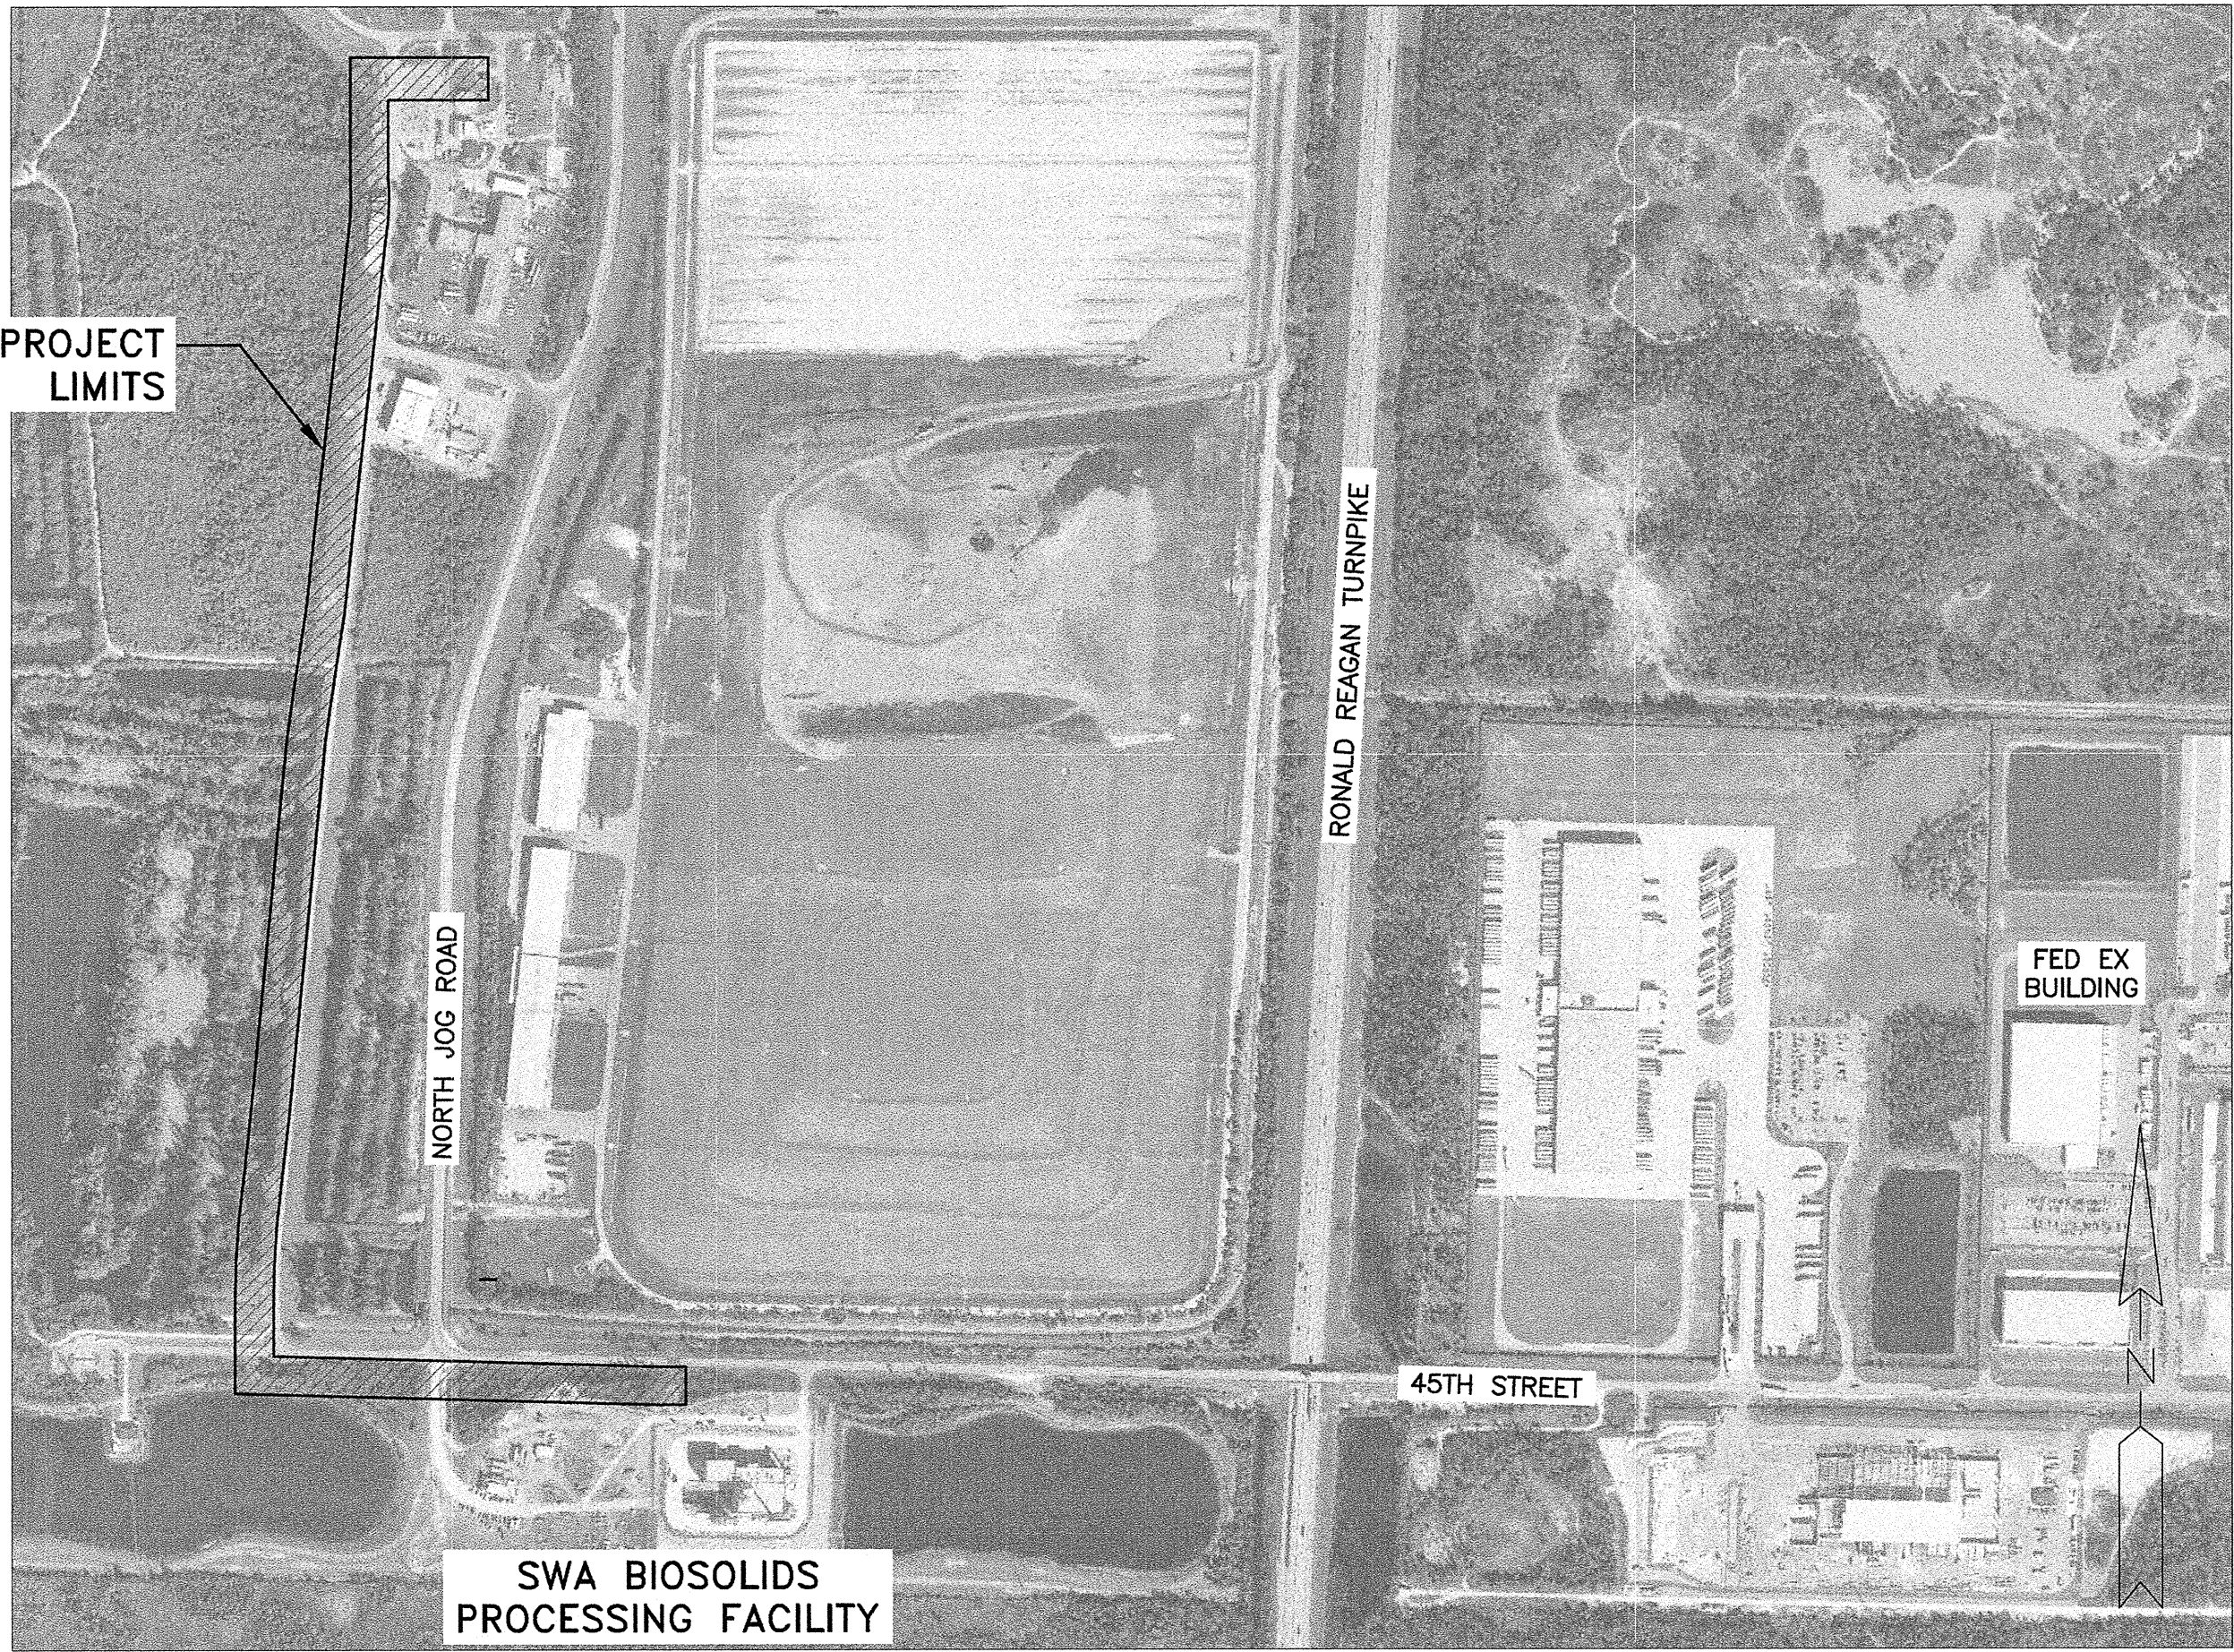

BIOSOLIDS PROCESSING FACILITY

INDUSTRIAL WASTE FORCE MAIN PROJECT

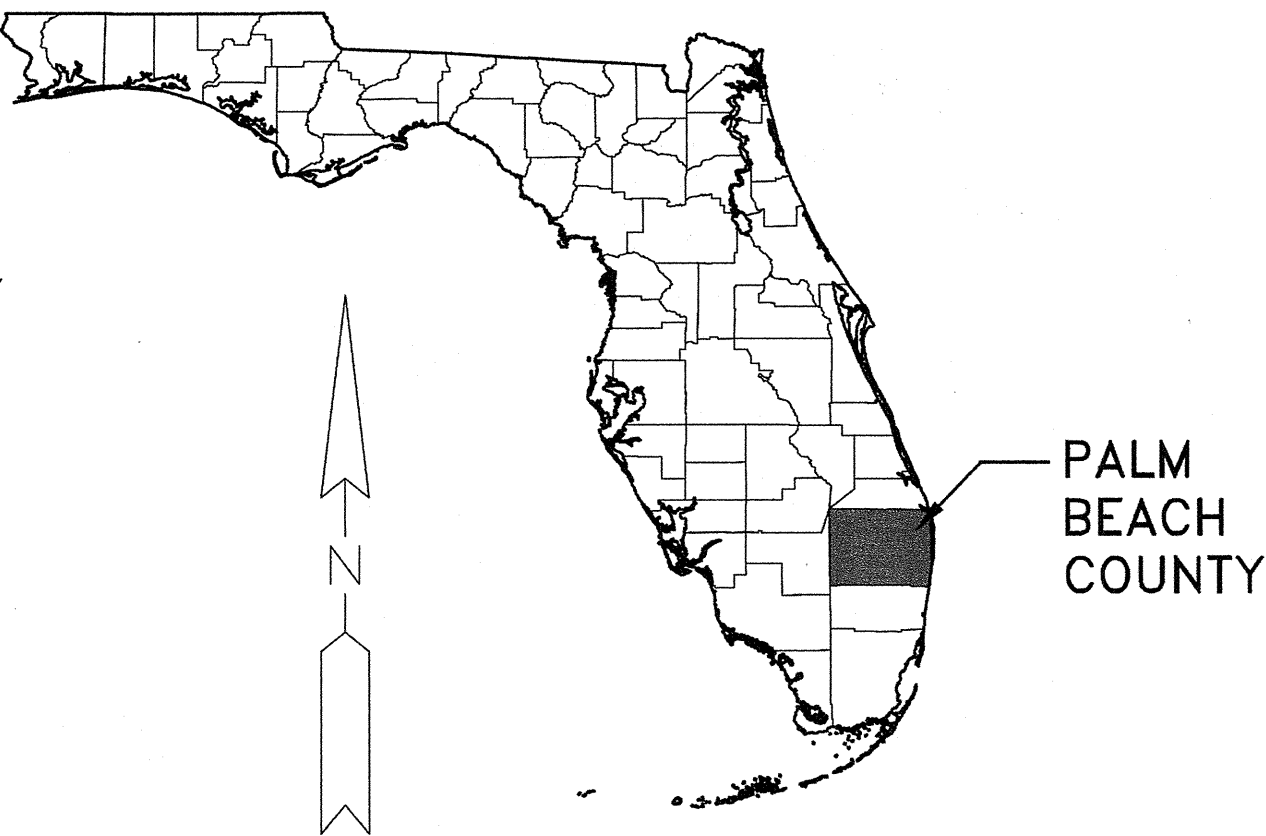

LOCATION MAP
SCALE: NOT TO SCALE

SHEET INDEX

- G-1 COVER
- G-2 GENERAL CIVIL LEGEND
- G-3 GENERAL NOTES
- G-4 STORM WATER POLLUTION PREVENTION PLAN
- C-1 OVERALL FORCEMAIN PLAN/KEY PLAN
- C-2 FORCEMAIN PLAN AND PROFILE STA:1+00.00 TO STA:10+00.00
- C-3 FORCEMAIN PLAN AND PROFILE STA:10+00.00 TO STA:15+24.90
- C-4 FORCEMAIN PLAN AND PROFILE STA:15+24.90 TO STA:23+50.00
- C-5 FORCEMAIN PLAN AND PROFILE STA:23+50.00 TO STA:34+50.00
- C-6 FORCEMAIN PLAN AND PROFILE STA:34+50.00 TO STA:45+00.00
- C-7 FORCEMAIN PLAN AND PROFILE STA:45+00.00 TO STA:52+87.50
- C-8 FORCEMAIN PLAN AND PROFILE STA:52+87.50 TO STA:55+42.39
- C-9 SANITARY SEWER LATERAL PLAN SWA BIOSOLIDS PROCESSING FACILITY
- C-10 SANITARY LIFT STATION FORCEMAIN PLAN
- P-1 PROCESS PIPING LEGEND
- P-2 LIFT STATION PLAN SWA BIOSOLIDS PROCESSING FACILITY
- P-3 PUMP STATION DETAILS
- P-4 FORCEMAIN DISCHARGE DETAIL PLAN
- P-5 TYPICAL DETAILS
- P-6 TYPICAL DETAILS
- P-7 TYPICAL DETAILS
- P-8 TYPICAL DETAILS
- P-9 SWA PROCESSING FACILITY MAIN LEVEL DRAINAGE PLUMBING ISOMETRIC
- P-10 SWA PROCESSING FACILITY SECOND FLOOR DRAINAGE PLUMBING ISOMETRIC
- E-1 ELECTRICAL PLANS SWA BIOSOLIDS PROCESSING FACILITY
- E-2 ELECTRICAL DETAILS SWA BIOSOLIDS PROCESSING FACILITY
- E-3 ELECTRICAL DETAILS SWA BIOSOLIDS PROCESSING FACILITY
- E-4 ELECTRICAL DIAGRAMS SWA BIOSOLIDS PROCESSING FACILITY
- E-5 ELECTRICAL SCHEMATICS SWA BIOSOLIDS PROCESSING FACILITY
- E-6 ELECTRICAL SCHEMATICS SWA BIOSOLIDS PROCESSING FACILITY
- L-1 LIFT STATION LANDSCAPE PLAN

KEY MAP
NOT TO SCALE

NOT VALID FOR CONSTRUCTION UNLESS SIGNED AND DATED:	
JOB NO. NEF2001-01L	SHEET G-1
WADETRIM 3790 Dixie Highway NE, Suite D Palm Bay, FL 32905 321.728.3389 FAX: 321.728.3393 Certificate of Authorization No.: 3952 www.wadetrin.com Building relationships on a foundation of excellence	
PREPARED UNDER THE SUPERVISION OF: ENGINEER ISSUED FOR: ENVIRONMENTAL PERMITS 09/17/2012	

PROJECT MANAGER: C:\PW\WORK\MHURNE\0346037\GSS-PLTS-G-1 COVER.DWG - G-1 - PLOTTED 9/14/2012 11:01 AM BY HORNE, MICHAEL

