



April 2, 2012

Ms. Cindy Mulkey
Florida Department of Environmental Protection
Siting Office
2600 Blair Stone Road
Tallahassee, Florida 32399-3000

Re: Seminole Electric Cooperative, Inc.
Seminole Generating Station, Putnam County, Florida
Power Plant Certification No. PA78-10
Post-Certification Amendment to Application

Dear Ms. Mulkey:

Pursuant to Section 403.5113(1)(a), Florida Statutes and Rule 62-17.205, Florida Administrative Code, please accept this letter and attachments as a post-certification amendment to the Seminole Electric Cooperative, Inc. ("Seminole") Site Certification Application ("Application") for the Seminole Generating Station in Putnam County, Florida. This post-certification amendment addresses the re-location of the FGD landfill remediation system sump and associated piping from the toe of the landfill onto the landfill berm. The purpose of this re-location is to add aboveground piping with cleanouts to provide easier access to the piping for maintenance and to improve piping performance.

The attached "As Built" drawings (Attachment "A") outline the landfill piping, as it currently exists. The drawing in Attachment "B" identifies the proposed new location of the piping.

Neither installation of the new piping, nor removal of the old piping will cause any adverse environmental impacts or require any changes to the existing Conditions of Certification for the Seminole Generating Station.

If the Department concurs, Seminole requests that this letter and its attachments be forwarded to all appropriate agencies and parties to the original certification proceeding as a permissible post-certification amendment to the Application. If you or any of the parties have any


Ms. Cindy Mulkey

April 2, 2012

Page 2

questions or concerns, or require additional information, please contact me at (813) 963-0994, ext. 1224.

Sincerely,

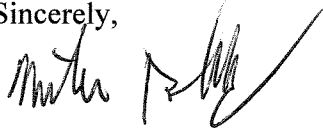A handwritten signature in black ink, appearing to read "Mike Roddy", with a long, sweeping horizontal stroke extending to the right.


 
Mike Roddy
Director, Environmental Affairs

Cc: Justin Gostnell, Seminole
Robert Yarbrough, Seminole
Jim Alves, HG&S

Attachment A

AS-BUILT SURVEY

OF SELECTED IMPROVEMENTS ON A PORTION OF SEMINOLE
ELECTRIC POWER PLANT IN THE CITY OF PALATKA, PUTNAM
COUNTY, FLORIDA.

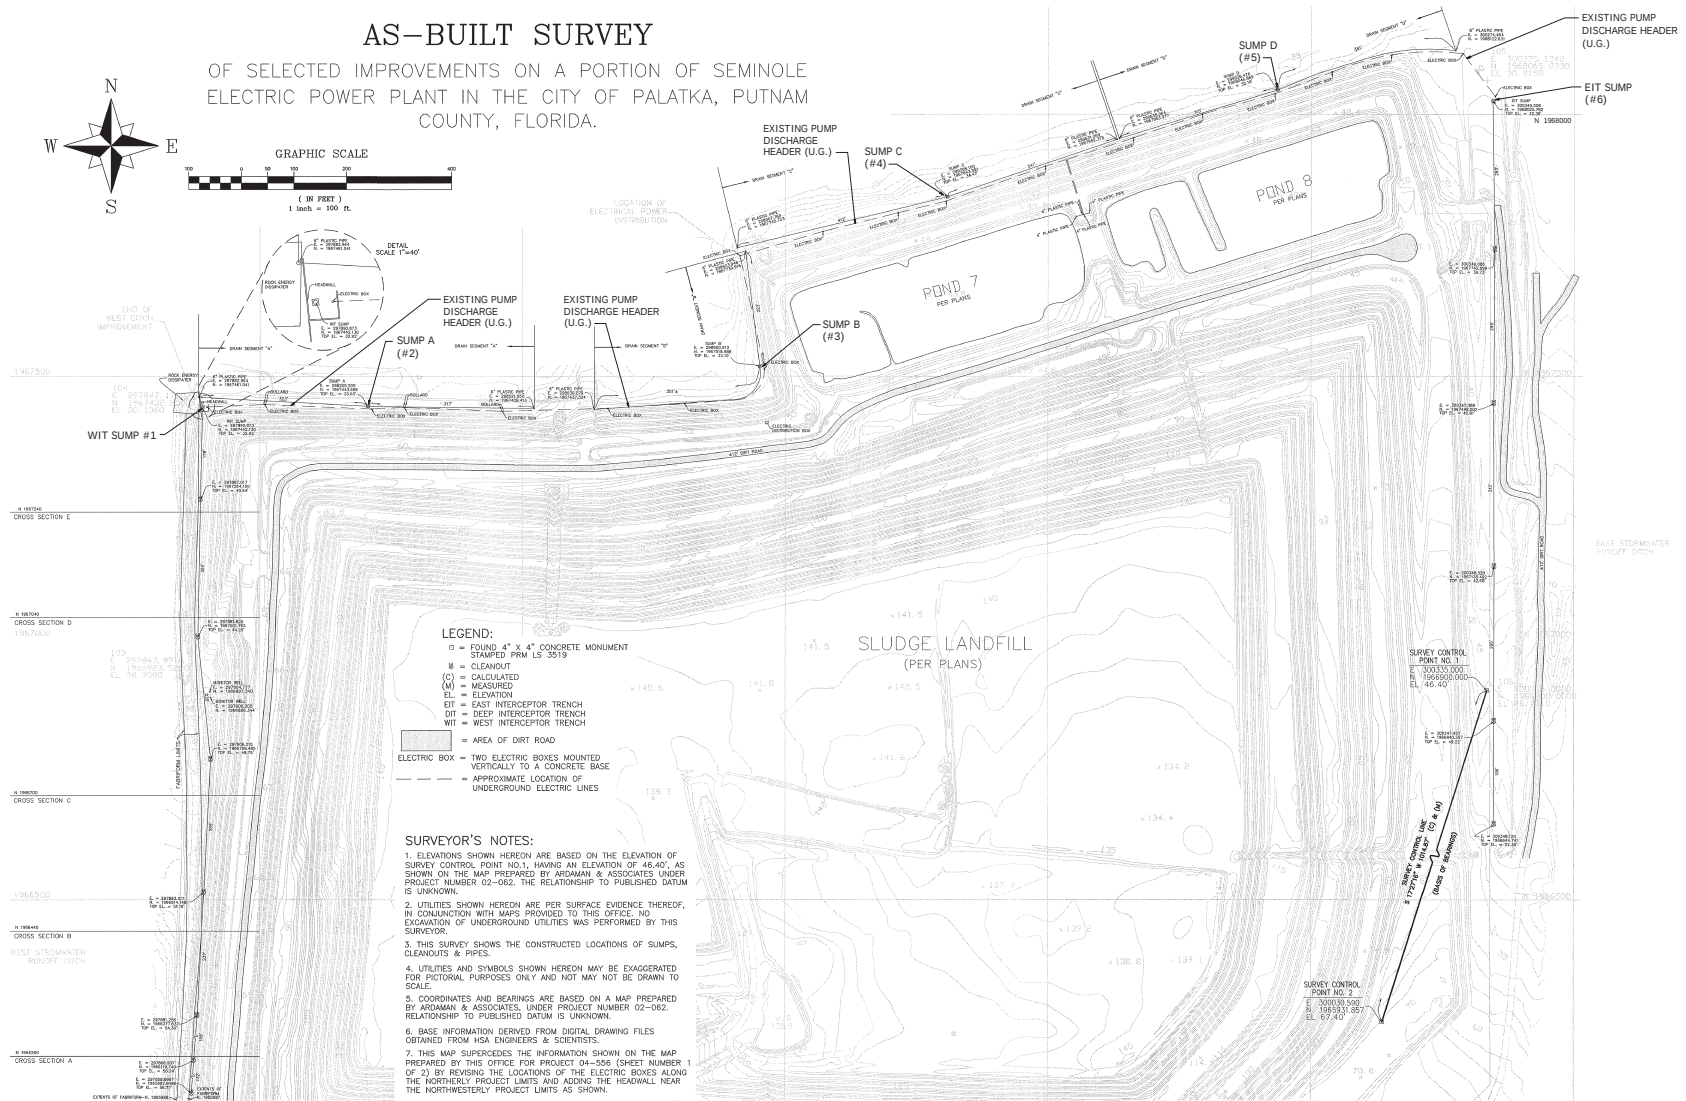

2

REFERENCE DRAWINGS:

009-30-0001-00000	GROUNDWATER REMEDIATION SYSTEM P&ID
009-30-0002-00000	GROUNDWATER REMEDIATION SYSTEM PLAN AND DETAILS


PROPOSED DISCHARGE
PIPING MODIFICATIONS
3/26/12








DATE	BY	CHKD	APP'D	REV	DESCRIPTION
3/26/12	ALT	ALT	ALT	1	PLAN AND DETAILS SSS UNITS 1 & 2 LANDFILL GROUNDWATER REMEDIATION SYSTEM SUMP PUMP DISCHARGE PIPING
3/26/12	ALT	ALT	ALT	2	

CC-35589-002-0003 2

Attachment B

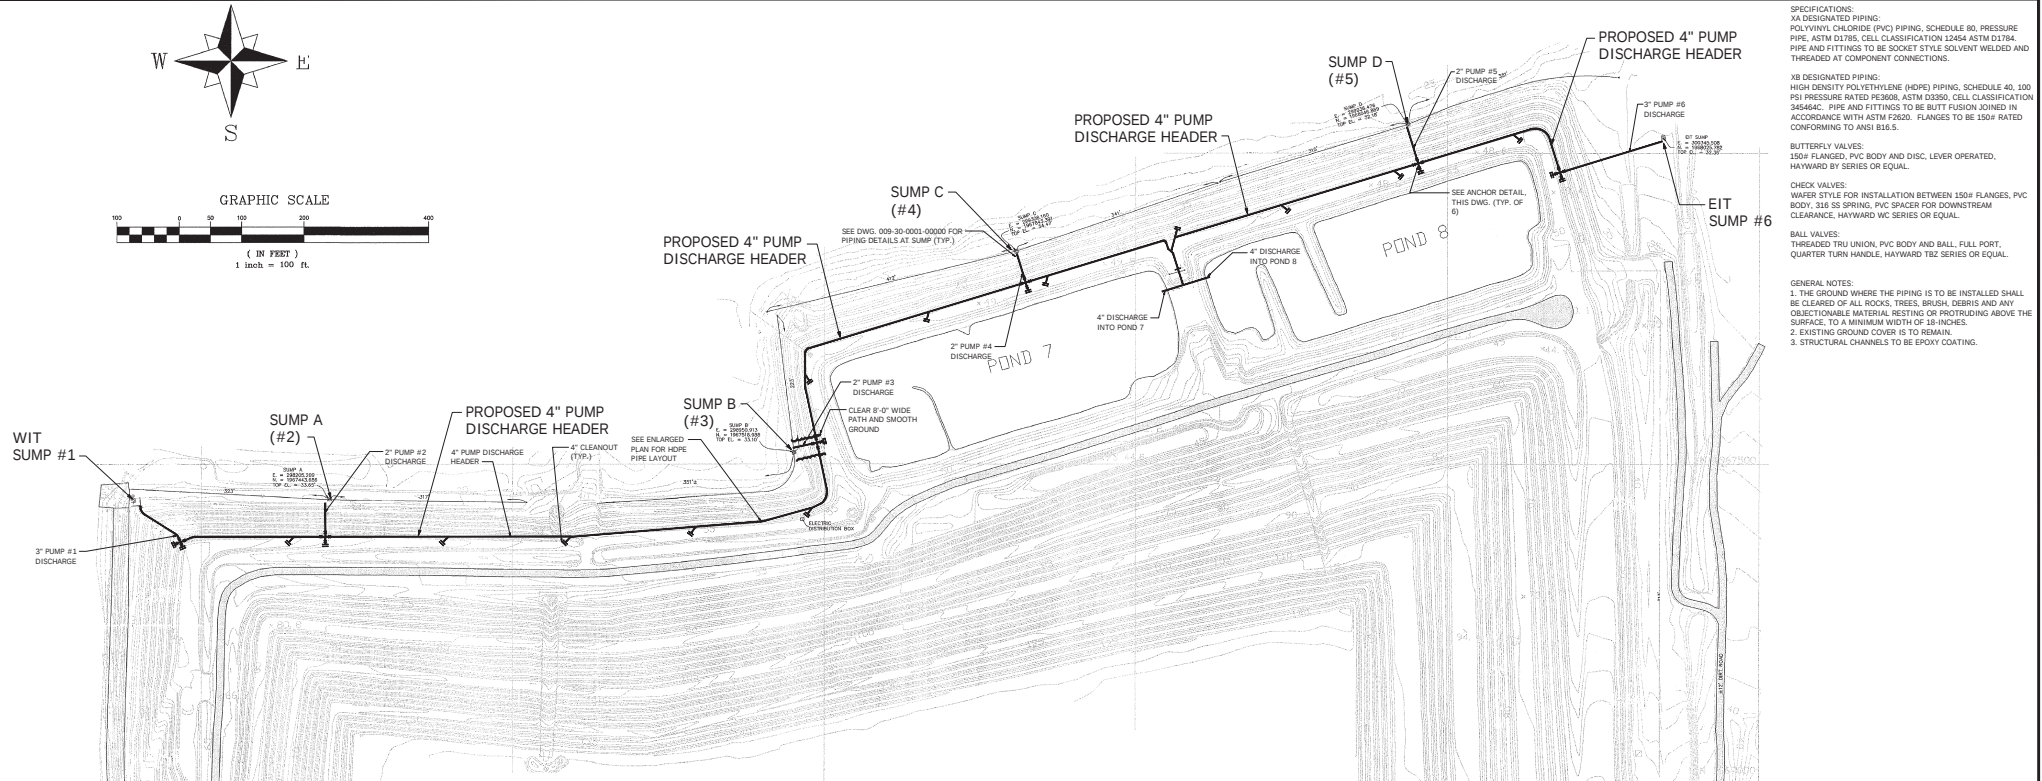

PIPING PLAN
SCALE: 1" = 100'-0"

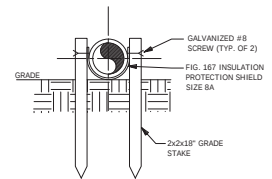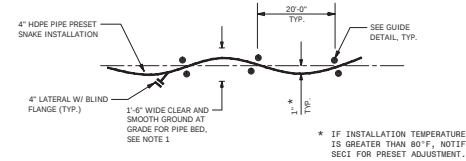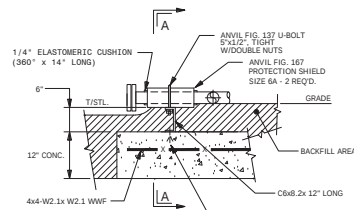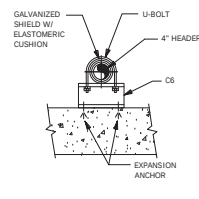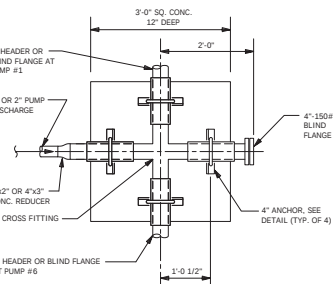


REFERENCE DRAWINGS:

- CC-35588-002-0001 GROUNDWATER REMEDIATION SYSTEM AS-BUILT CONSTRUCTION DRAWINGS INDEX
- CC-35588-002-0002 SITE PLAN
- CC-35588-002-0003 AS-BUILT SURVEY OF SELECTED IMPROVEMENTS
- CC-35588-002-0004 SECTION DETAILS
- CC-35588-002-0005 AS-BUILT SURVEY OF SELECTED IMPROVEMENTS
- CC-35588-002-0006 MISCELLANEOUS DETAILS
- CC-35588-002-0007 ELECTRICAL DIAGRAM
- 009-30-0001-00000 GROUNDWATER REMEDIATION SYSTEM PLAN

PROPOSED DISCHARGE PIPING MODIFICATIONS
3/26/12

	PLAN AND DETAILS SSS UNITS 1 & 2 LANDFILL GROUNDWATER REMEDIATION SYSTEM SUMP PUMP DISCHARGE PIPING		009-30-0002-00000	0
	35844	009-30-0002-00000		

Attachment C

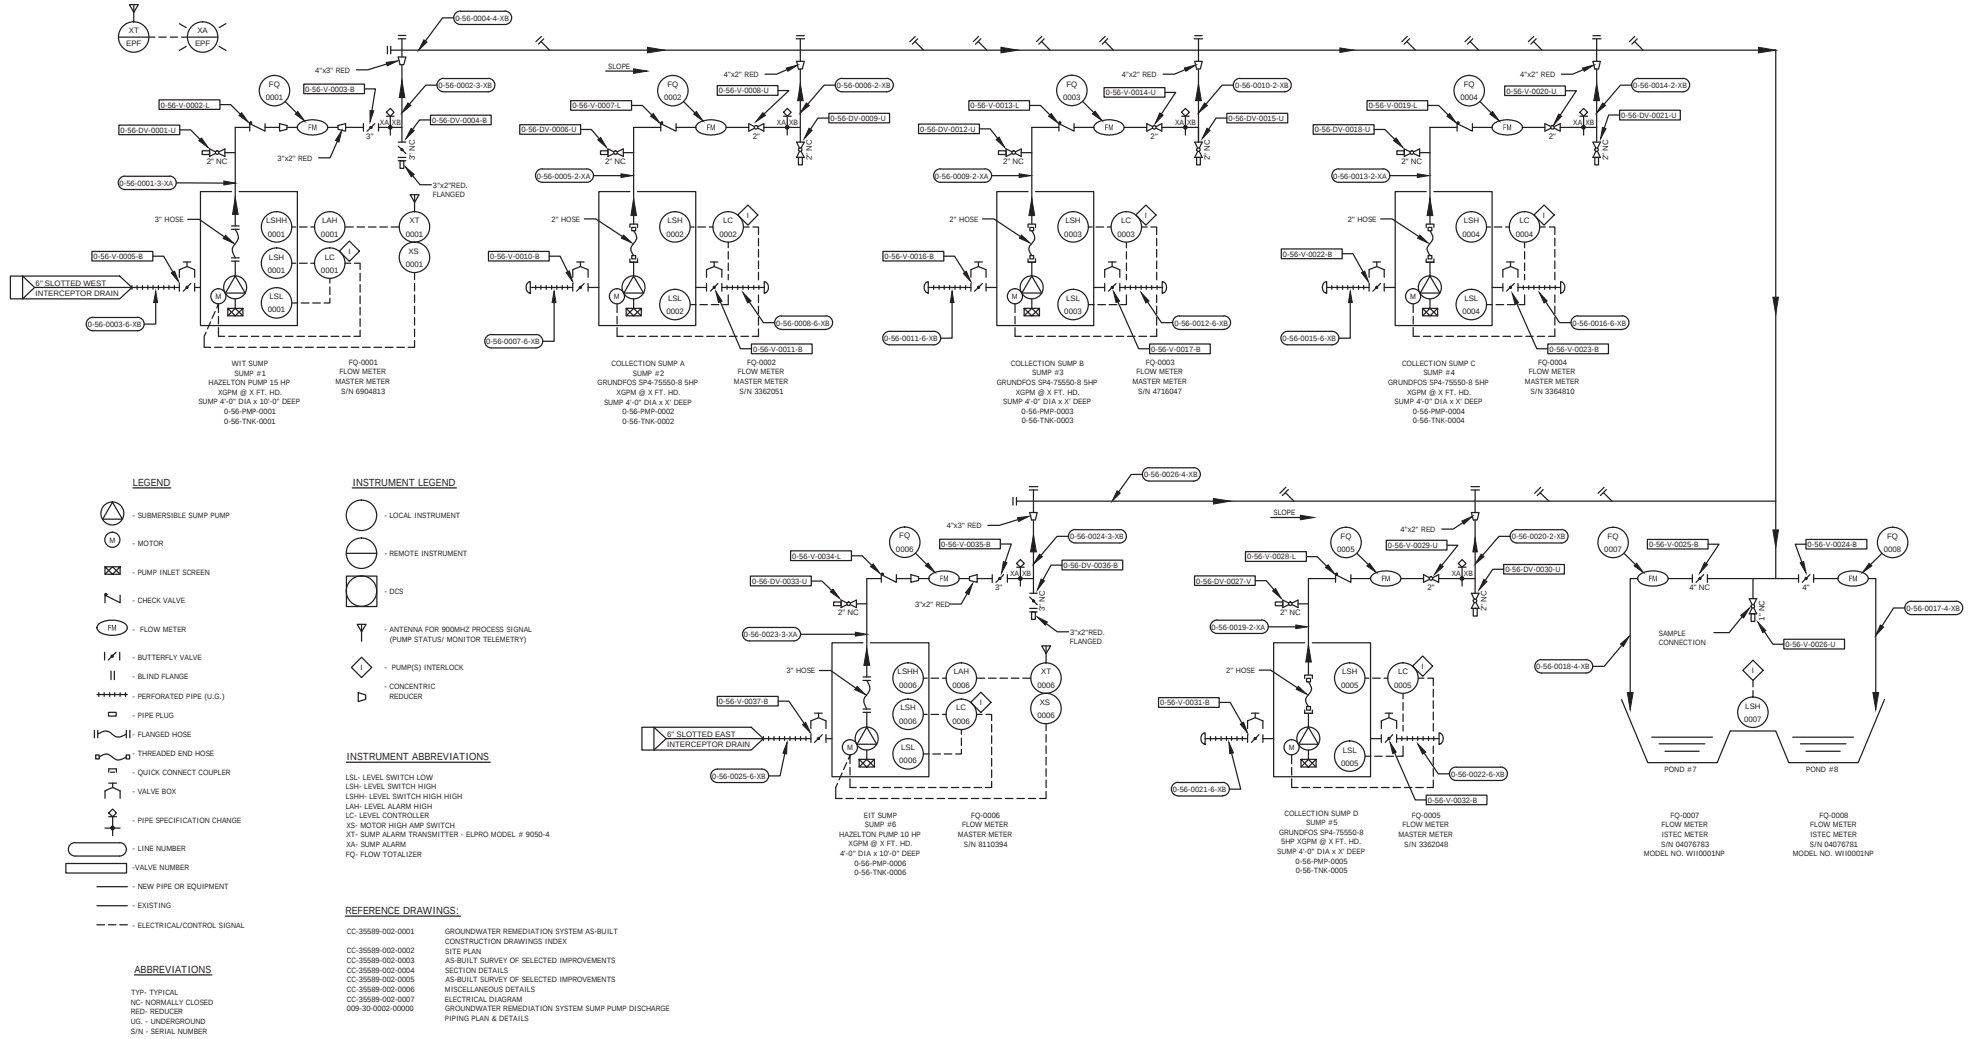

PROPOSED DISCHARGE
PIPING MODIFICATION
3/26/12

 Seminole Electric CO-OPERATIVE, INC.					DATE: 03/21/12 REV: 0 BY: KLM DATE: 03/21/12		TITLE: Reclamation of the remains of abandoned landfill consisting of the excavation and removal of the landfill material without any disturbance to the underlying groundwater.		P&ID SGS UNIT 1 & 2 LANDFILL GROUNDWATER REMEDIATION SYSTEM			
REV. DESCRIPTION					DATE	BY	APPD.	SCALE		PROJECT NO.	SEC. DWG. NO.	REV.
0	P&ID TRENCH EXIST DETAIL: EXIST FOR LANDFILL REMEDIATION				03/21/12	03/21/12	KLM		NONE 0 = 20:000	35844	009-30-0001-00000	0