


LIMITS OF INCREMENT
1 BUILDOUT

SITE PLAN 1
SCALE: 1" = 200'

FILLING PLAN					
Lift	Elevation	Volume Cu. Yd	Life Months	Start Date	End Date
1	Liner to EL. 95	800,000	32	Mar-2012	Oct-2014
2	95 - 115	700,000	28	Oct-2014	Feb-2017
3	115 - 135	600,000	24	Feb-2017	Jan-2019
4	135 - 155	475,000	19	Jan-2019	Aug-2020
5	155 - 175	350,000	14	Aug-2020	Oct-2021
6	175 - 206	300,000	12	Oct-2021	Oct-2022
Totals		3,225,000	129	Mar-2012	Oct-2022

ASSUMPTIONS:
300,000 TONS PER YEAR (25,000 TONS/MONTH)
@ 1 TON/CUBIC YARD

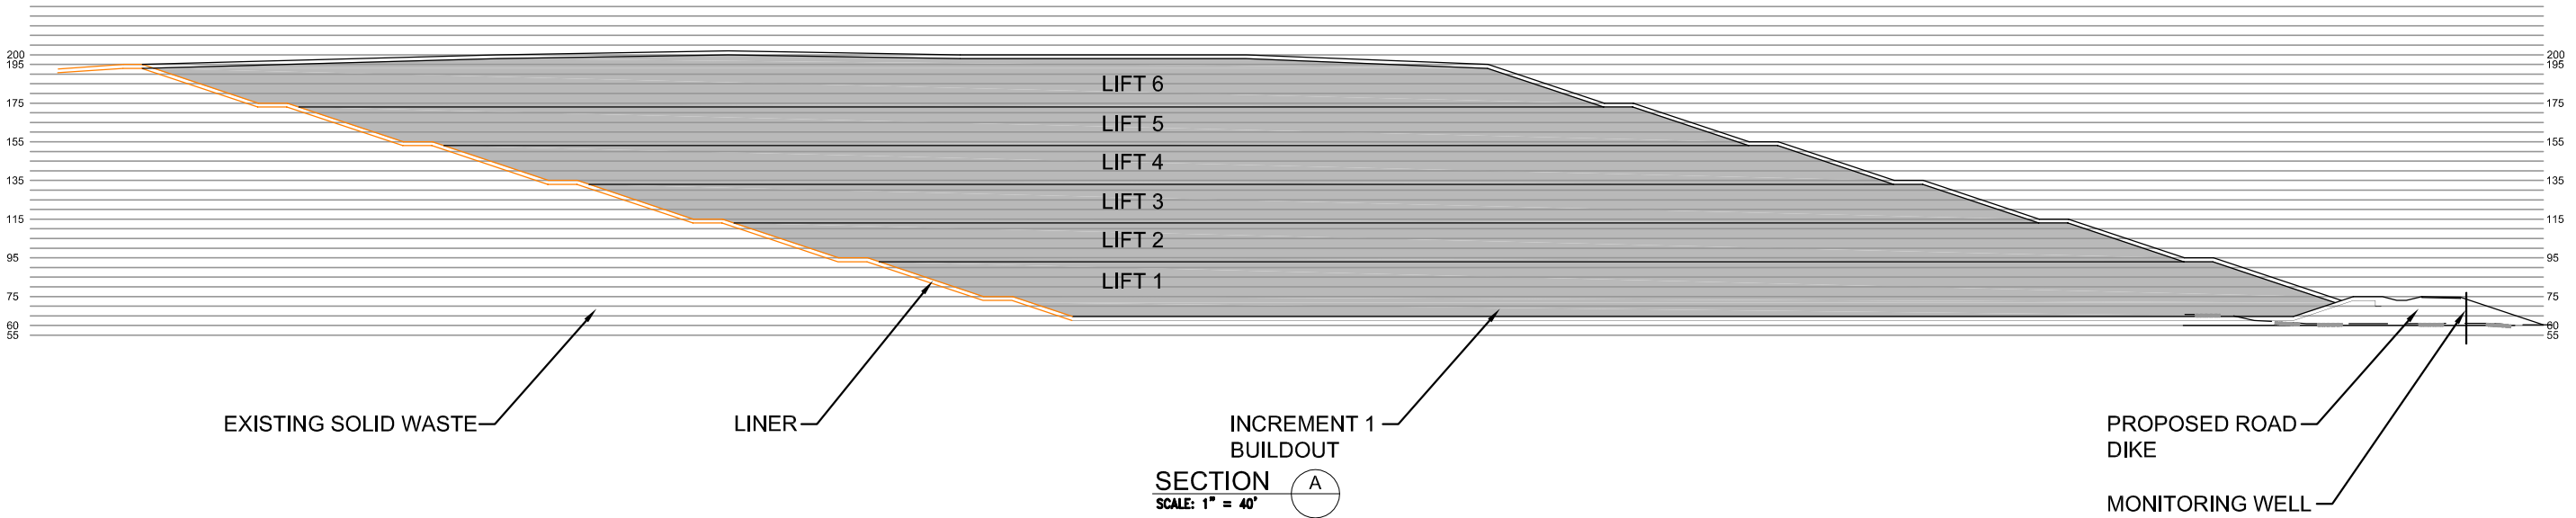

482 South Keller Road
ORLANDO, FL 32810-6101
TEL (407) 647-7275
FAX (407) 647-0624
WWW.PBS&J.COM
POST BUCKLEY, SCHUH & JERNIGAN, Inc.
d/b/a PBS&J
5300 West Cypress Street Suite 200
Tampa, FL 33607
FBPR Certificate of Authorization No.: 24

CLIENT

**SEMINOLE ELECTRIC
COOPERATIVE, INC**

(SECI)

PROJECT

**INCREMENT 1 BUILDOUT AT
SEMINOLE GENERATING STATION**

(SGS)

TASK

**OPERATION PLAN
FILLING PLAN**


ORIGINAL JULY 2010
REVISIONS:
1. _____
2. _____
3. _____
4. _____
5. _____

6. _____
7. _____
8. _____
9. _____
10. _____
11. _____
12. _____

Name: _____
Florida P.E. No.: _____
Address: PBS&J
482 S. Keller Road
Orlando, FL 32810-6101
Signature _____ Date _____

JOB NO. **100013496**
DRAWN **RGC**
DESIGN **RGC/JLM**
CHECKED **JLM**
Q.C. **DED**

SHEET 1/3

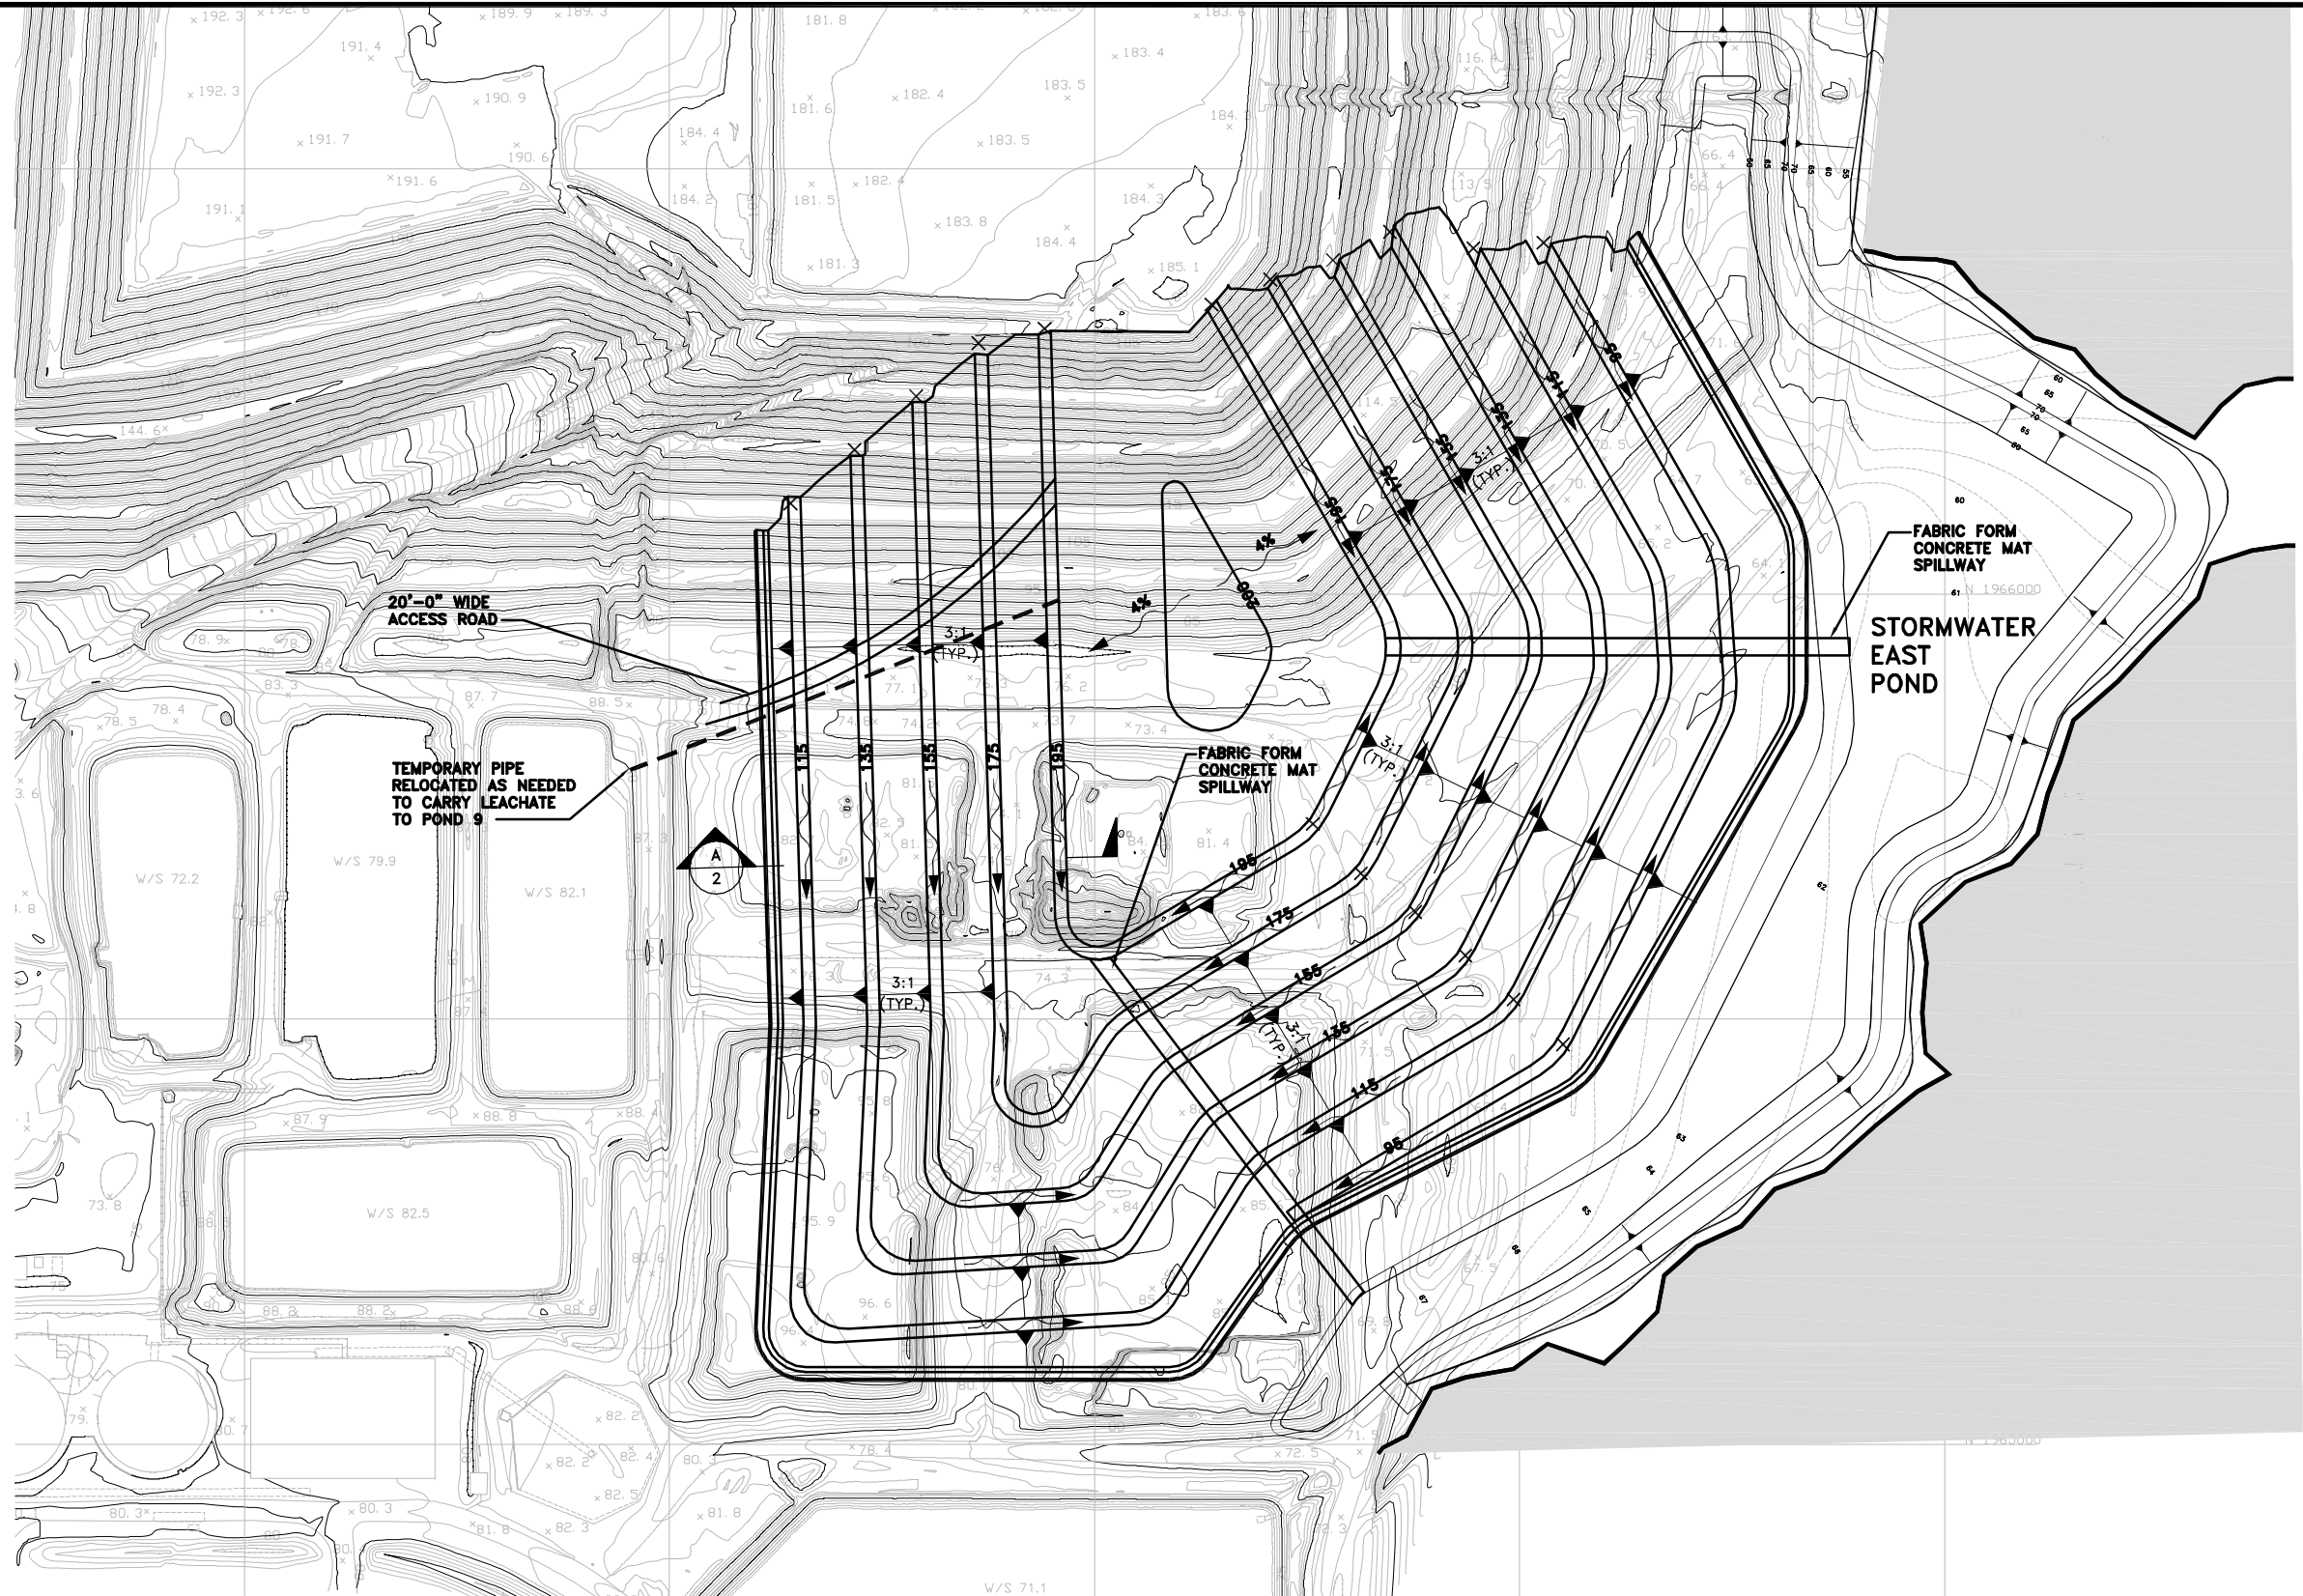

050100200

GRAPHIC SCALE
SCALE: 1" = 100'

NORTH

LEGEND:

0.2 % DIRECTION OF
SLOPE AND GRADE
FOR STORM WATER

X

TERRACE HIGH POINT

SITE PLAN 1
SCALE: 1" = 200'

U:\081113\CONCRETE\WATERMAN\SEMINOLE ELECTRIC-PALATKA\VERTICAL EXPANSION DESIGN\IE FINAL CLOSURE PLAN.dwg JUNE 2010 - 4:57pm Revised By: 22427

PBS&J

482 South Keller Road
ORLANDO, FL 32810-6101
TEL (407) 647-7275
FAX (407) 647-0624
WWW.PBSJ.COM
POST: BUCKLEY, SCHUH & JERNIGAN, Inc.
615/g PBS&J
5500 West Cypress Street Suite 200
Tampa, FL 33607
FBR Certificate of Authorization No.: 24

CLIENT

**SEMINOLE ELECTRIC
COOPERATIVE, INC**
(SECI)

PROJECT

**INCREMENT 1 BUILDOUT AT
SEMINOLE GENERATING STATION**
(SGS)

TASK

**FINAL GRADING PLAN
FOR CLOSURE**

ORIGINAL JULY 2010
REVISIONS:

1.

2.

3.

4.

5.

6.

7.

8.

9.

10.

11.


12.

Name:
Florida P.E. No.:
Address: PBS&J
482 S. Keller Road
Orlando, FL 32810-6101


Signature _____ Date _____

JOB NO.100013496
DRAWN **RGC**
DESIGN **RGC/JLM**
CHECKED **JLM**
Q.C. **DED**


SHEET 2/3

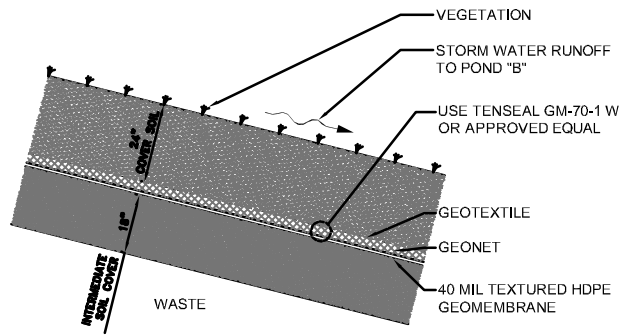

TYPICAL FINAL LANDFILL CLOSURE CAP
SCALE: N.T.S.

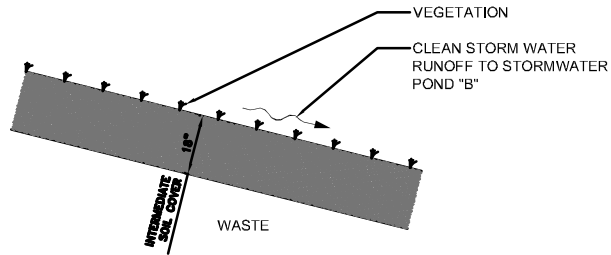

TYPICAL INTERMEDIATE SOIL COVER
SCALE: N.T.S.

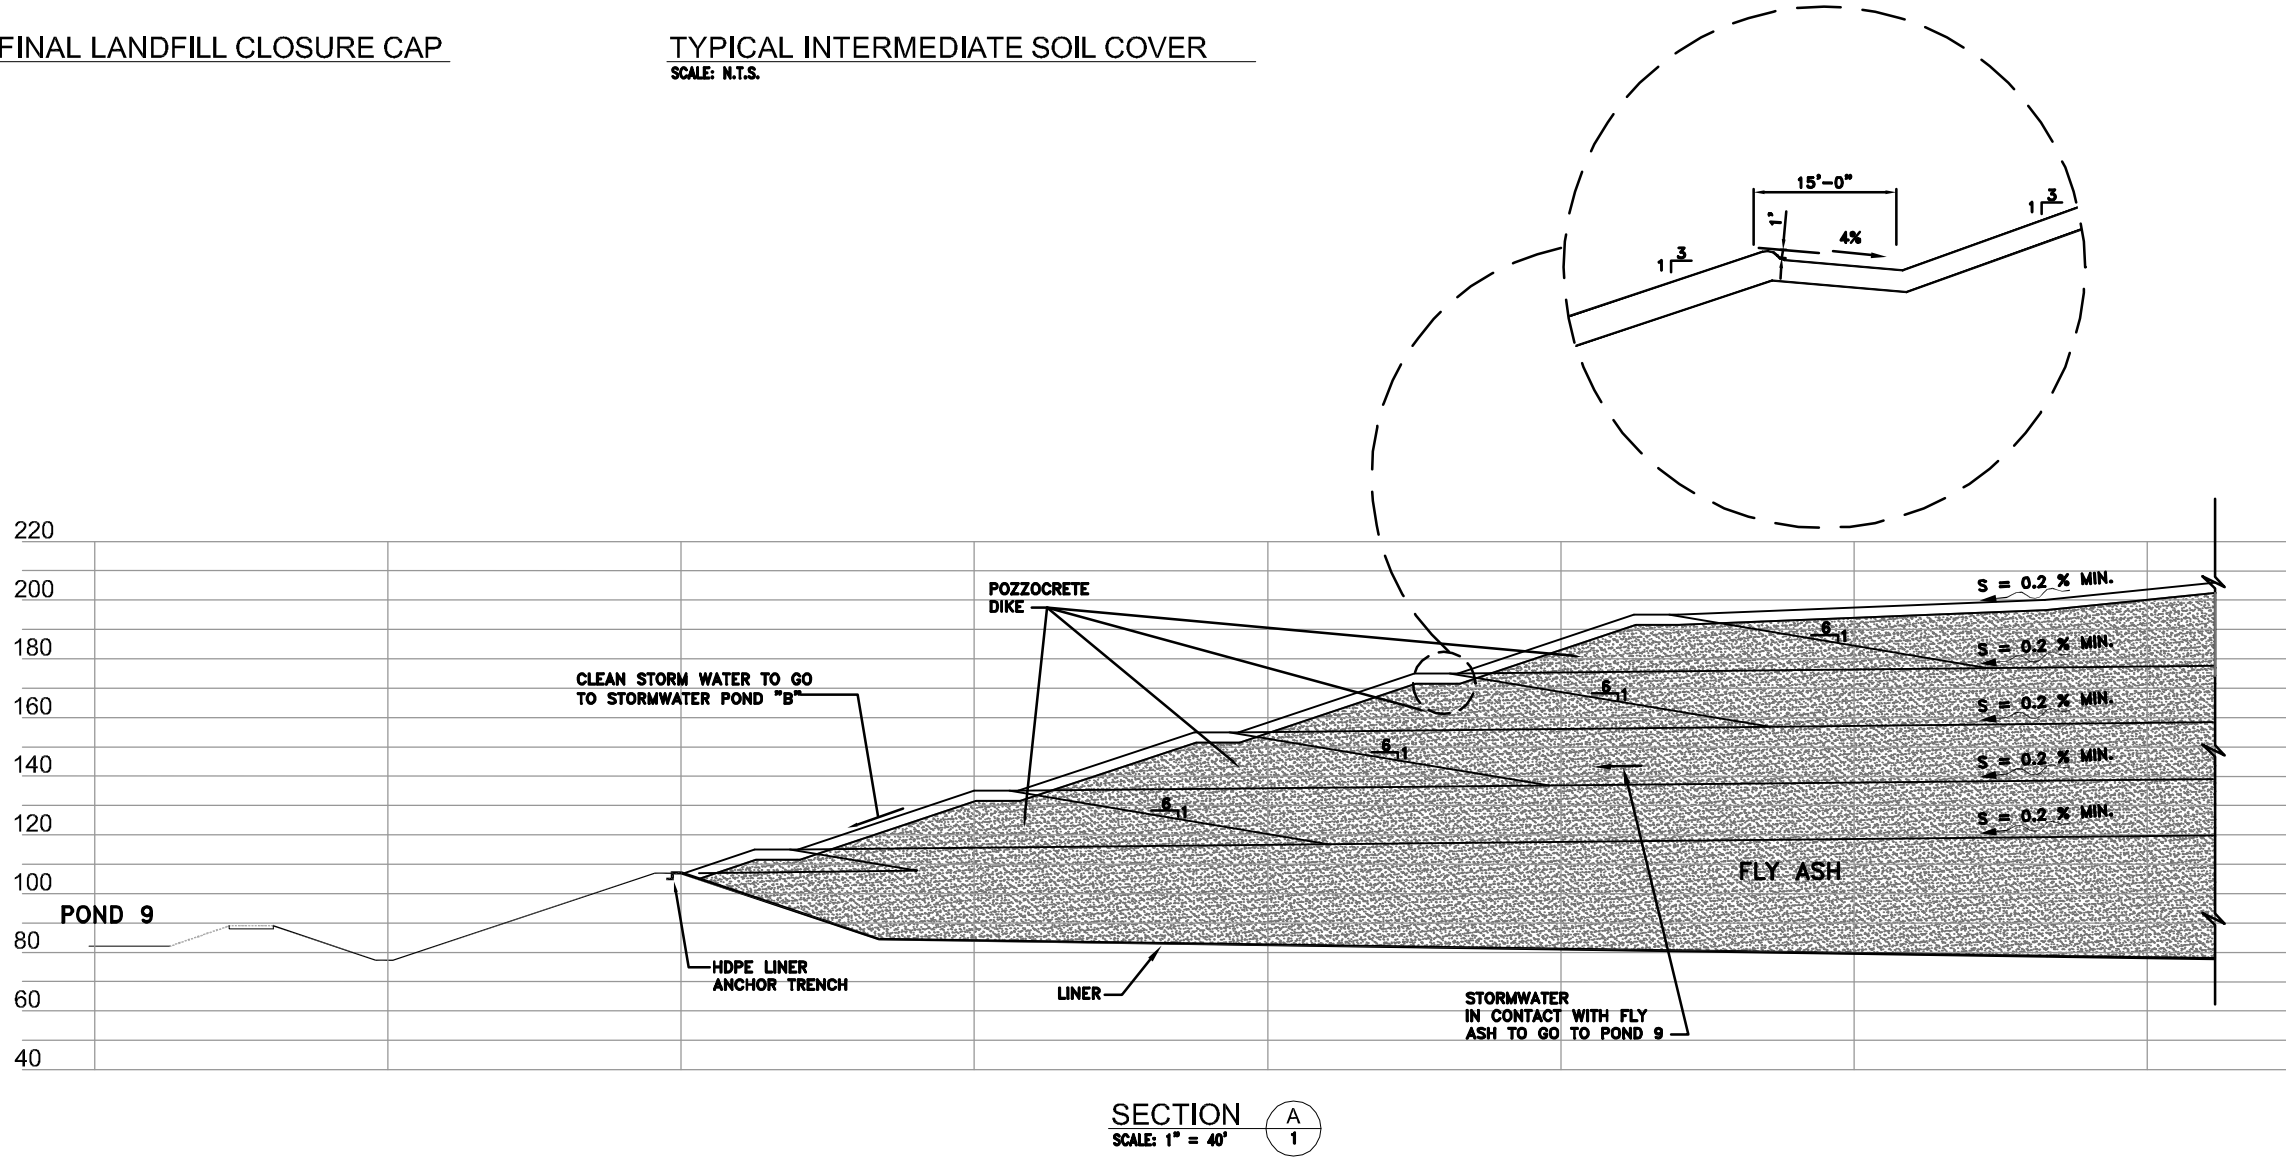

SECTION A-A
SCALE: 1" = 40'

U:\GIS\3\TAMPA\WATERMAIN\TAMPA ELECTRIC-PALATKA\VERTICAL EXPANSION DESIGN\IE_FINAL_CLOSURE_PLAN.dwg JAGT,2010 - 4:56pm Modified By: 22427



482 South Keller Road
ORLANDO, FL 32810-6101
TEL (407) 647-7275
FAX (407) 647-0624
WWW.PBSJ.COM
POST BUCKLEY, SCHUH & JERNIGAN, Inc.
675 G. PBS&J
5500 West Cypress Street Suite 200
Tampa, FL 33607
FBPR Certificate of Authorization No.: 24

CLIENT

SEMINOLE ELECTRIC
COOPERATIVE, INC
(SECI)

PROJECT

INCREMENT 1 BUILDOUT AT
SEMINOLE GENERATING STATION
(SGS)

TASK

OPERATION PLAN

ORIGINAL JULY 2010

REVISIONS:

1. _____
2. _____
3. _____
4. _____
5. _____

6. _____
7. _____
8. _____
9. _____
10. _____
11. _____
12. _____

Name: _____
Florida P.E. No.: _____
Address: PBS&J
482 S. Keller Road
Orlando, FL 32810-6101
Signature _____ Date _____

JOB NO. 100013496
DRAWN: RGC
DESIGN: RGC/JLM
CHECKED: JLM
Q.C.: DED

SHEET 3/3